



RENDERING

FOR ILLUSTRATION ONLY

NOTICE, DISCLAIMER AND COPYRIGHT

THIS DRAWING IS OWNED AND/OR LICENSED BY CHIEF ARCHITECT, INC. AND IS SOLELY FOR DEMONSTRATIVE AND ILLUSTRATIVE PURPOSES AS A WAY TO HELP YOU MORE QUICKLY LEARN AND BETTER UNDERSTAND THE FUNCTIONAL CAPABILITIES OF THE SOFTWARE PROGRAM. YOU AGREE, UNDER THE LICENSE AGREEMENT, THAT YOU WILL NOT REPRODUCE, DISTRIBUTE OR USE THIS SAMPLE DRAWING FOR ANY OTHER PURPOSE WITHOUT THE PRIOR WRITTEN CONSENT OF CHIEF ARCHITECT, INC.

CHIEF ARCHITECT MAKES NO WARRANTY WHATSOEVER WITH REGARD TO ITS SAMPLE DRAWINGS SOLELY FOR DEMONSTRATIVE AND ILLUSTRATIVE PURPOSES. CHIEF ARCHITECT MAKES NO WARRANTY THAT THE DIMENSIONS IN THESE SAMPLE DRAWINGS ARE ACCURATE AND FREE OF DISCREPANCIES. CHIEF ARCHITECT MAKES NO WARRANTY THAT THESE SAMPLE DRAWINGS COMPLY WITH ANY BUILDING CODES. THESE SAMPLE DRAWINGS ARE PROVIDED TO YOU "AS IS," AND CHIEF ARCHITECT AND THE LICENSORS OF THESE SAMPLE DRAWINGS DISCLAIM ANY AND ALL WARRANTIES WITH RESPECT TO THESE SAMPLE DRAWINGS, WHETHER EXPRESS OR IMPLIED OR ARISING BY CUSTOM OR TRADE USAGE, AND, SPECIFICALLY, MAKE NO WARRANTY OF MERCHANTABILITY OR FITNESS FOR ANY PARTICULAR PURPOSE.


UNDER NO CIRCUMSTANCES WILL CHIEF ARCHITECT, ITS RESELLERS, ITS DISTRIBUTORS OR THE LICENSORS OF THE SAMPLE DRAWINGS BE LIABLE FOR ANY DAMAGES, WHETHER ARISING FROM TORT OR CONTRACT, INCLUDING LOSS OF DATA, LOST PROFITS, COST OF COVER, OR OTHER SPECIAL, INCIDENTAL, CONSEQUENTIAL OR INDIRECT DAMAGES ARISING OUT OF THE USE OF THESE SAMPLE DRAWINGS. PLEASE REFER TO YOUR END USER SOFTWARE LICENSE AGREEMENT FOR MORE INFORMATION ABOUT THE TERMS AND CONDITIONS PURSUANT TO THESE.

CLIENT: _____
ADDRESS: _____
FIRE DISTRICT: _____
WATER/SEWER: _____

BUILDING PERMIT: _____

DESIGNER: _____
BUILDER: _____
ENGINEERING: _____



TABLE OF CONTENTS	
PROJECT SUMMARY	1
FLOOR PLAN	2
KITCHEN PLAN	3
KITCHEN ELEVATIONS	4
ELECTRICAL PLAN	5
BATH CONSTRUCTION PLAN	6
BATH SUITE PLAN	7
BATH SUITE ELEVATIONS	8

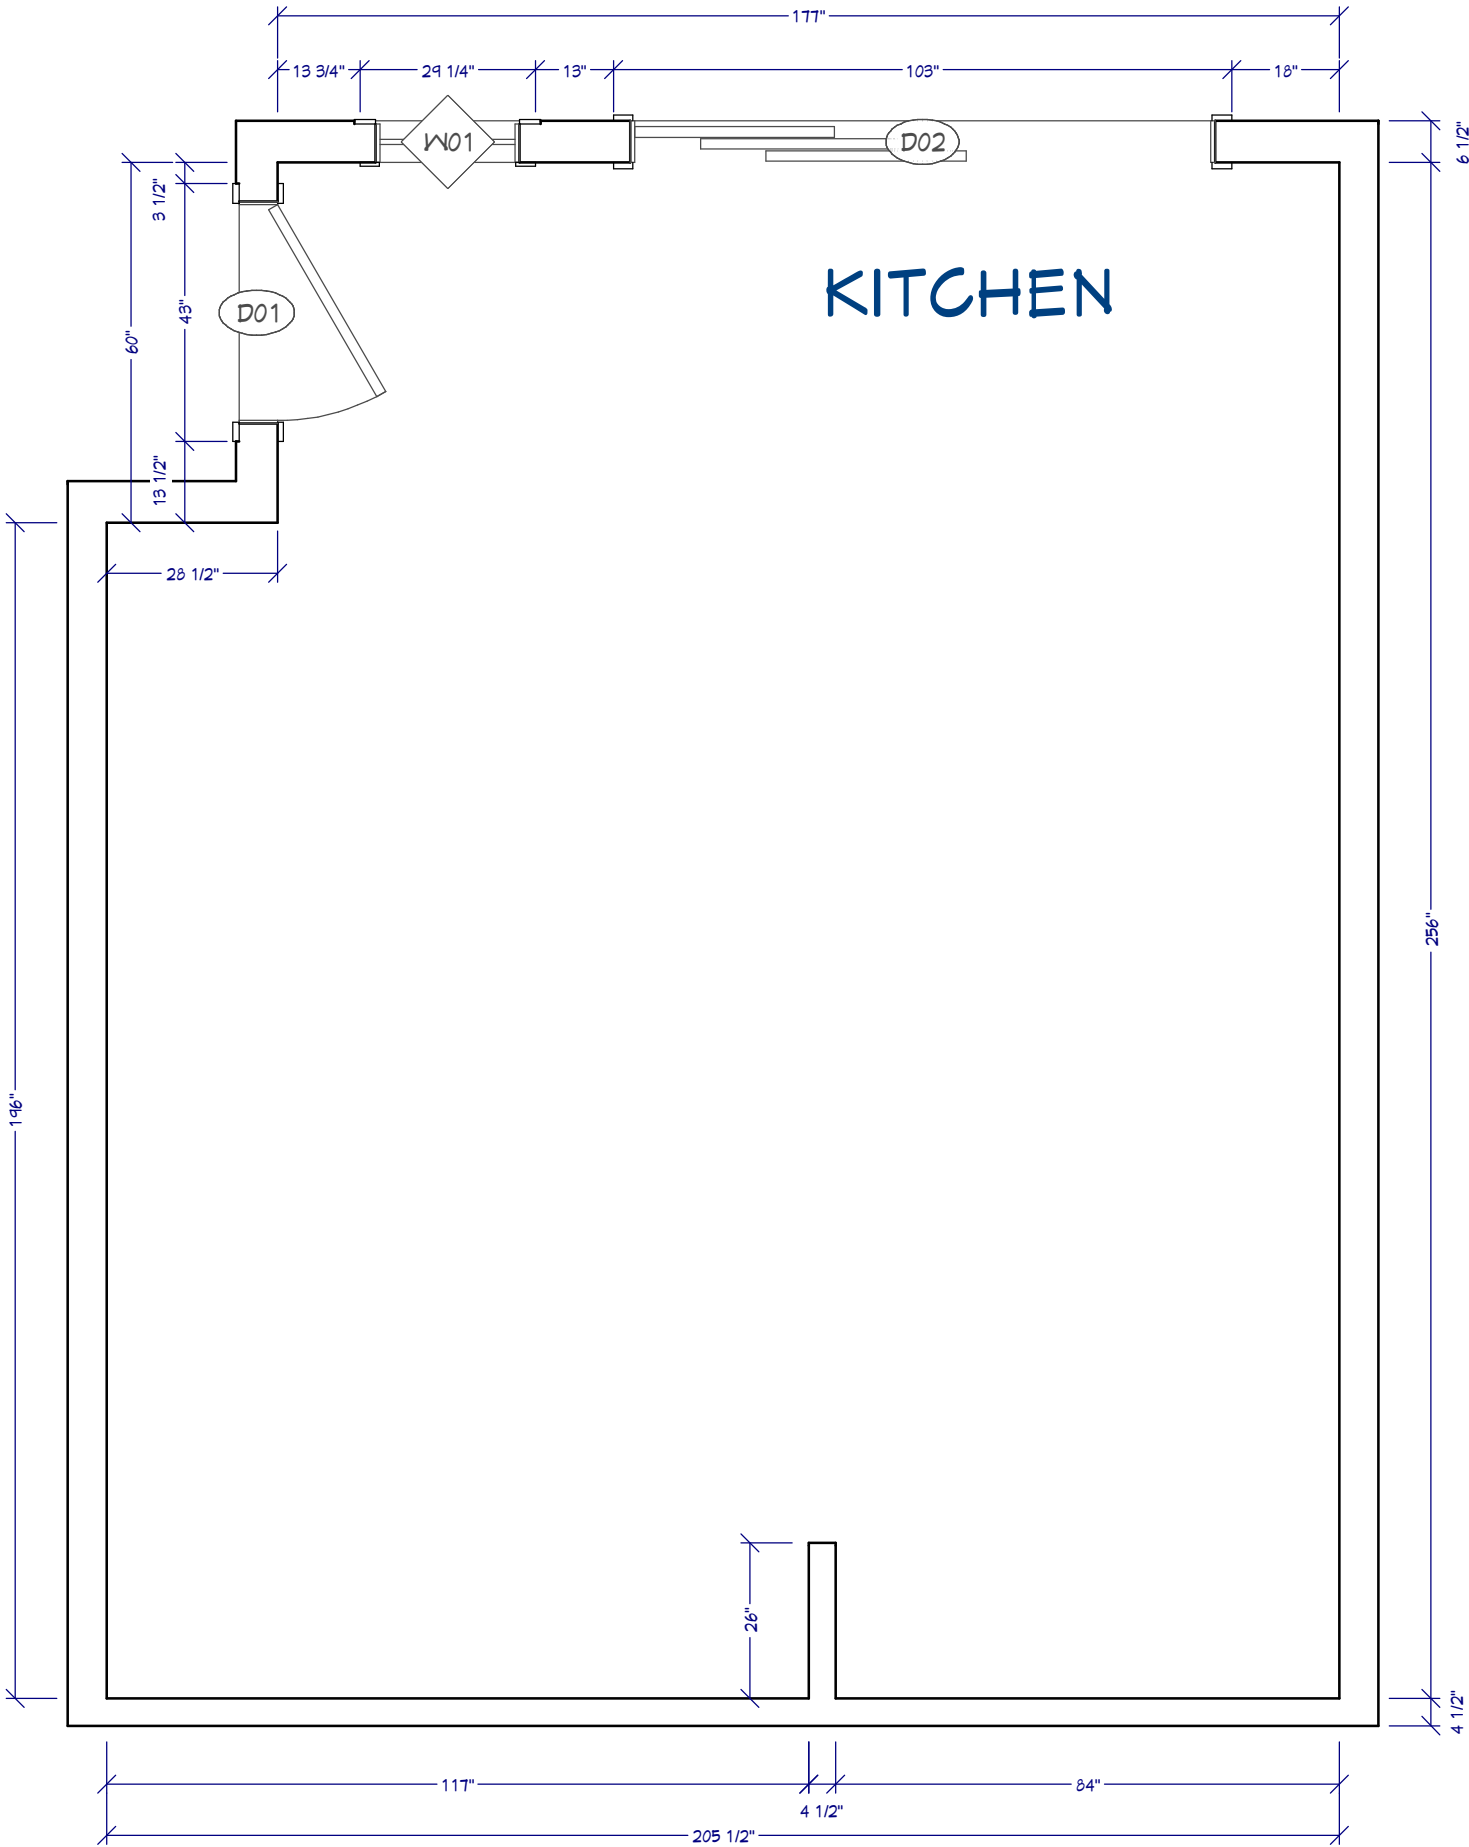



FLOOR PLAN

3/8" = 1'

 
- STEPS:
- 1 OPEN A NEW K&B TEMPLATE PLAN & BE IN THE K&B PLAN VIEW
 - 2 USING THE INTERIOR WALL, DRAW THE ROOM SHAPE
 - 3 NAME THE ROOM "KITCHEN"
 - 4 SET FINISHED CEILING HEIGHT TO 10' OR 119 5/8"
 - 5 PLACE DOORS & WINDOW - NOTE: DIMENSIONS ARE TO THE INTERIOR CASING
 - 6 FINALIZE DIMENSIONS
 - 7 SAVE THE PLAN

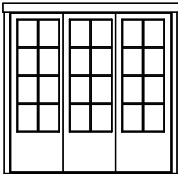DOOR SCHEDULE								
3D EXTERIOR ELEVATION	NUMBER	QTY	WIDTH	HEIGHT	CASING SIZE, INTERIOR	LINTEL SIZE, INTERIOR	TOP (FROM SUBFLOOR)	DESCRIPTION
	D01	1	36 "	96 "	1"X3 1/4"	1 1/4"X5 1/2"	96"	EXT. HINGED-GLASS PANEL
	D02	1	96 "	96 "	1"X3 1/4"	1 1/4"X5 1/2"	96"	EXT. 0+3-PANEL SLIDER-GLASS PANEL

 
WINDOW SCHEDULE								
3D EXTERIOR ELEVATION	NUMBER	QTY	WIDTH	HEIGHT	CASING SIZE, INTERIOR	LINTEL SIZE, INTERIOR	TOP (FROM SUBFLOOR)	DESCRIPTION
	W01	1	24 "	72 "	5/8"x3 1/4"	7/8"x5 1/2"	96 3/8"	FIXED GLASS

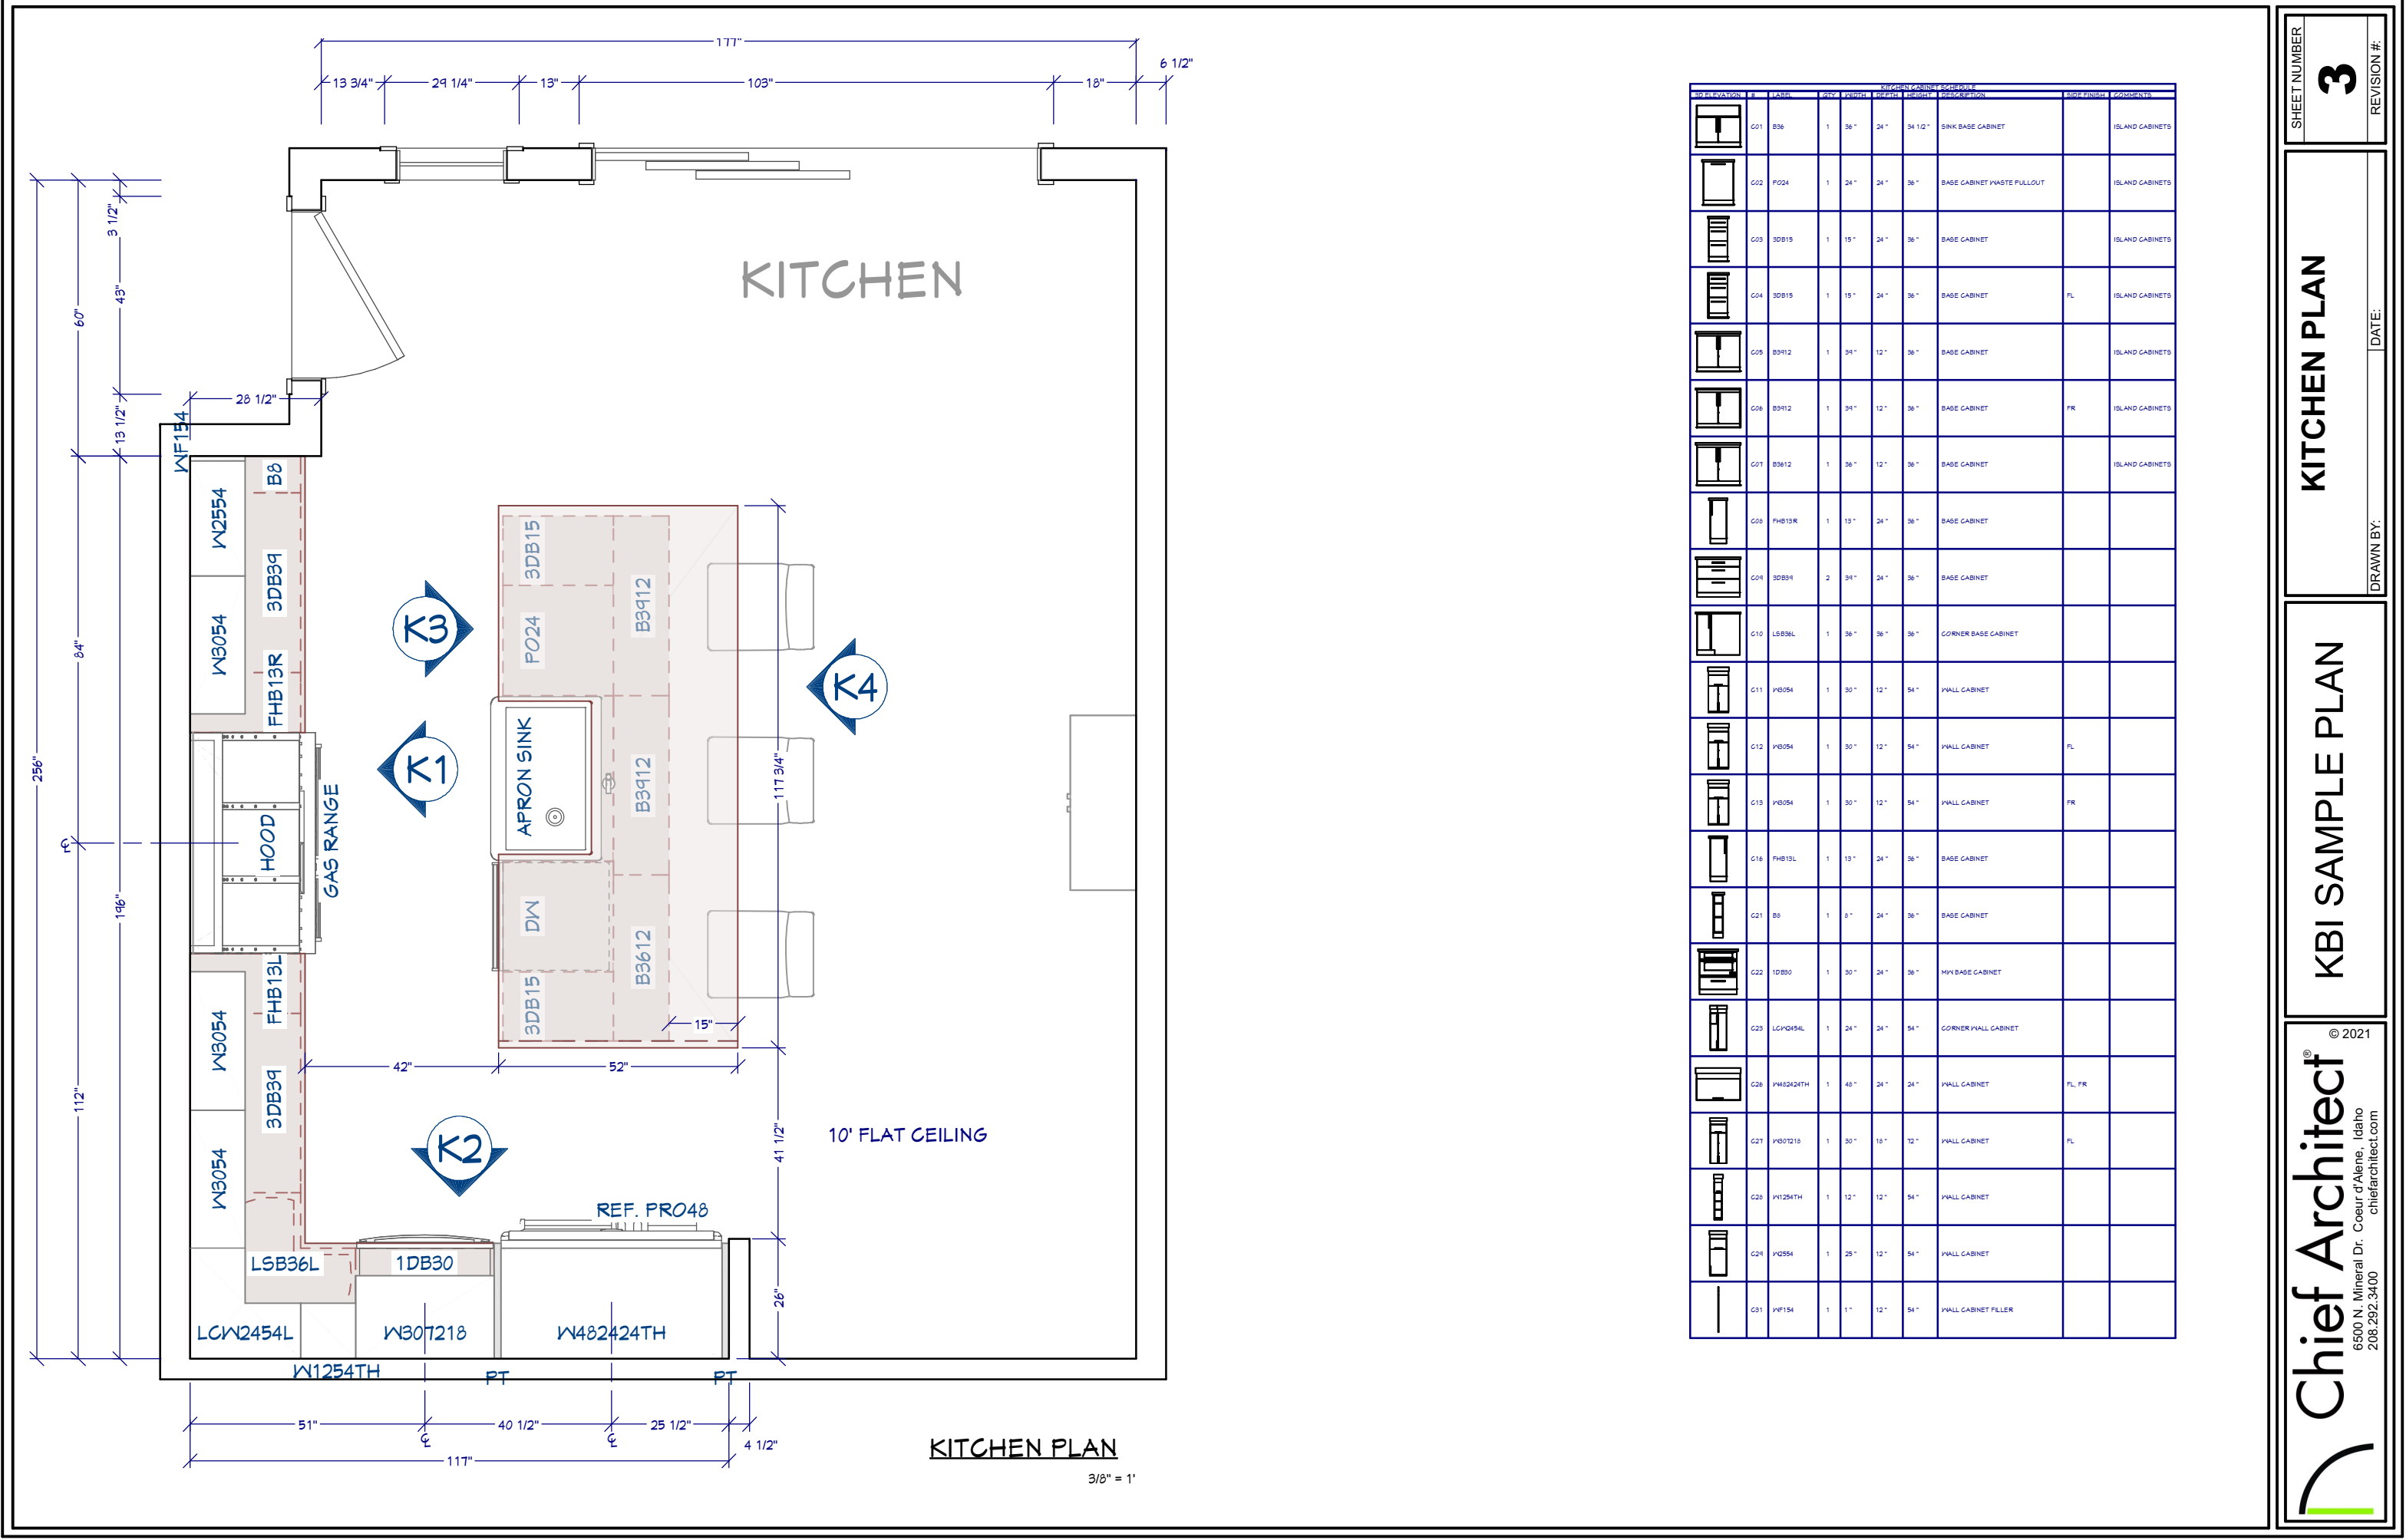


- ① CROWN MOLDING
- ② HOPPER DOOR W/ RAIN WATER GLASS
- ③ UNDER CAB LED LIGHTING & STRIP PLUGS
- ④ OGEE EDGE PROFILE
- ⑤ TILE INLAY W/ 2" MOLDING
- ⑥ GAS COOK RANGE / ELECTRIC OVEN
- ⑦ CUSTOM COOK HOOD
- ⑧ ROLLOUT VERTICAL SHELVES
- ⑨ SUBZERO PRO48 REF.
- ⑩ MICROWAVE DRAWER
- ⑪ COFFEE STATION W/ POCKET DOORS
- ⑫ APRON SINK
- ⑬ WASTE PULLOUT
- ⑭ BUTT EDGE WATERFALL
- ⑮ POPUP OUTLET / USB
- ⑯ FULL LENGTH FRAMED END PANEL
- ⑰ PARTITION - 25" D
- ⑱ CAD CROSS BOX

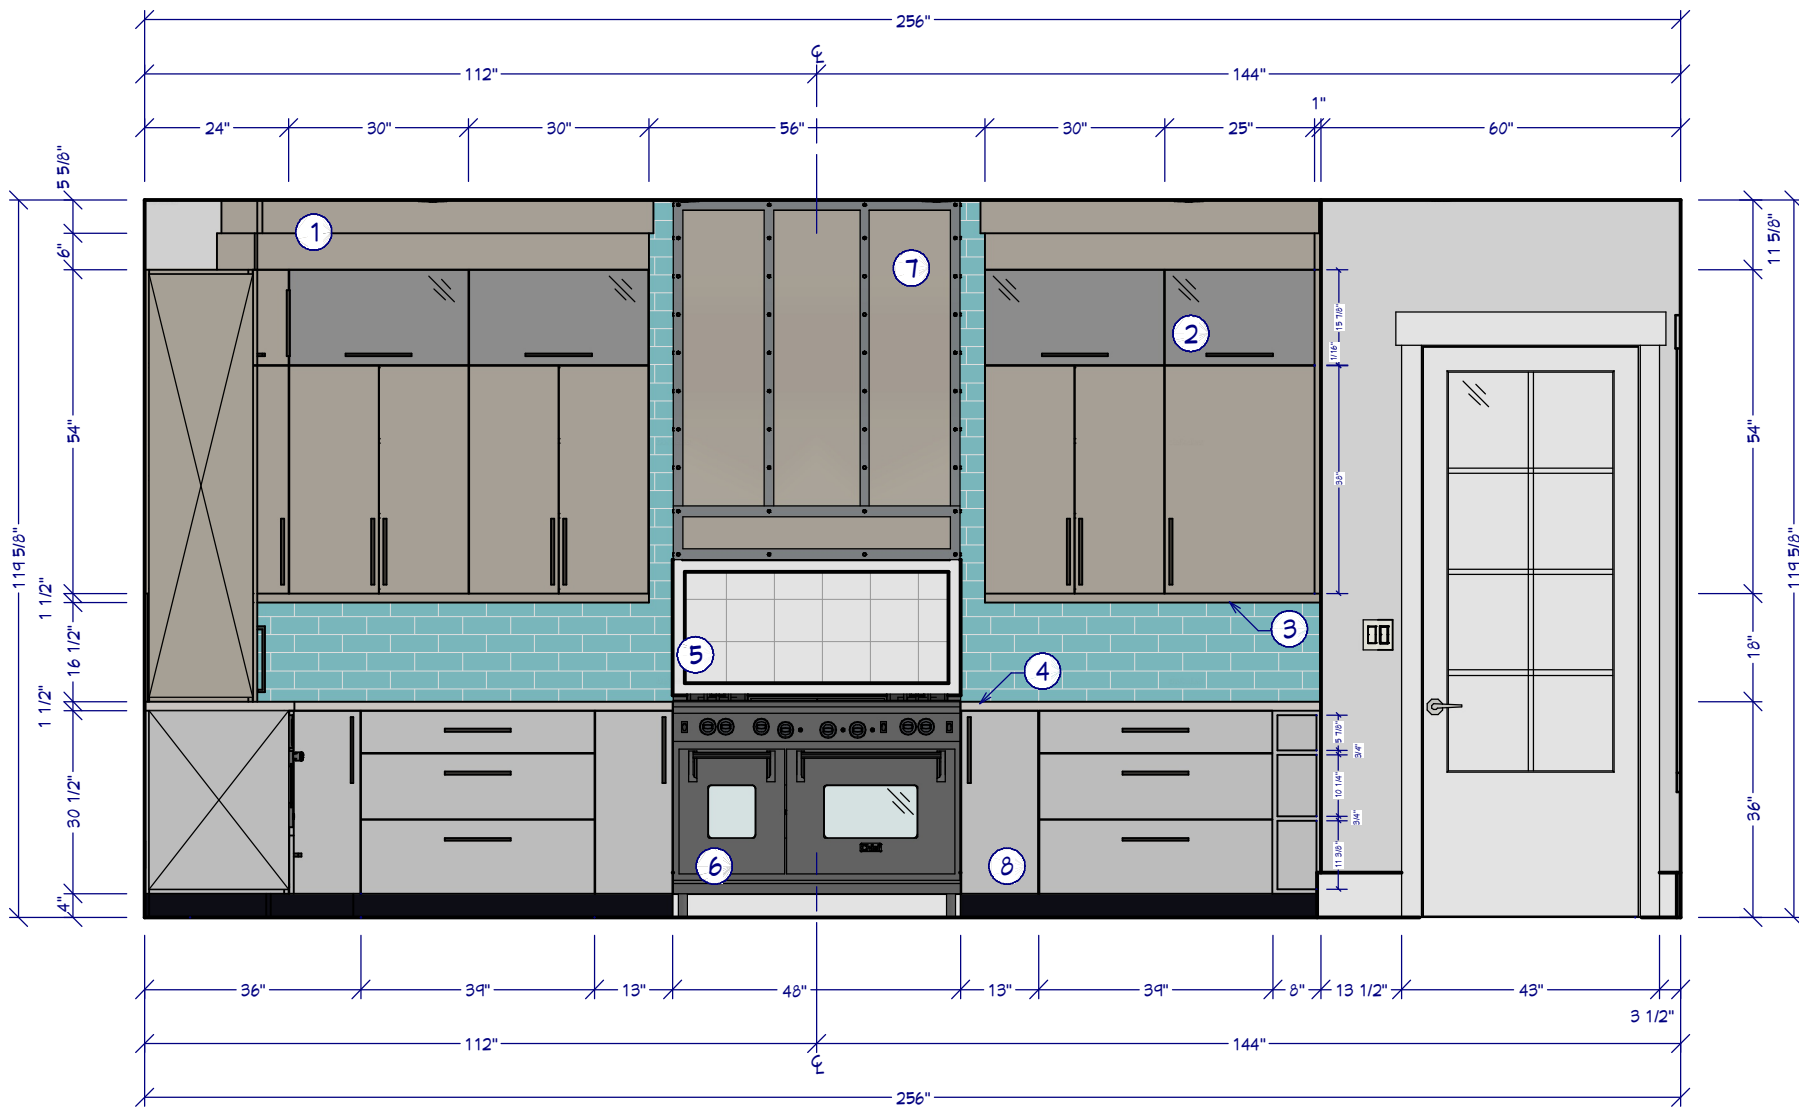


 **K1 MAIN WALL ELEVATION** $\frac{3/8" = 1'}$

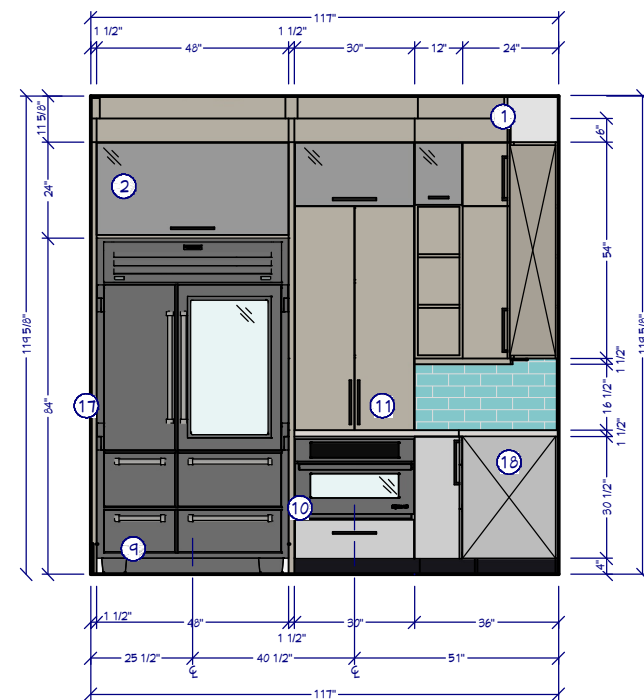

 2ND WALL ELEVATION 1/4" = 1'

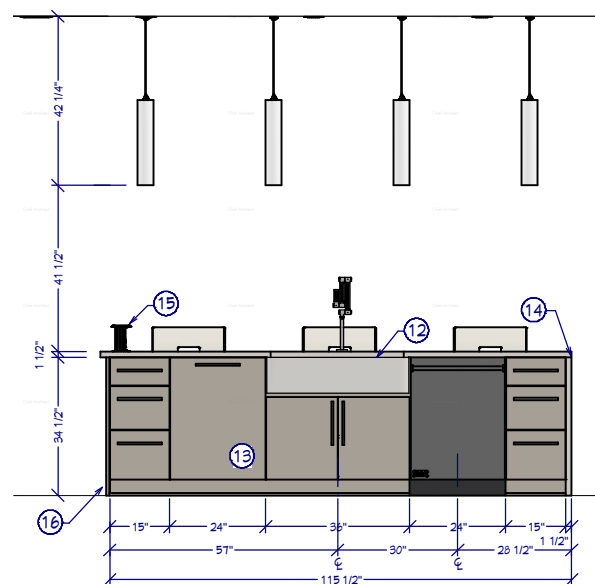


 ISLAND FRONT ELEVATION 1/4" = 1'

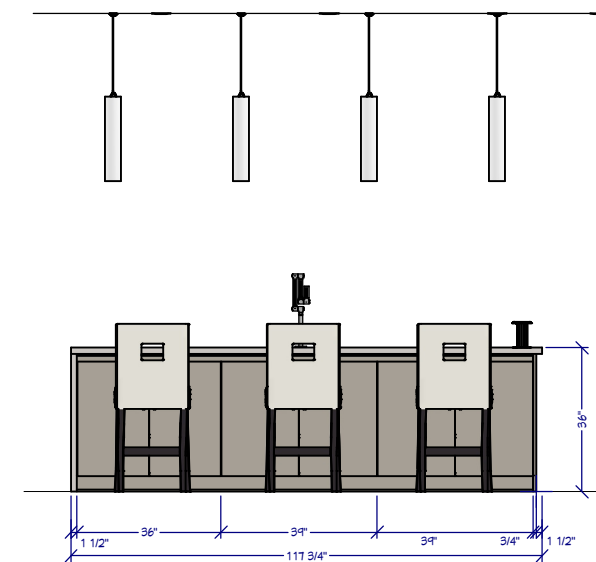

 ISLAND REAR ELEVATION
1/4" = 1'

ELECTRICAL PLAN

3/8" = 1'

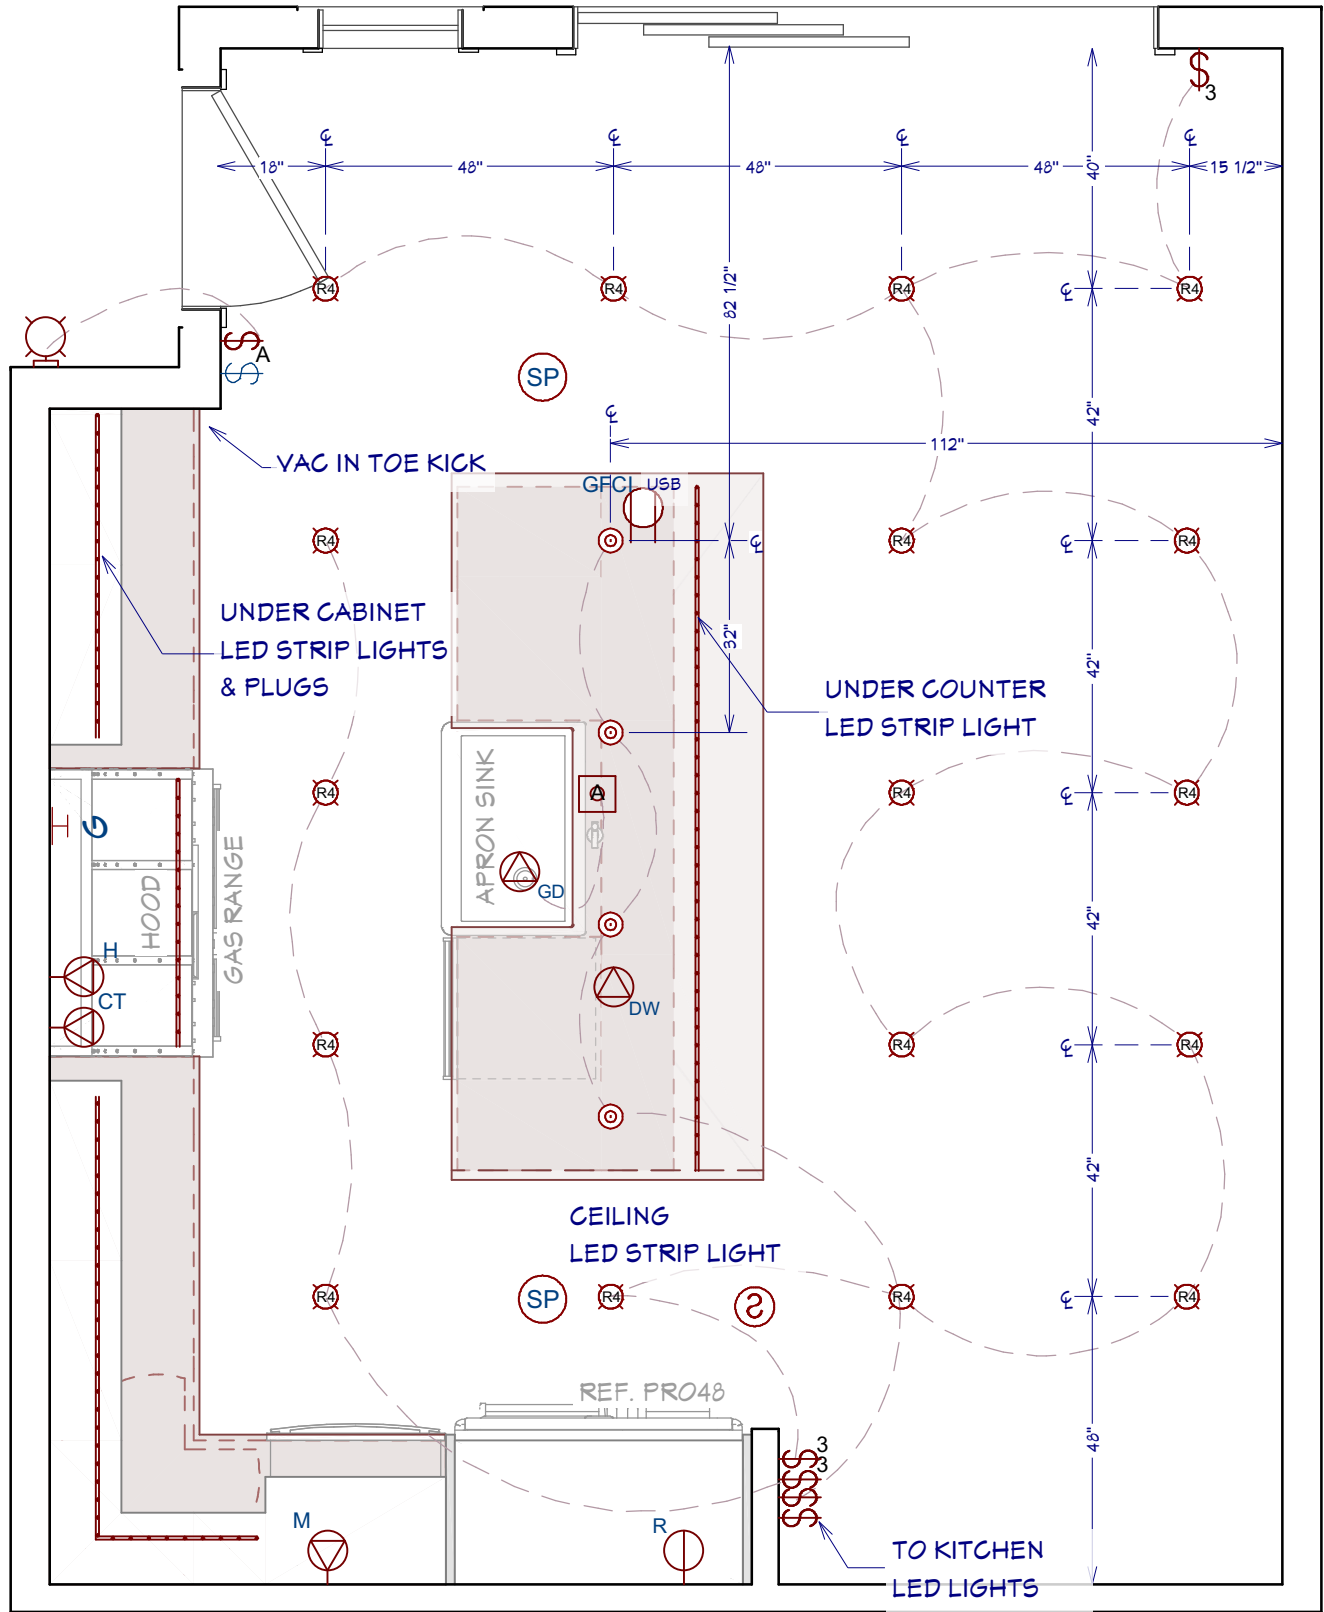

ELECTRICAL LEGEND

LIGHTING

- RECESSED 4" & 6" CANS / WET RATED
- PENDANTS / WALL LAMP / SCONCE
- UNDER CABINET LED PUCK / LED STRIP / CEILING LED
- FAN / FAN LIGHT. 200 CFM MIN.
- CEILING FAN W/ LIGHT

SWITCHES / OUTLETS

- SWITCH / 3-WAY / 4-WAY / TIMER

- OUTLETS - LED LIGHT / USB 5V & 120V / 120V WALL & CEILING GFCI / WATER PROOF / 220V
- APPLIANCE SPECIFIC: REFRIGERATOR / MICROWAVE / DISH WASHER / DISPOSAL
- COOK HOOD / WASHER / DRYER / WALL OVEN

OTHER MEP


- CAT5 / CAT5 & COAX RG6Q5 / CENTRAL VAC / HOME SECURITY PANEL
- SMOKE DETECTOR / THERMOSTAT / GAS CONNECTION / DOOR BELL
- WALL CONTROLLED VOLUME SWITCH / IN-WALL OR CEILING MOUNTED SPEAKERS

ELECTRICAL PLAN

KBI SAMPLE PLAN

Chief Architect
6500 N. Mineral Dr. Coeur d'Alene, Idaho
208.292.3400
chiefarchitect.com



SHEET NUMBER
5
REVISION #:
DATE:

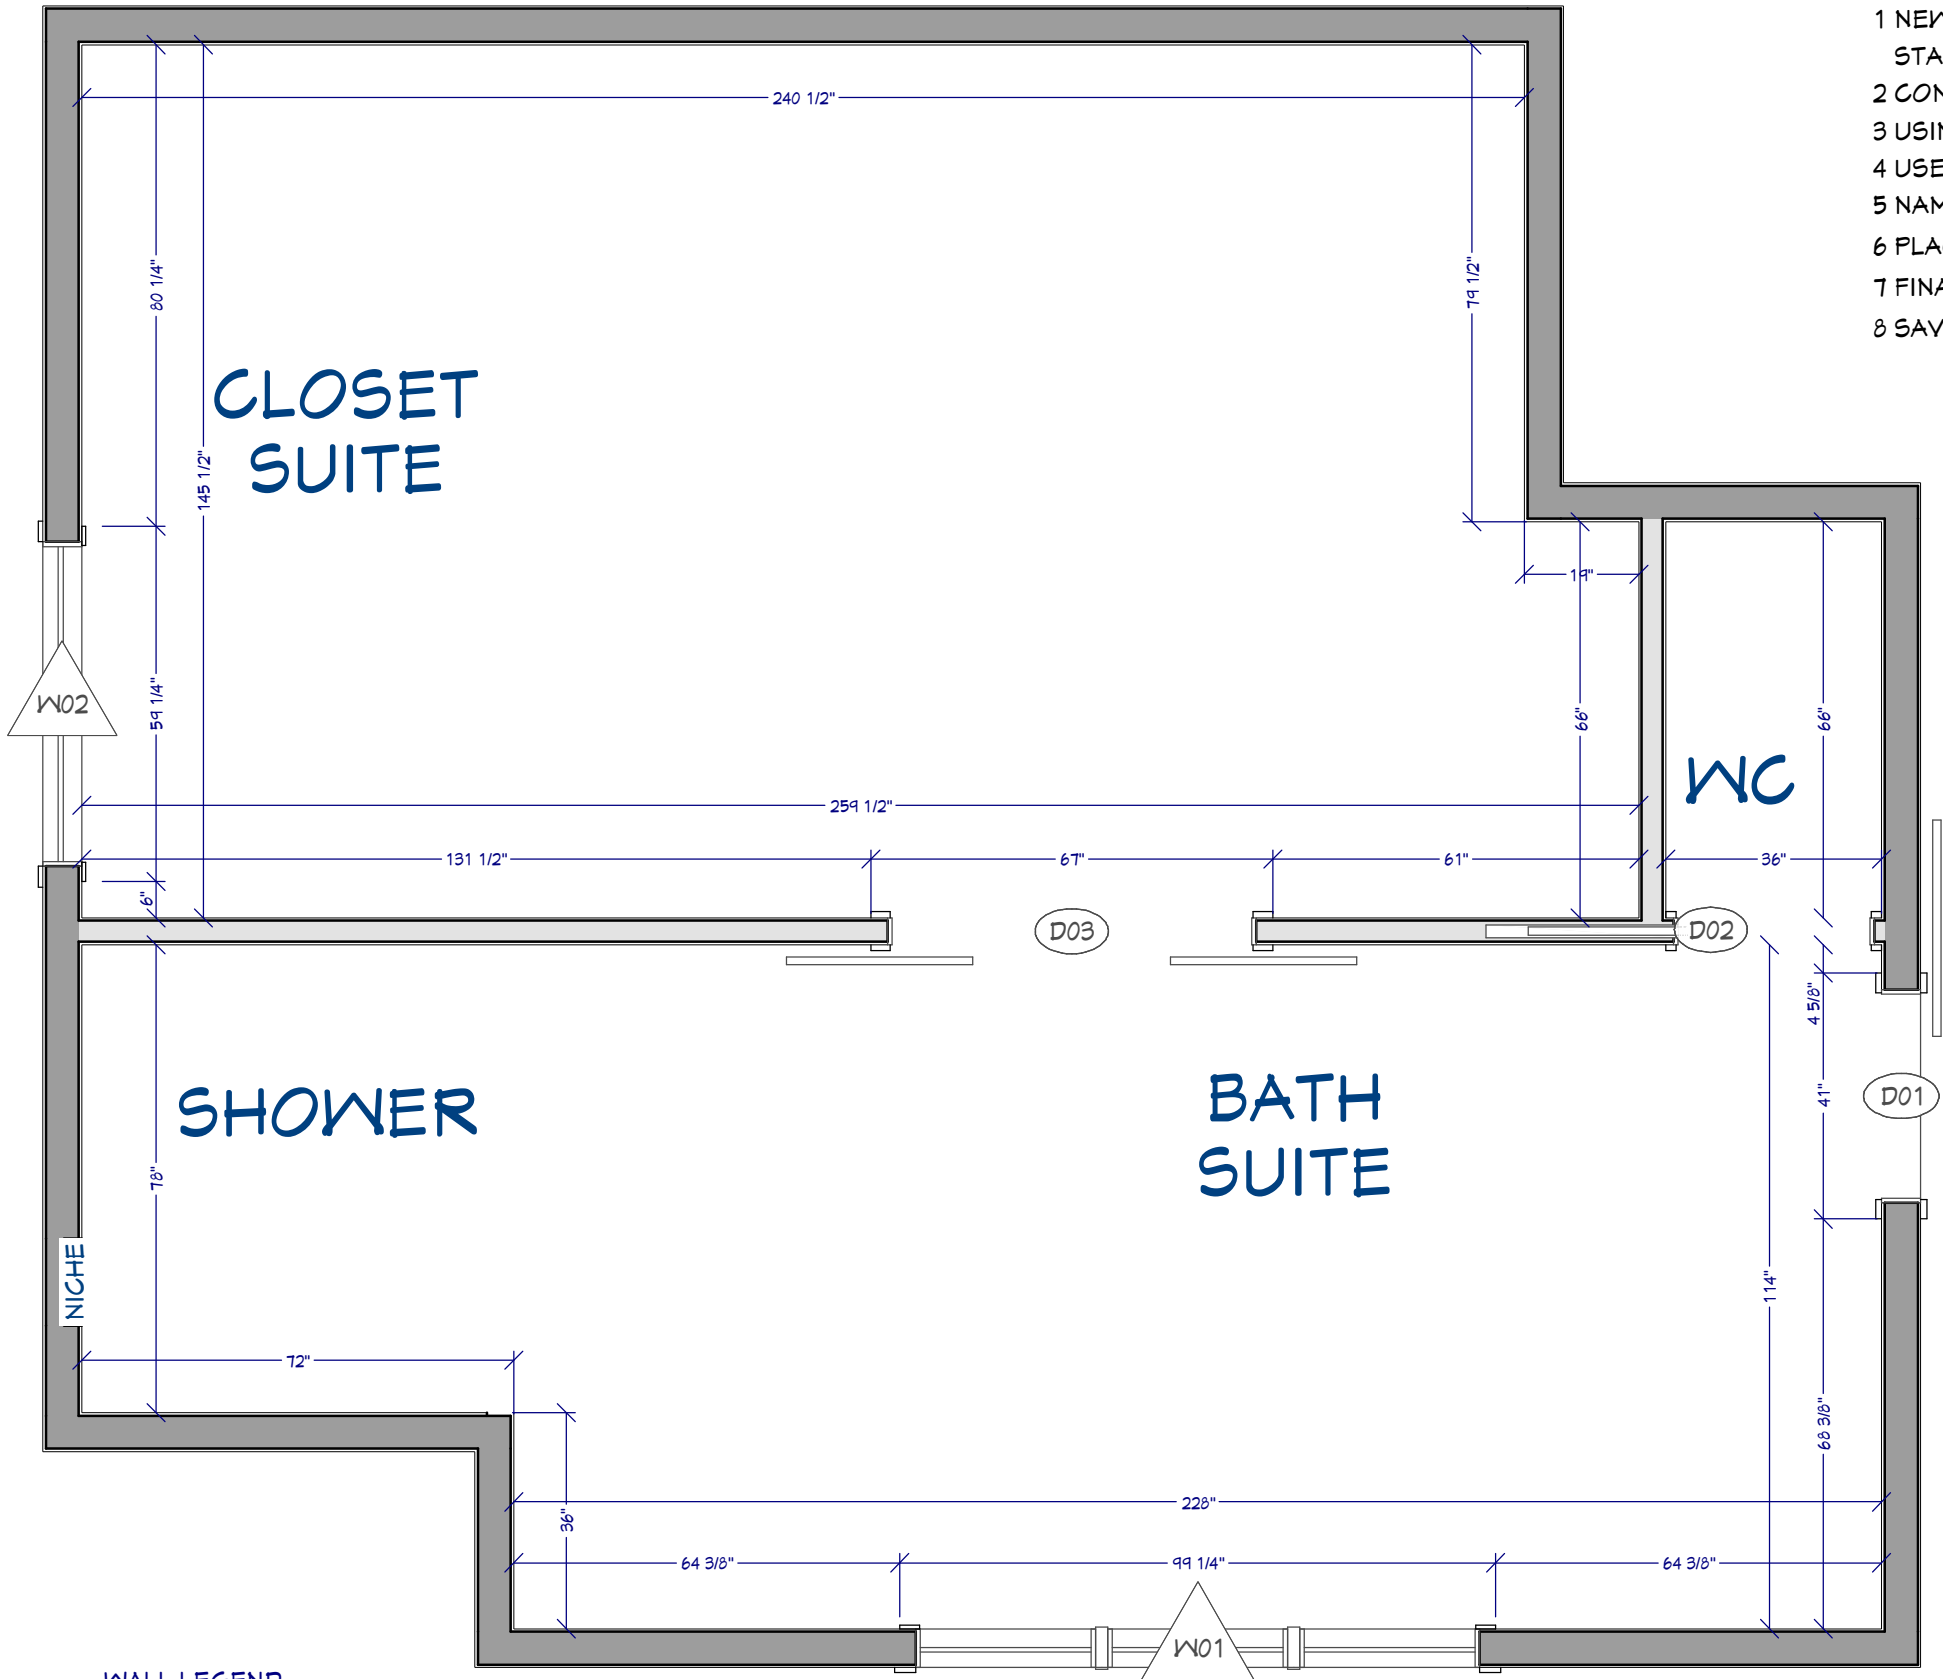

- STEPS:**
- 1 NEW PLAN FROM K&B TEMPLATE (CREATED IN KITCHEN CLASS) PLAN;
START IN THE CONSTRUCTION PLAN VIEW
 - 2 CONFIRM FINISHED CEILING HEIGHT IS 10' OR 11'9 5/8"
 - 3 USING THE INTERIOR WALL TOOLS, DRAW THE PLAN SHAPE
 - 4 USE AUTO INTERIOR DIMENSIONS FOR THE PLAN, CLEANUP
 - 5 NAME THE ROOMS
 - 6 PLACE DOORS & WINDOWS
 - 7 FINALIZE DIMENSIONS
 - 8 SAVE THE PLAN

DOOR SCHEDULE				
3D EXTERIOR ELEVATION	NUMBER	WIDTH	HEIGHT	DESCRIPTION
	D01	34"	96"	BARN-DOOR P03
	D02	32"	96"	POCKET-DOOR P03
	D03	60"	96"	DOUBLE BARN-GLASS PANEL


WINDOW SCHEDULE				
3D EXTERIOR ELEVATION	NUMBER	WIDTH	HEIGHT	DESCRIPTION
	W01	94"	30"	MULLED WINDOW
	W02	54"	72"	SINGLE CASEMENT-HR

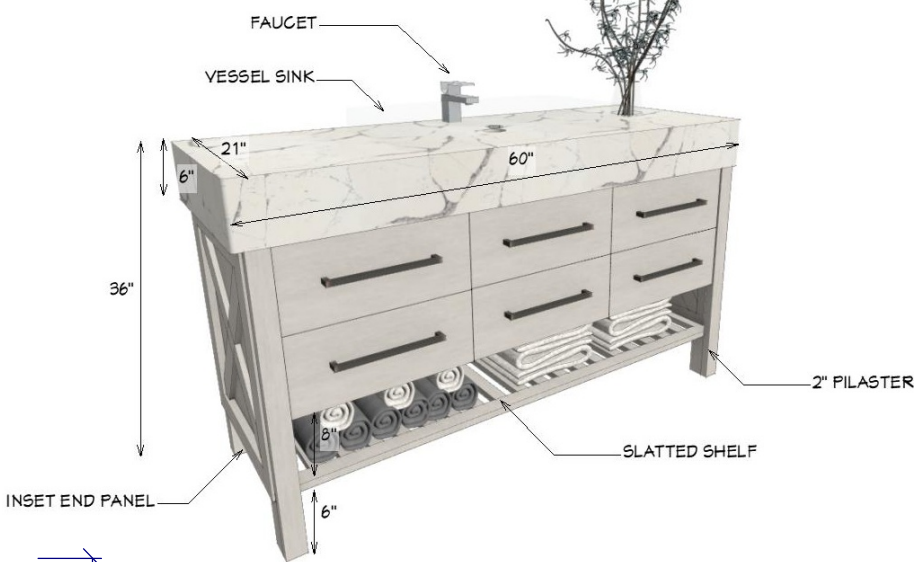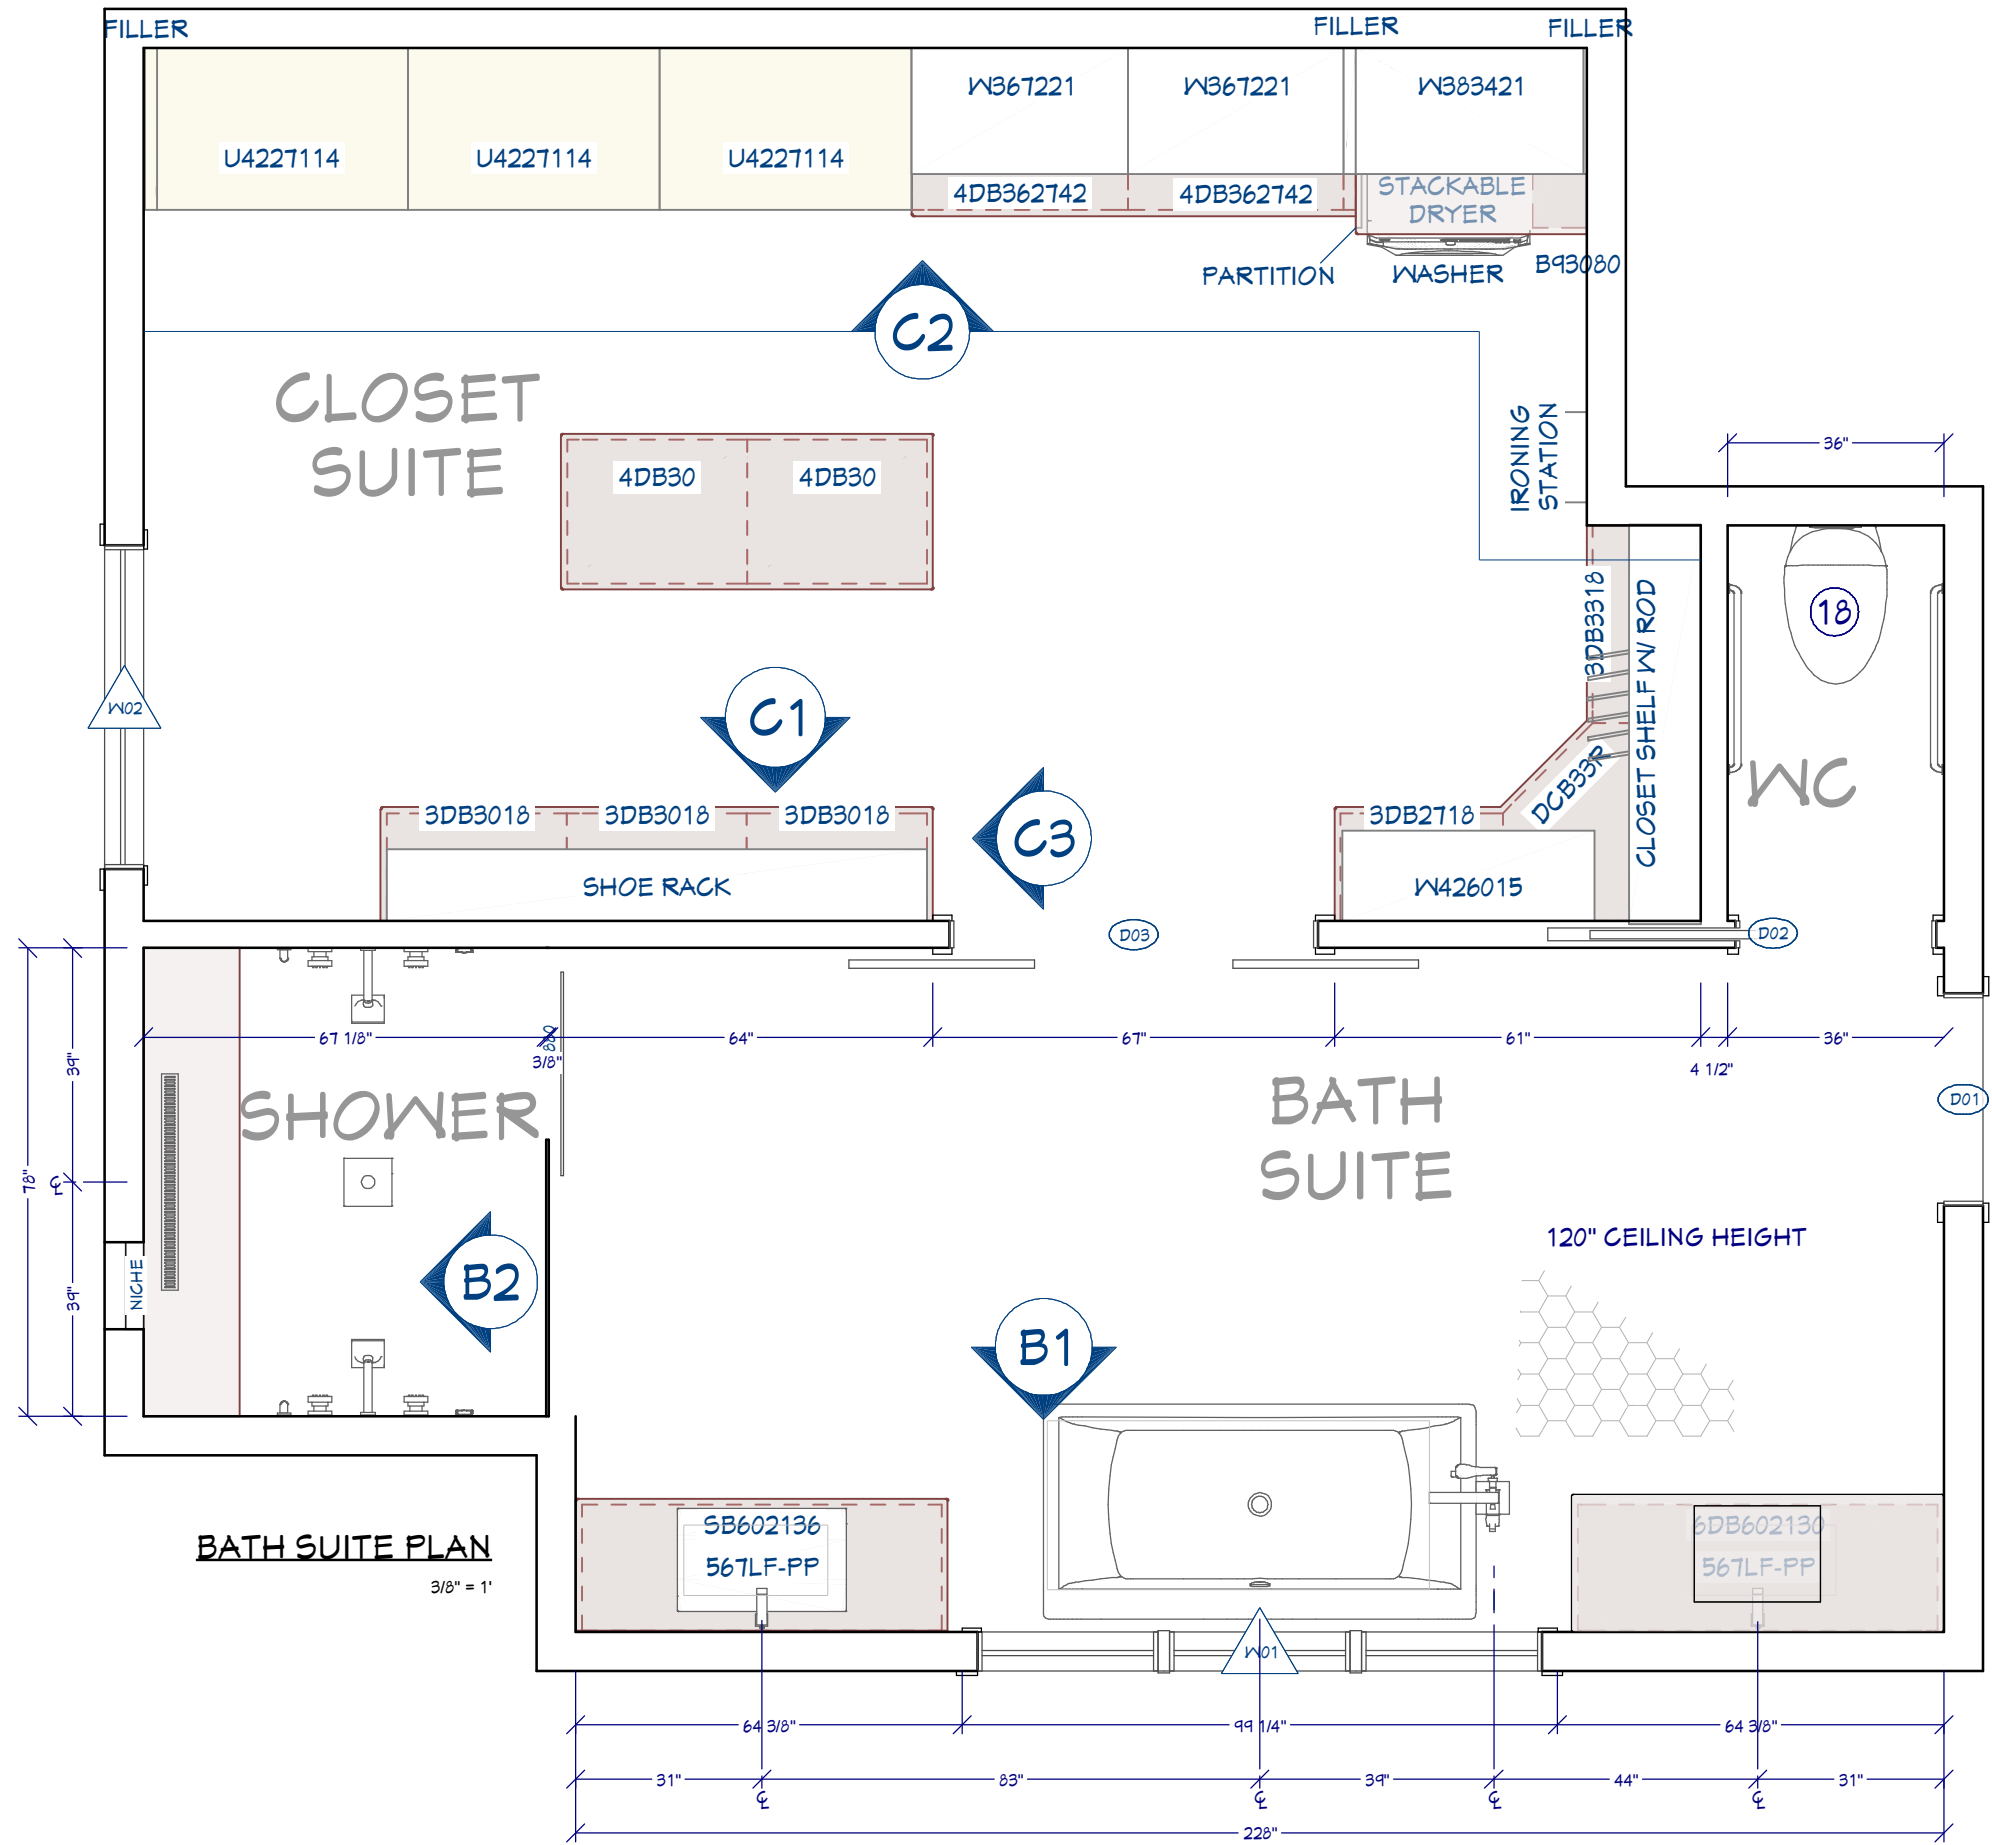


CUSTOM VANITY

BATH SUITE NOTES


- ① LED MIRROR
- ② FREE STANDING TUB
- ③ TUB FILLER
- ④ CUSTOM VANITY
- ⑤ GLASS VESSEL SINK
- ⑥ SHIPLAP PANEL
- ⑦ TILE MOLDING BAND INTO SHOWER
- ⑧ SHOWER TILE - OWNER TO FINALIZE
- ⑨ SHOWER HEAD
- ⑩ SHOWER DTV CONTROL
- ⑪ BODY SPRAY
- ⑫ GRAB BAR MIN. 250 LBS.
- ⑬ FLOATING BENCH
- ⑭ STRIP DRAIN
- ⑮ RAIN HEAD
- ⑯ RECTANGULAR NICHE
- ⑰ WALL HUNG TOILET
- ⑱ SHOWER BARN DOOR

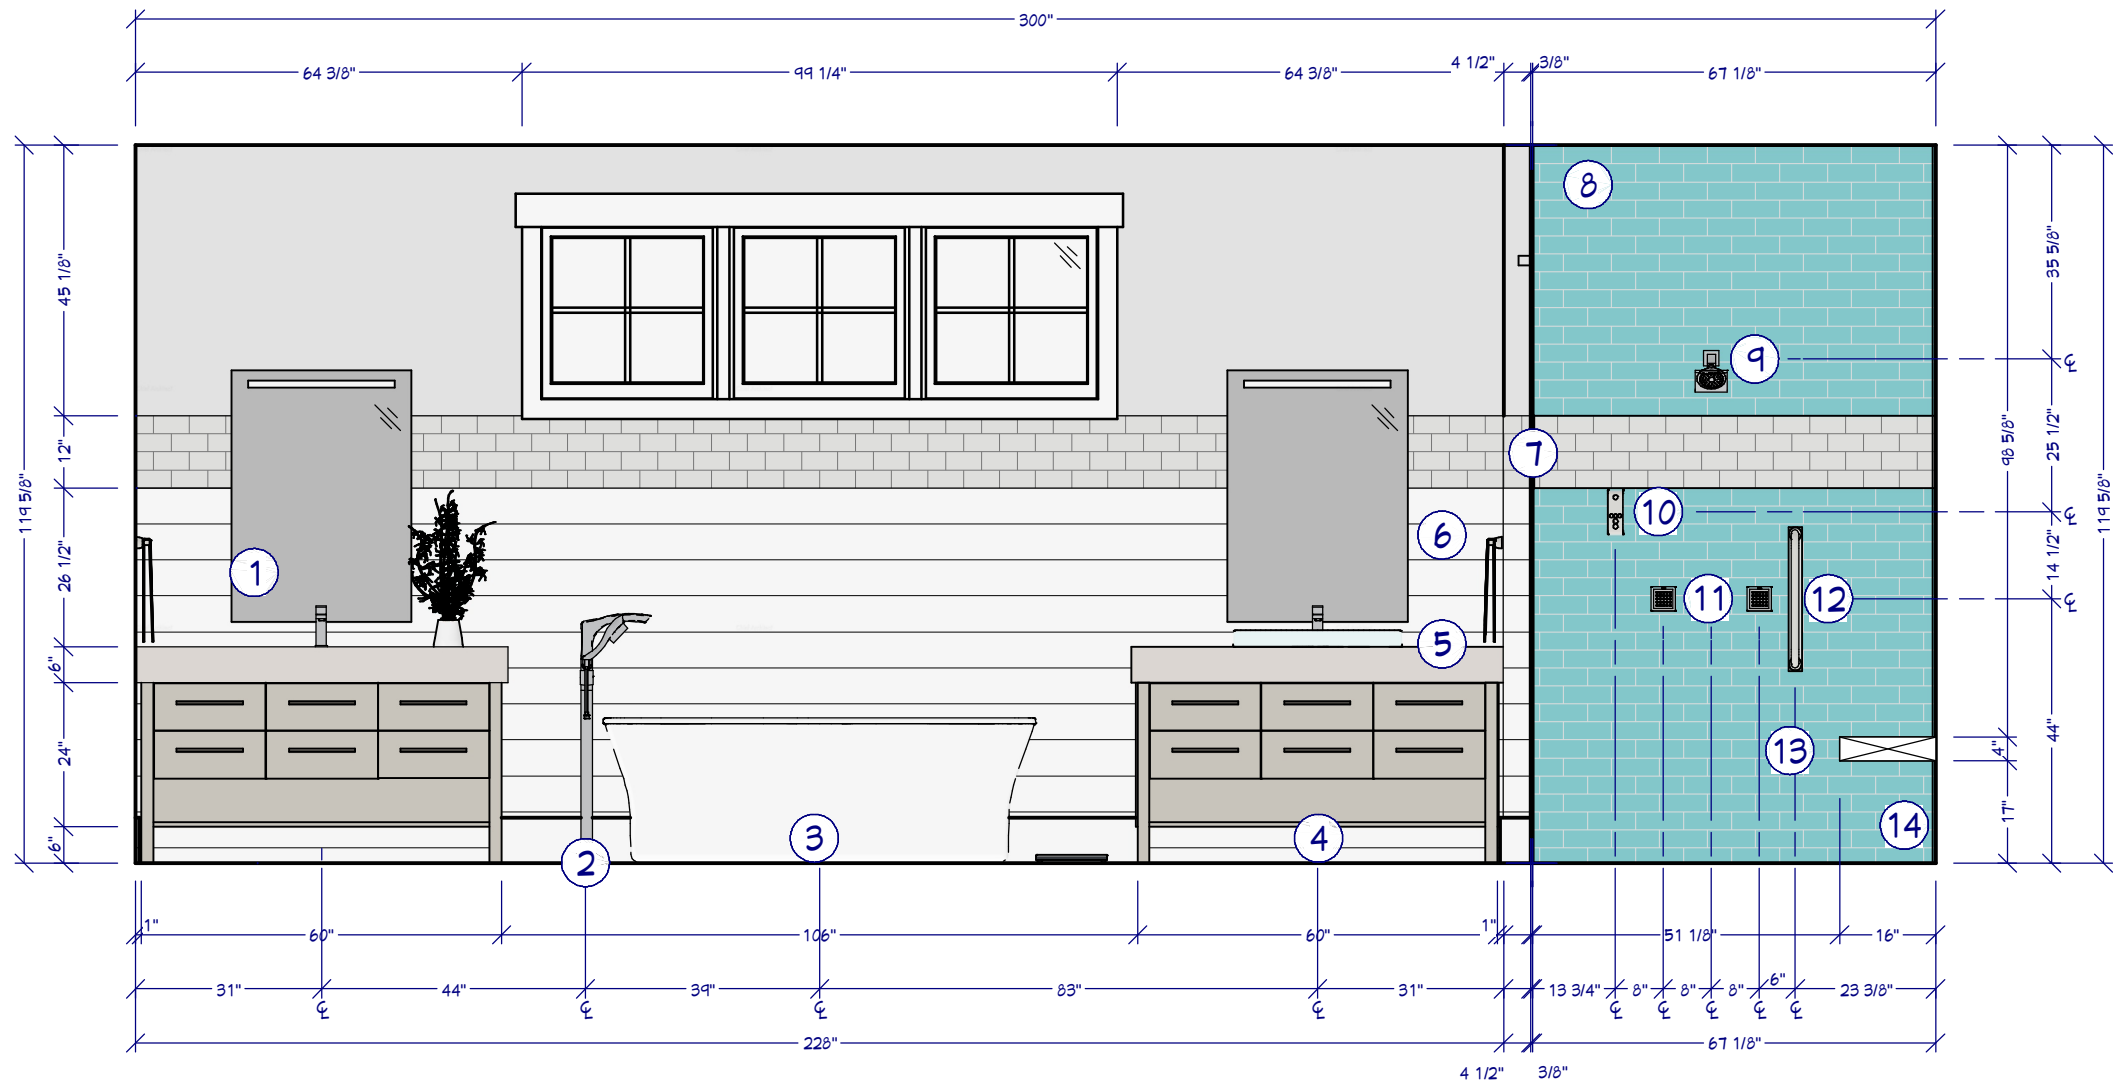

B1 BATH SUITE MAIN WALL
3/8" = 1"

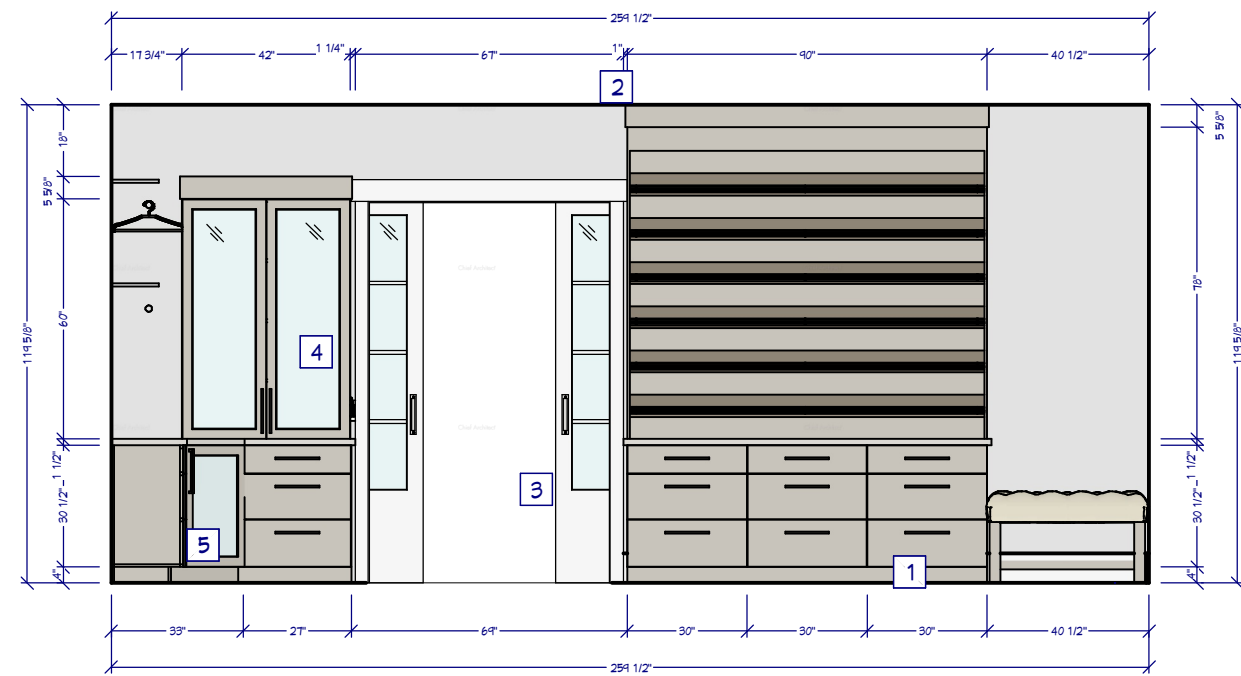

C1 CLOSET ELEVATION
1/4" = 1"

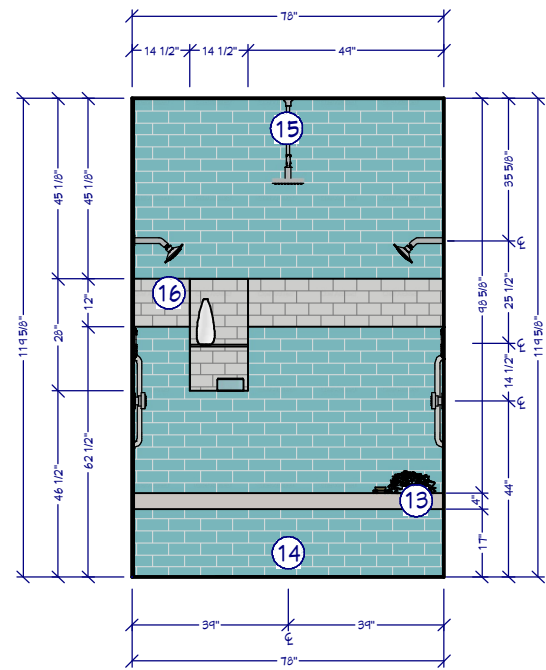

B2 SHOWER ELEVATION
1/4" = 1"