

CONSTRUCTION LEGEND

-  OPENING CLOSED
-  WALL ADDED
-  WALL EXISTING
-  WALL REMOVED
-  WALL BLOCKING - GRAB BARS

CONSTRUCTION PLAN
1/2" = 1'



DRAWINGS PROVIDED BY:
Designer Information
© 2016 CHIEF ARCHITECT SOFTWARE

CLIENT INFORMATION:
**MARIANO
RESIDENCE**


PROJECT DESCRIPTION:
NKBA Exam Sample

SHEET TITLE:
CONSTRUCTION PLAN DRAWING







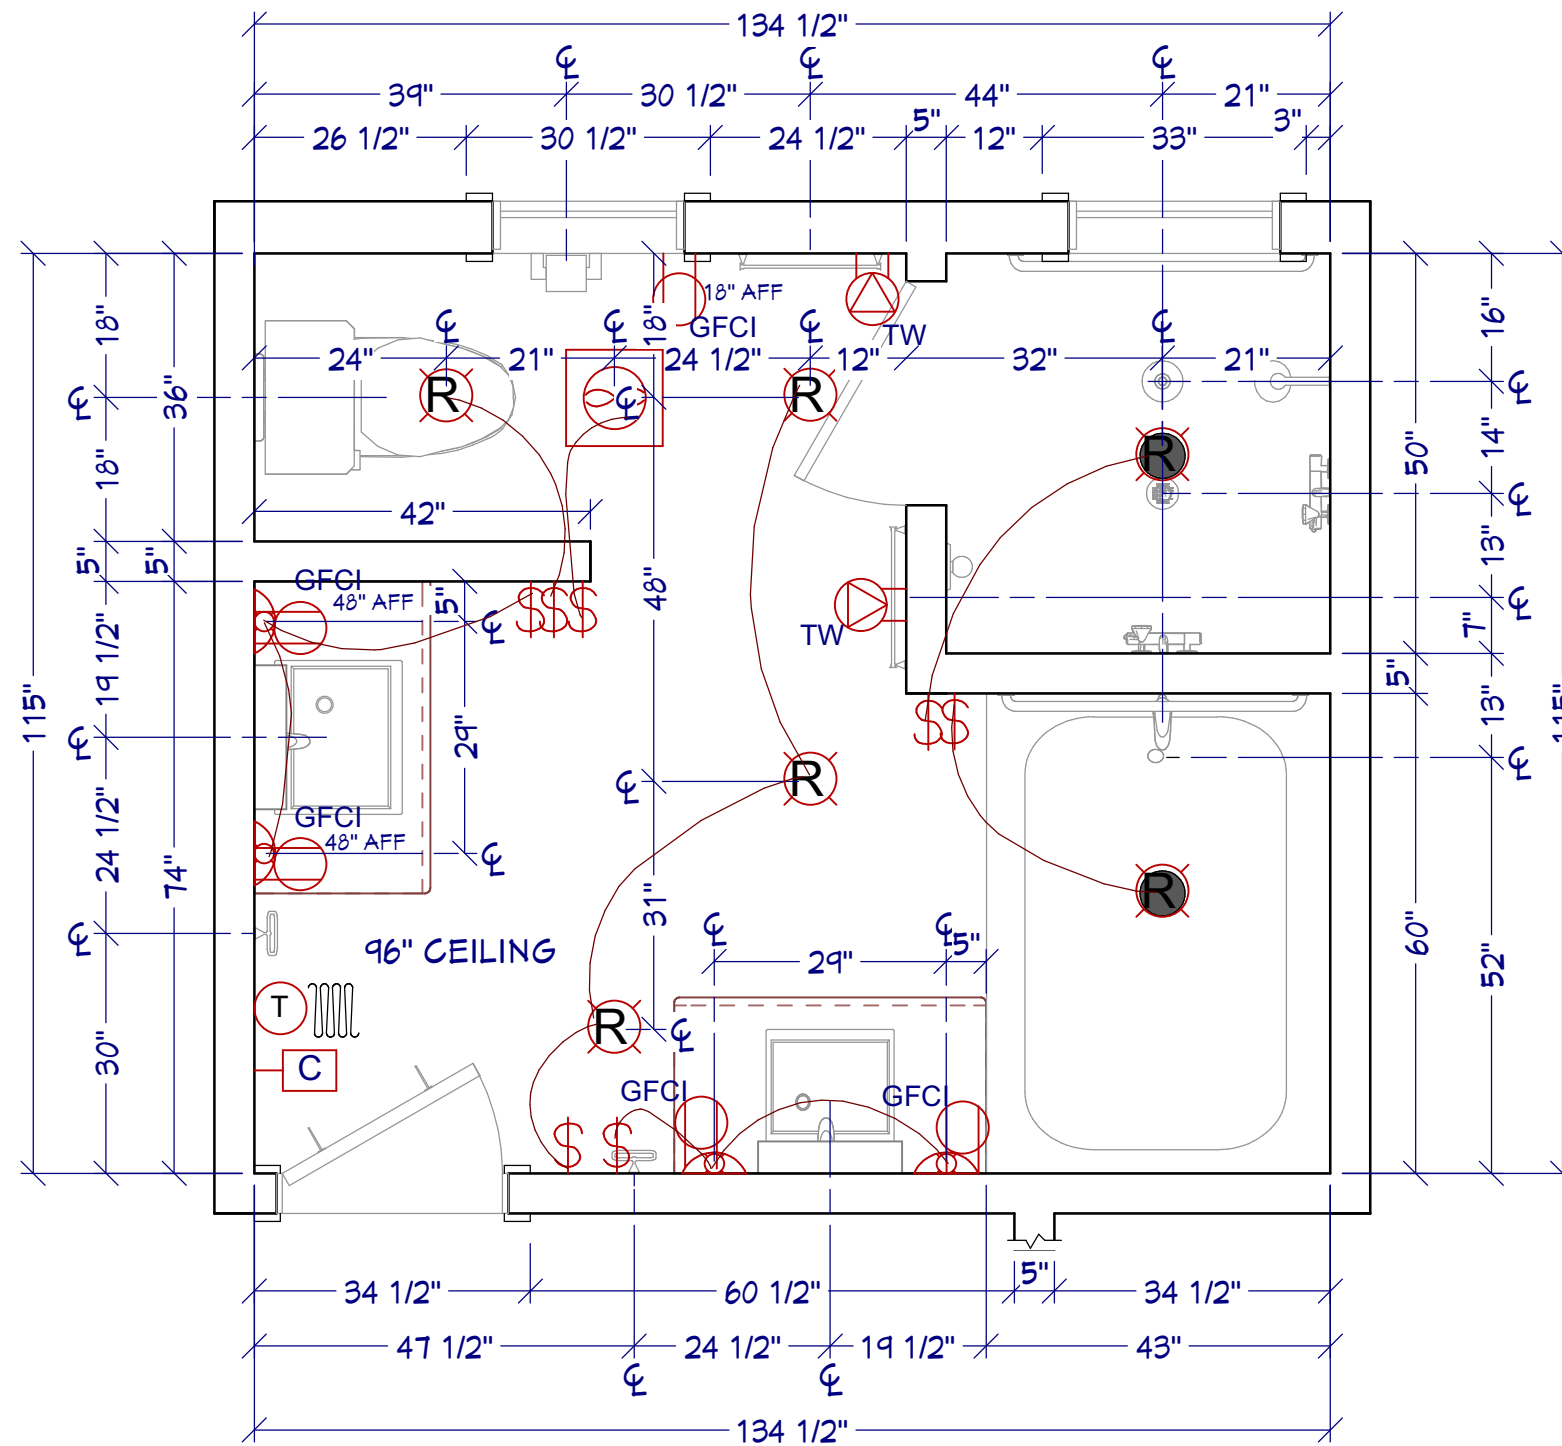



SCALE:
1/2" = 1'

DATE:

SHEET #
1



MECHANICAL LEGEND

-  GFCI SWITCH
 -  GFCI OUTLET
 -  RECESSED LIGHT
 -  WET RATED RECESS LIGHT
 -  WALL LIGHT
 -  FAN 200 CFM
 -  TOWEL WARMER, MFG ABC, 120V
 -  HEATED FLOOR, MFG ABC, 120V
 -  SWITCH THERMO HEATED FLOOR
 -  CABLE TV
- ALL OUTLETS / SWITCHES 42" AFF UNO

MECHANICAL PLAN

1/2" = 1'



DRAWINGS PROVIDED BY:
Designer Information

© 2016 CHIEF ARCHITECT SOFTWARE

CLIENT INFORMATION:

**MARIANO
RESIDENCE**

PROJECT DESCRIPTION:

NKBA Exam Sample

SHEET TITLE:

MECHANICAL PLAN DRAWING


SCALE:

1/2" = 1'

DATE:

SHEET #

2

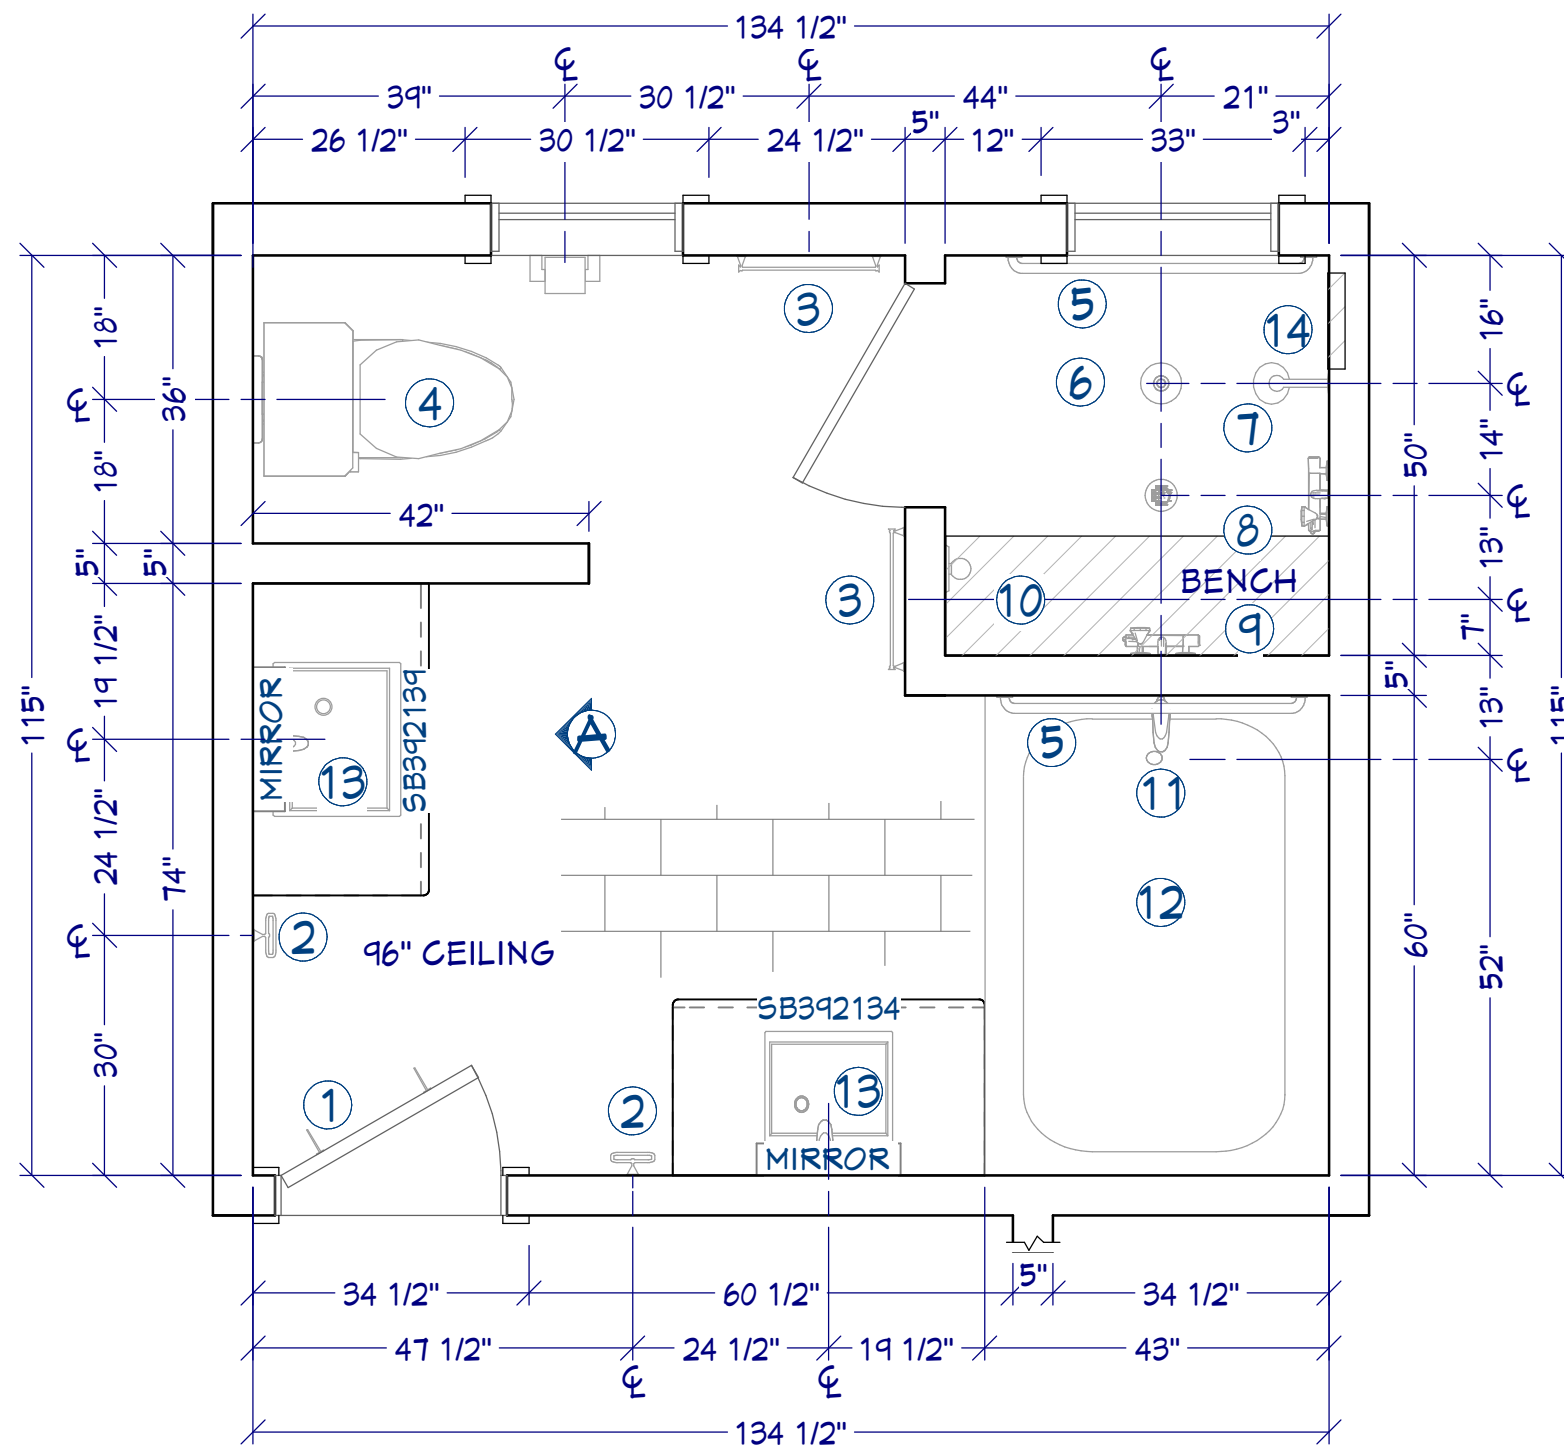

FLOOR PLAN SPECIFICATIONS

1. ROBE HOOKS, MFG ABC, M 123
2. TOWEL RING, MFG ABC, M 123
3. HEAT TOWEL BAR, MFG ABC, M 123
4. TOILET, MFG ABC, M 123
5. GRAB BAR, MFG ABC, M 123 250LBS
6. OVERHEAD HEAD, MFG ABC, M 123
7. HANDHELD, MFG ABC, M 123
8. BODY SPRAY, MFG ABC, M 123
9. SS BENCH 17" AFF
10. FAUCET FOR OVERHEAD, MFG ABC, M 123
11. FAUCET WHIRLPOOL TUB, MFG ABC, M 123
12. WHIRL POOL TUB, MFG ABC, M 123
13. UNDERMOUNT SINK, , MFG ABC, M 123
14. REC. SOAP DISH

FLOOR PLAN

1/2" = 1'



DRAWINGS PROVIDED BY:
Designer Information

© 2016 CHIEF ARCHITECT SOFTWARE

CLIENT INFORMATION:

**MARIANO
RESIDENCE**

PROJECT DESCRIPTION:

NKBA Exam Sample

SHEET TITLE:

FLOOR PLAN DRAWING


SCALE:

1/2" = 1'

DATE:

SHEET #

3

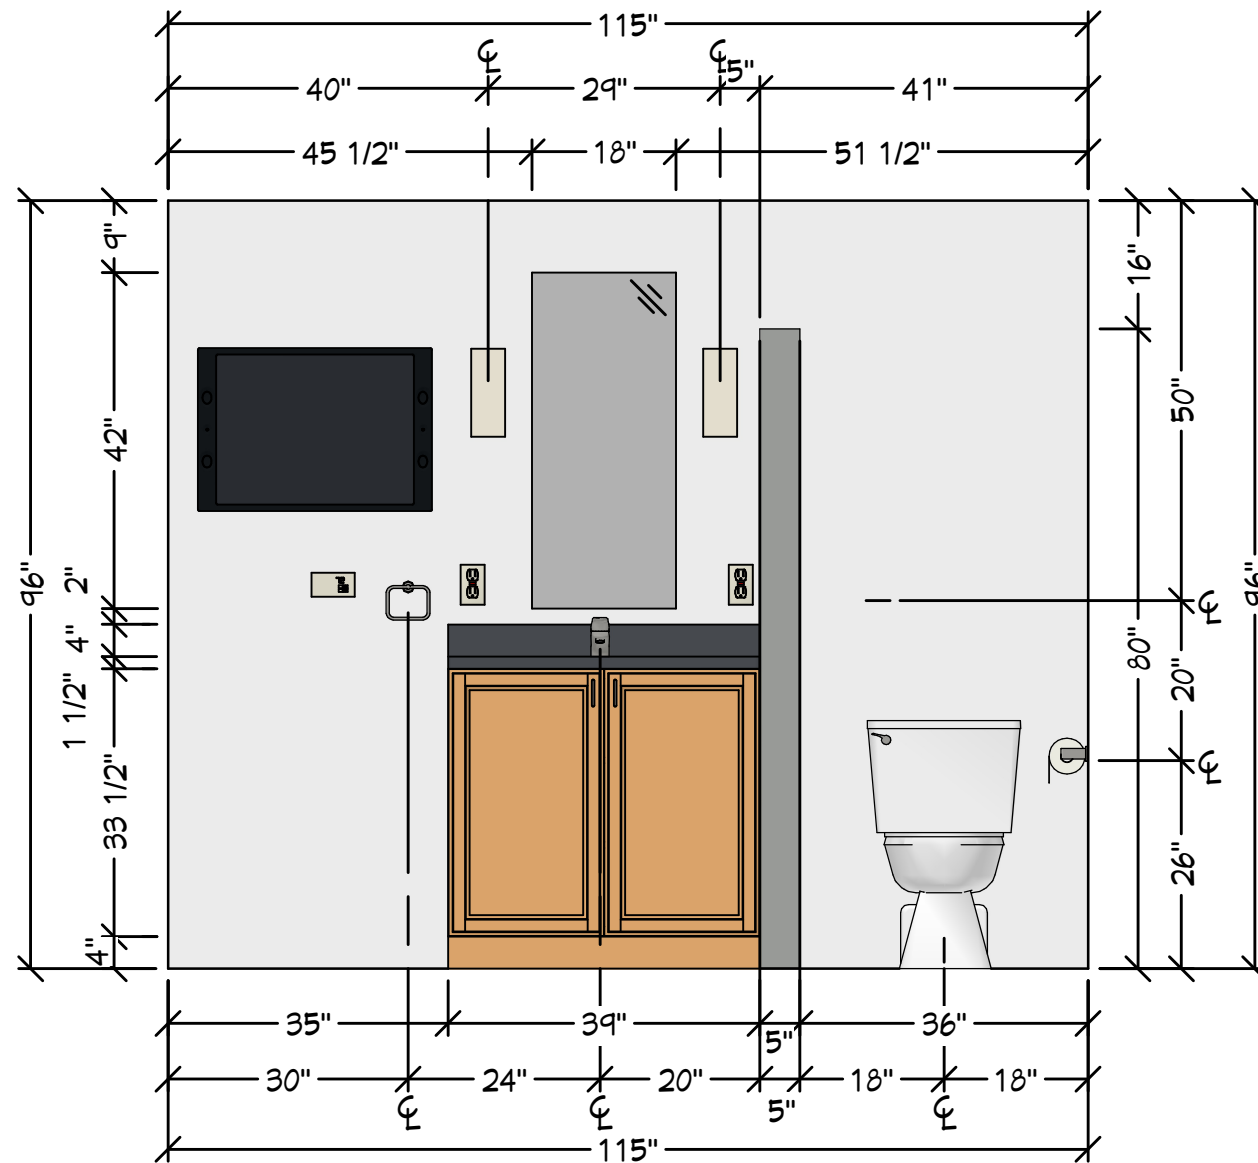

A MAIN WALL ELEVATION
1/2" = 1'



DRAWINGS PROVIDED BY:
Designer Information

© 2016 CHIEF ARCHITECT SOFTWARE

CLIENT INFORMATION:

**MARIANO
RESIDENCE**

PROJECT DESCRIPTION:

NKBA Exam Sample

SHEET TITLE:

WALL ELEVATION DRAWING

SCALE:

1/2" = 1'

DATE:

SHEET #

4