




NKBA STUDY GUIDE: LARGE BATHROOM

design by:


Robin Rigby Fischer, CMKBD, CAPS - Robin Rigby Fischer Design

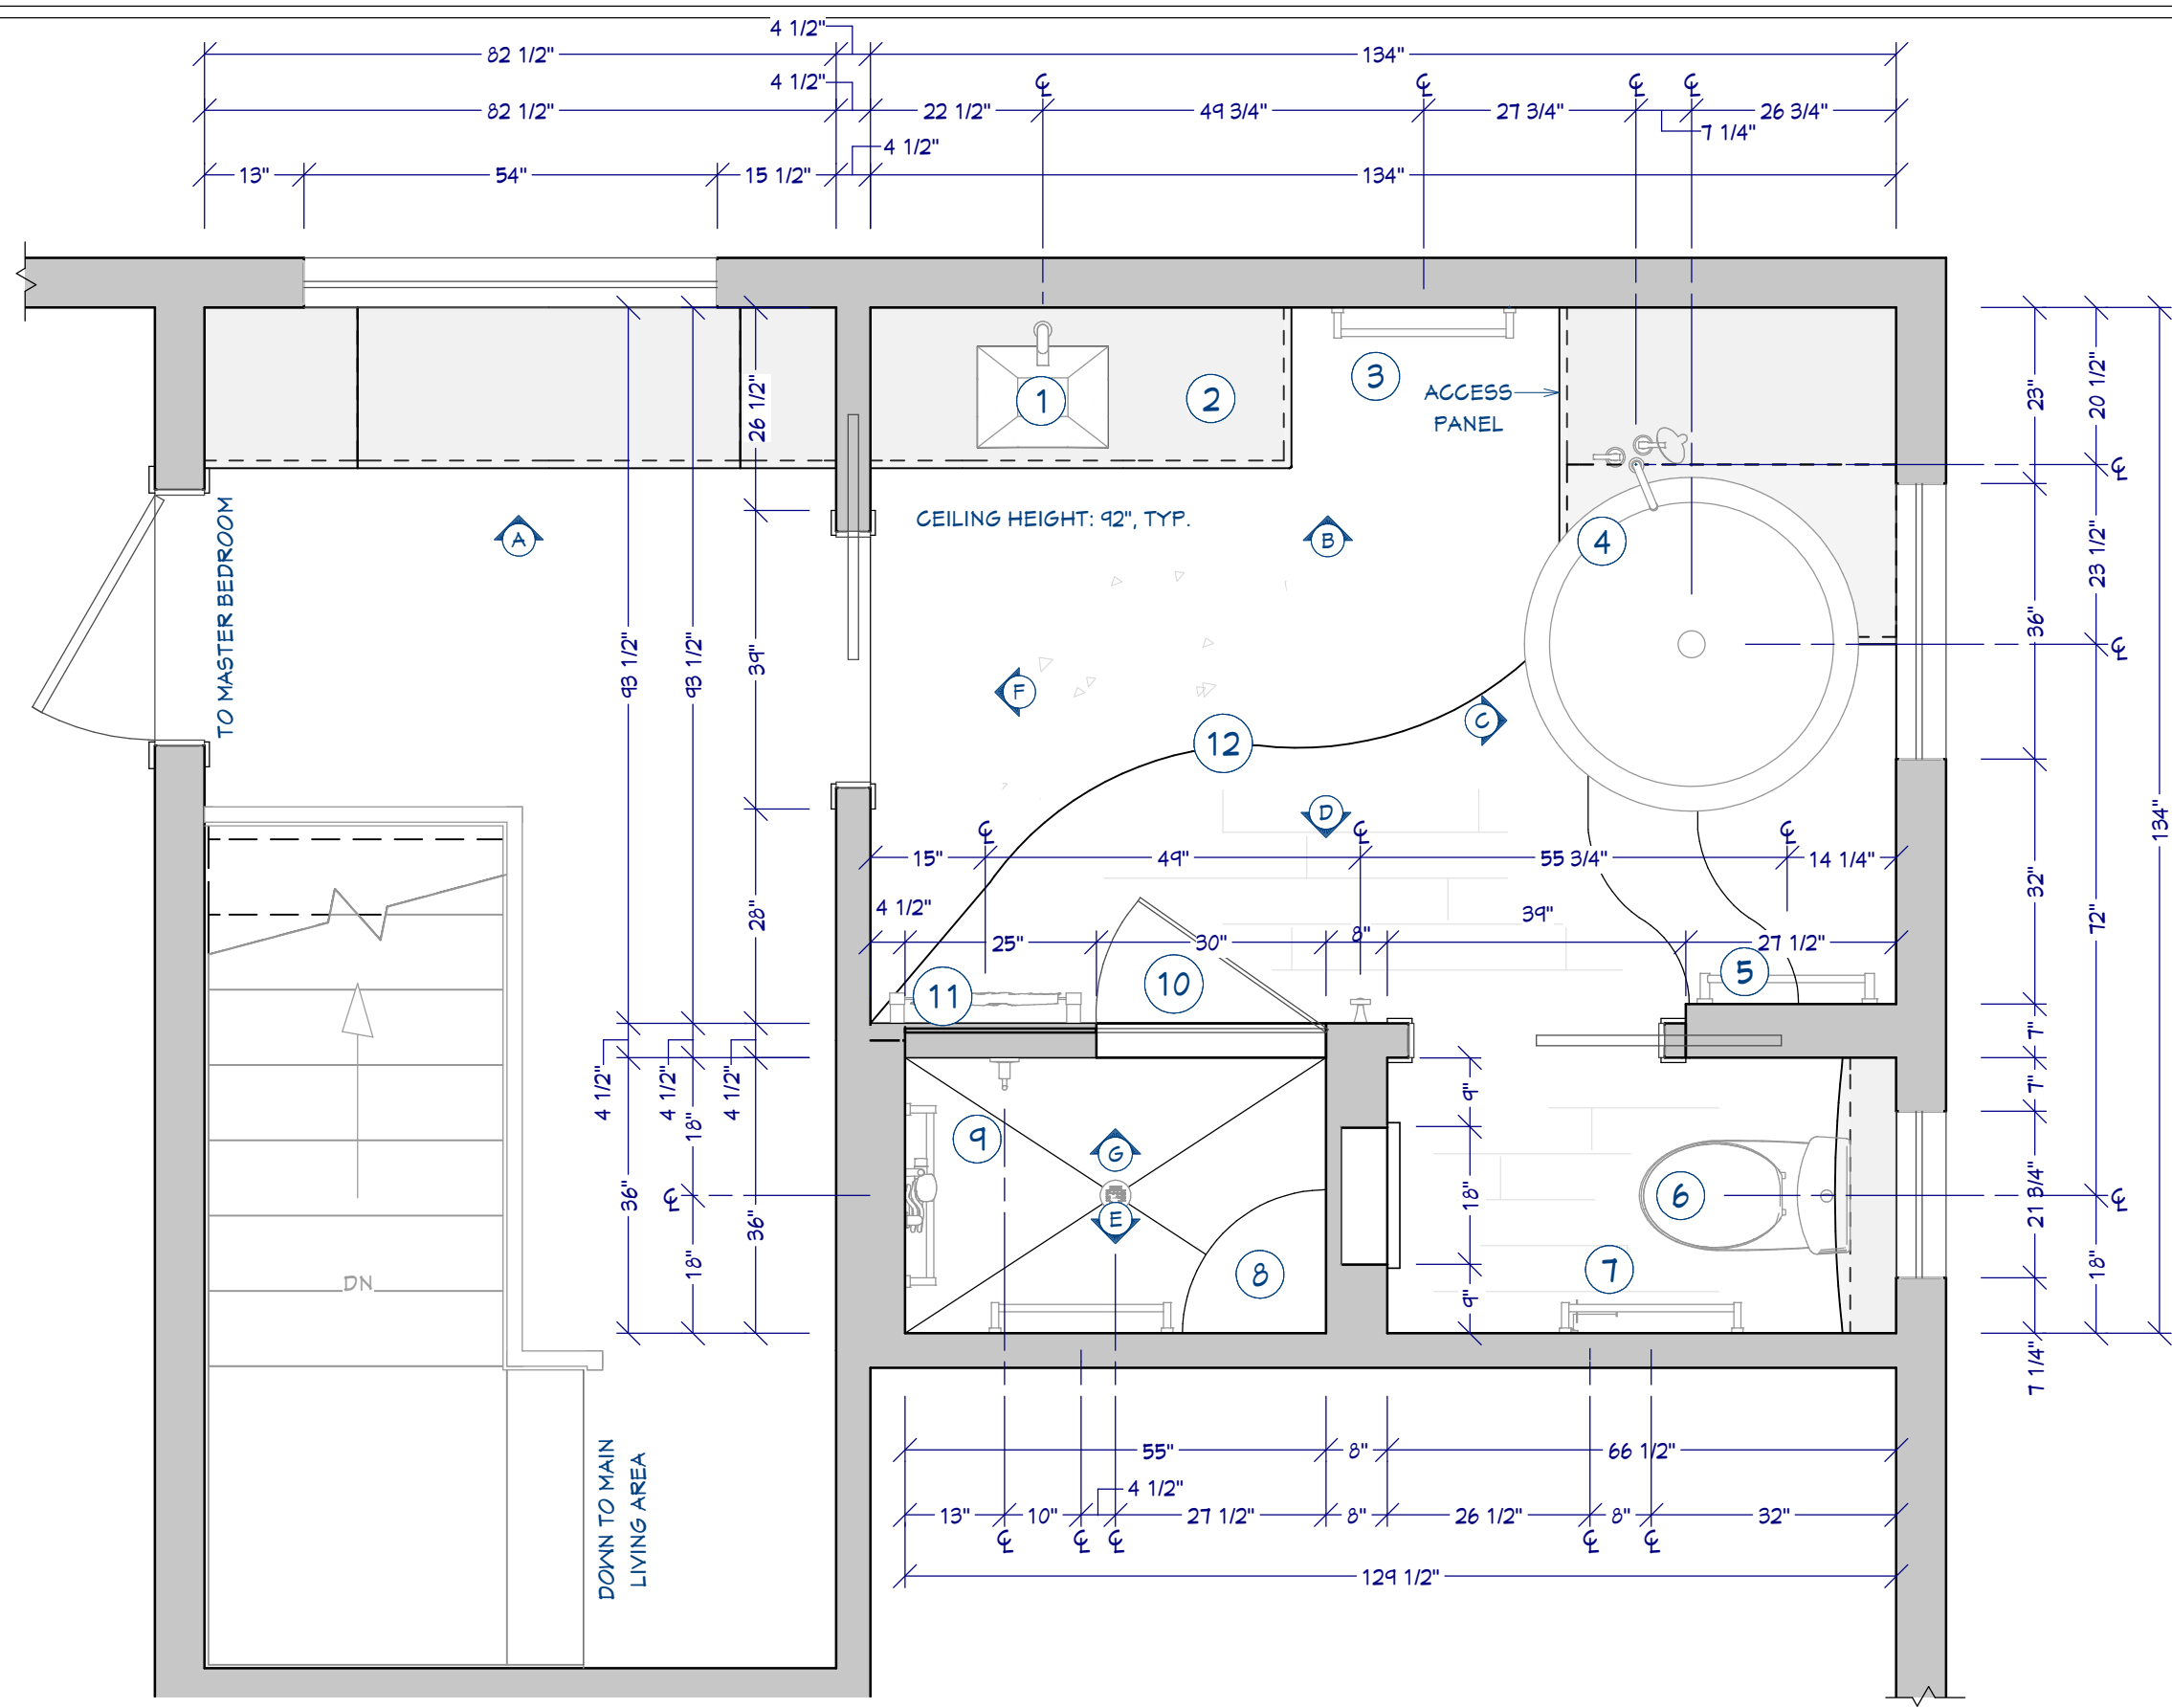

FLOOR PLAN SPECIFICATION:


- ① SINK BRAND ABC; MDL. 123;
FAUCET BRAND ABC; MDL. 234
- ② CUSTOM VANITY CABINET
- ③ TOWEL BAR BRAND XYZ; MDL. 123
- ④ SOAKING TUB BRAND ABC; MDL. 234
- ⑤ GRAB BAR, TYP., BRAND ABC; MDL. 345
- ⑥ TOILET BRAND ABC; MDL. 123
- ⑦ TISSUE HOLDER BRAND ABC; MDL. 234
- ⑧ SHOWER BENCH
- ⑨ SHOWER FINISHES BRAND ABC; MDL. 123
- ⑩ TEMPERED GLASS SHOWER DOOR & PARTITION
- ⑪ TOWEL WARMER BRAND ABC; MDL. 345
- ⑫ SLIP RESISTANT FLOORING

FLOOR PLAN
1/2" = 1'

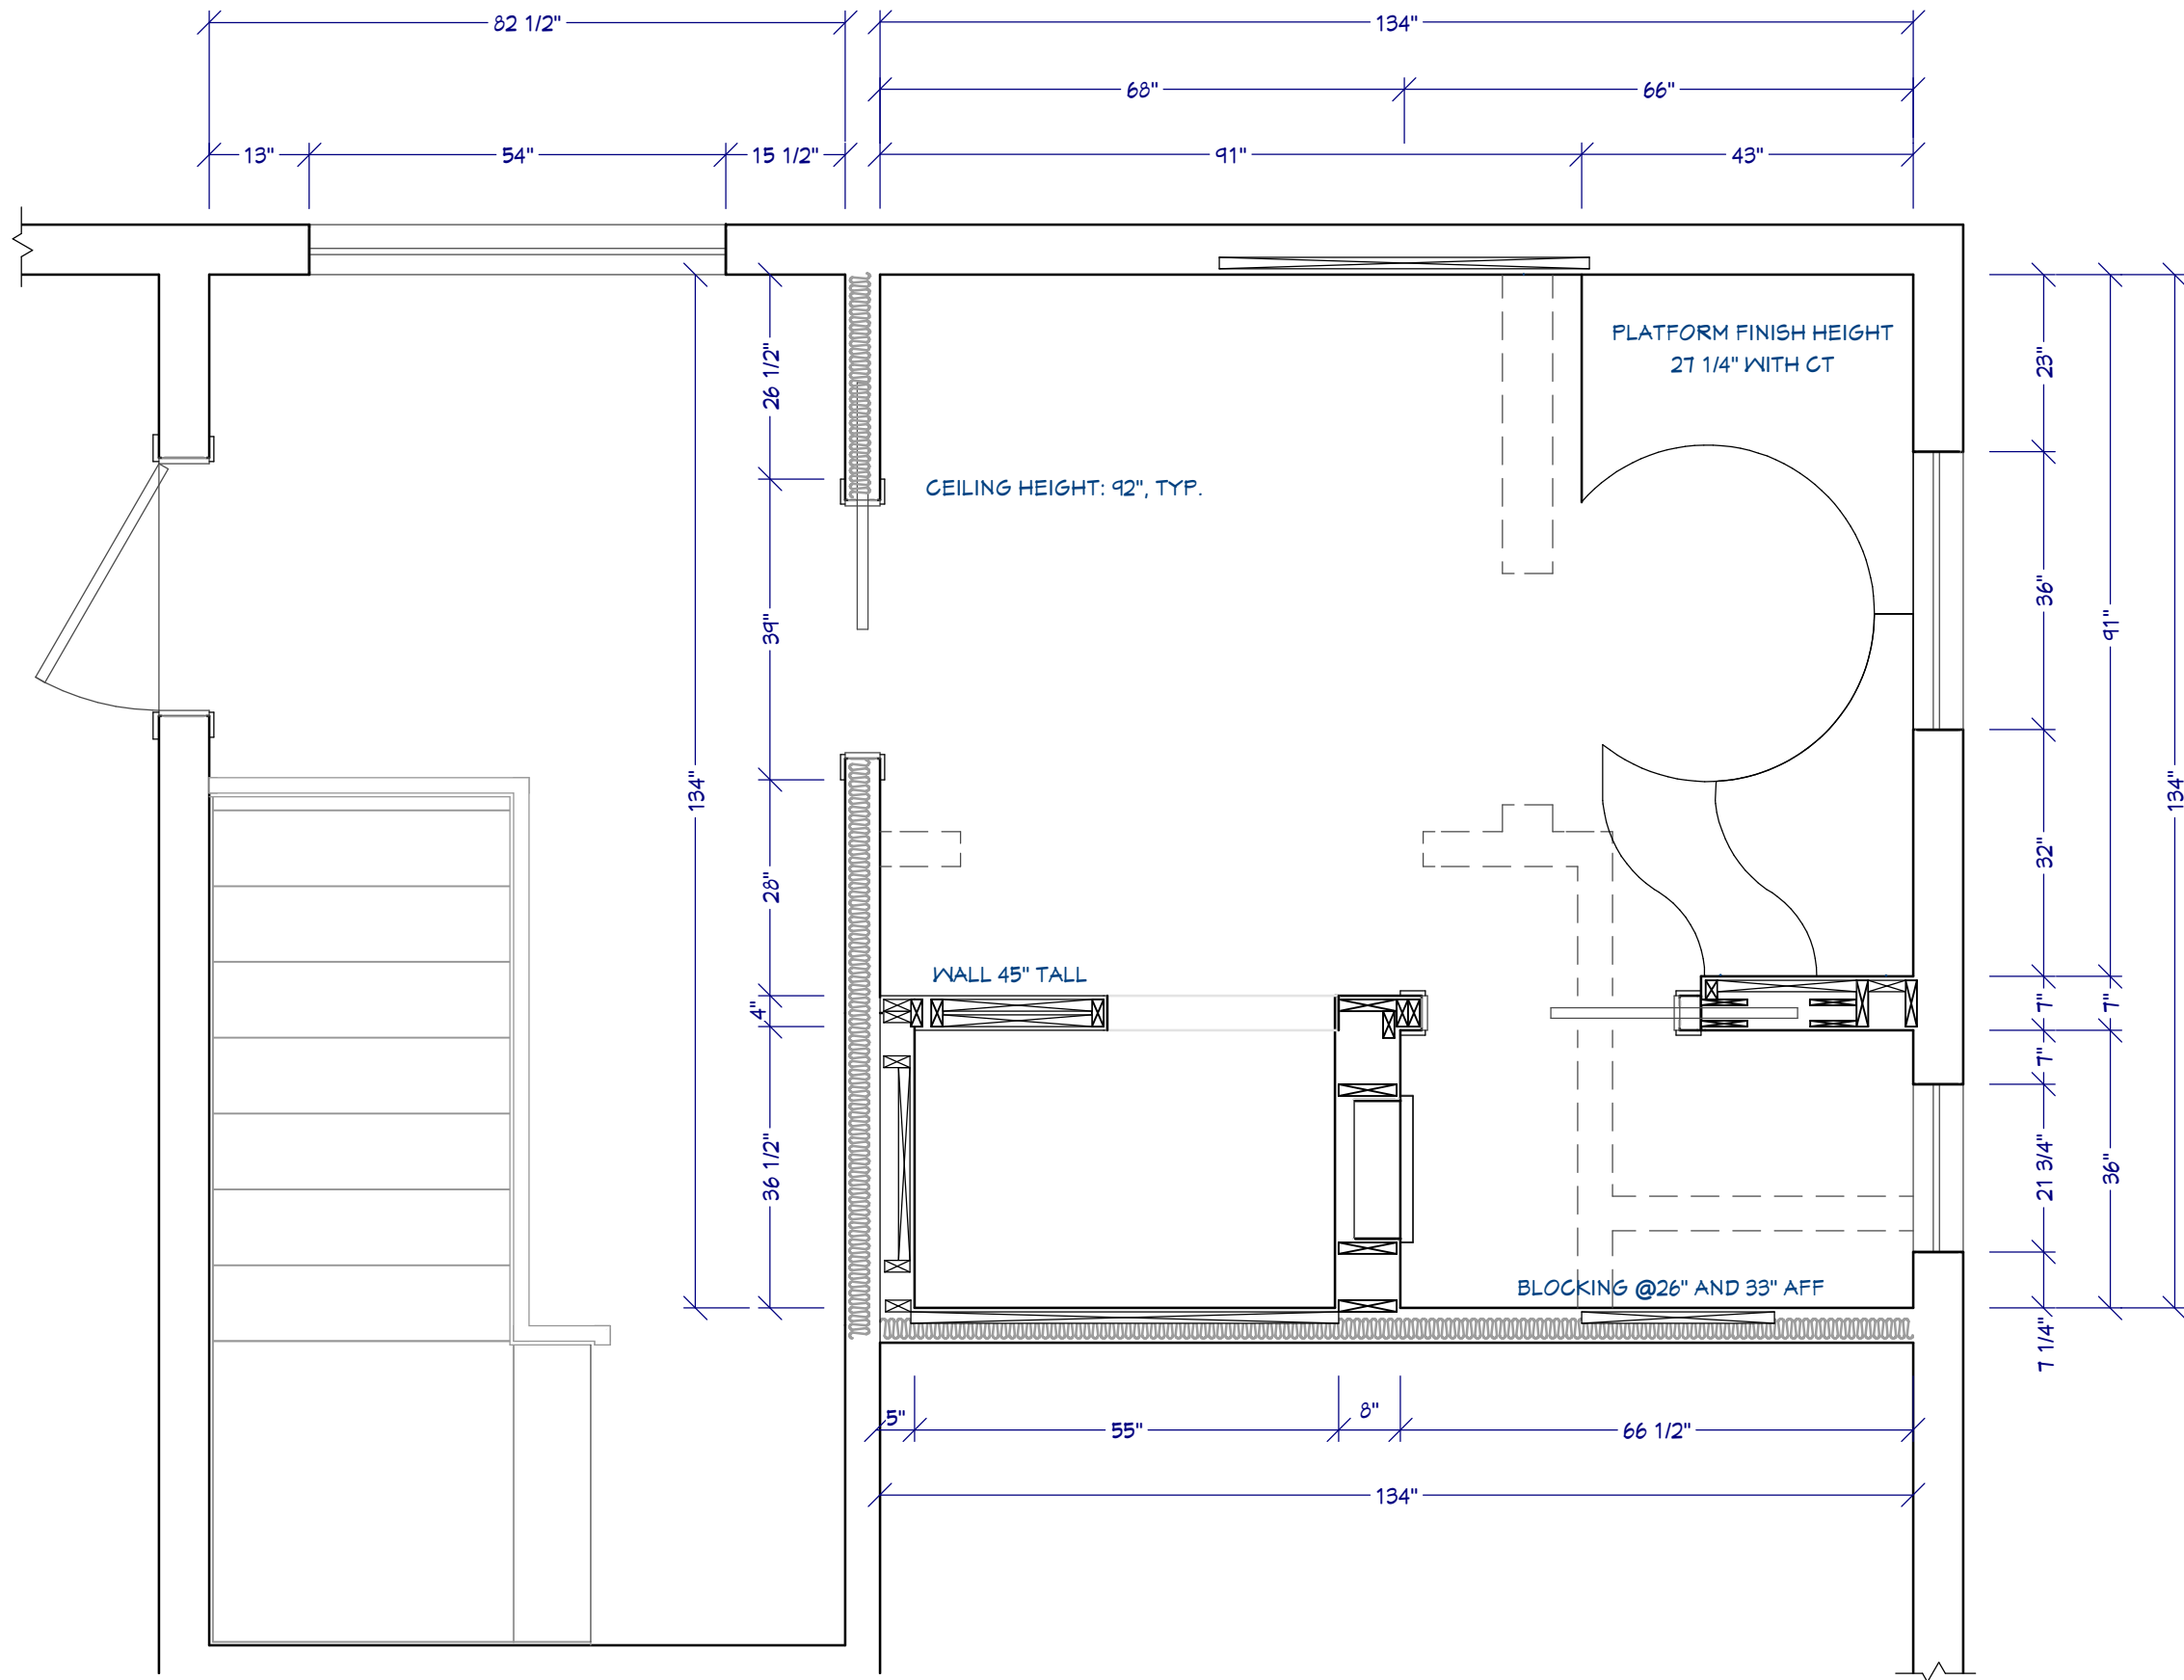


CONSTRUCTION LEGEND:

 
EXISTING WALL TO REMAIN




EXISTING WALL TO BE REMOVED

 

2X4 WALL TO BE ADDED

 

2X8 WALL TO BE ADDED

 

BLOCKING FOR TOWEL/GRAB BARS:
2 x 12 @36" TO CENTER AFF



SOUND INSULATED WALLS



CONSTRUCTION PLAN

1/2" = 1'



DRAWINGS PROVIDED BY: ams
Chief Architect Software
chiefarchitect.com
800.292.3400

DESIGNER:
Robin Rigby Fisher,
CMKBD, CAPS
Robin Rigby Fisher Design


PROJECT DESCRIPTION:
NKBA Study Guide:
Large Bathroom

SHEET TITLE:
CONSTRUCTION
PLAN

SCALE:
SEE VIEW

DATE:
7/17/2017

B-2

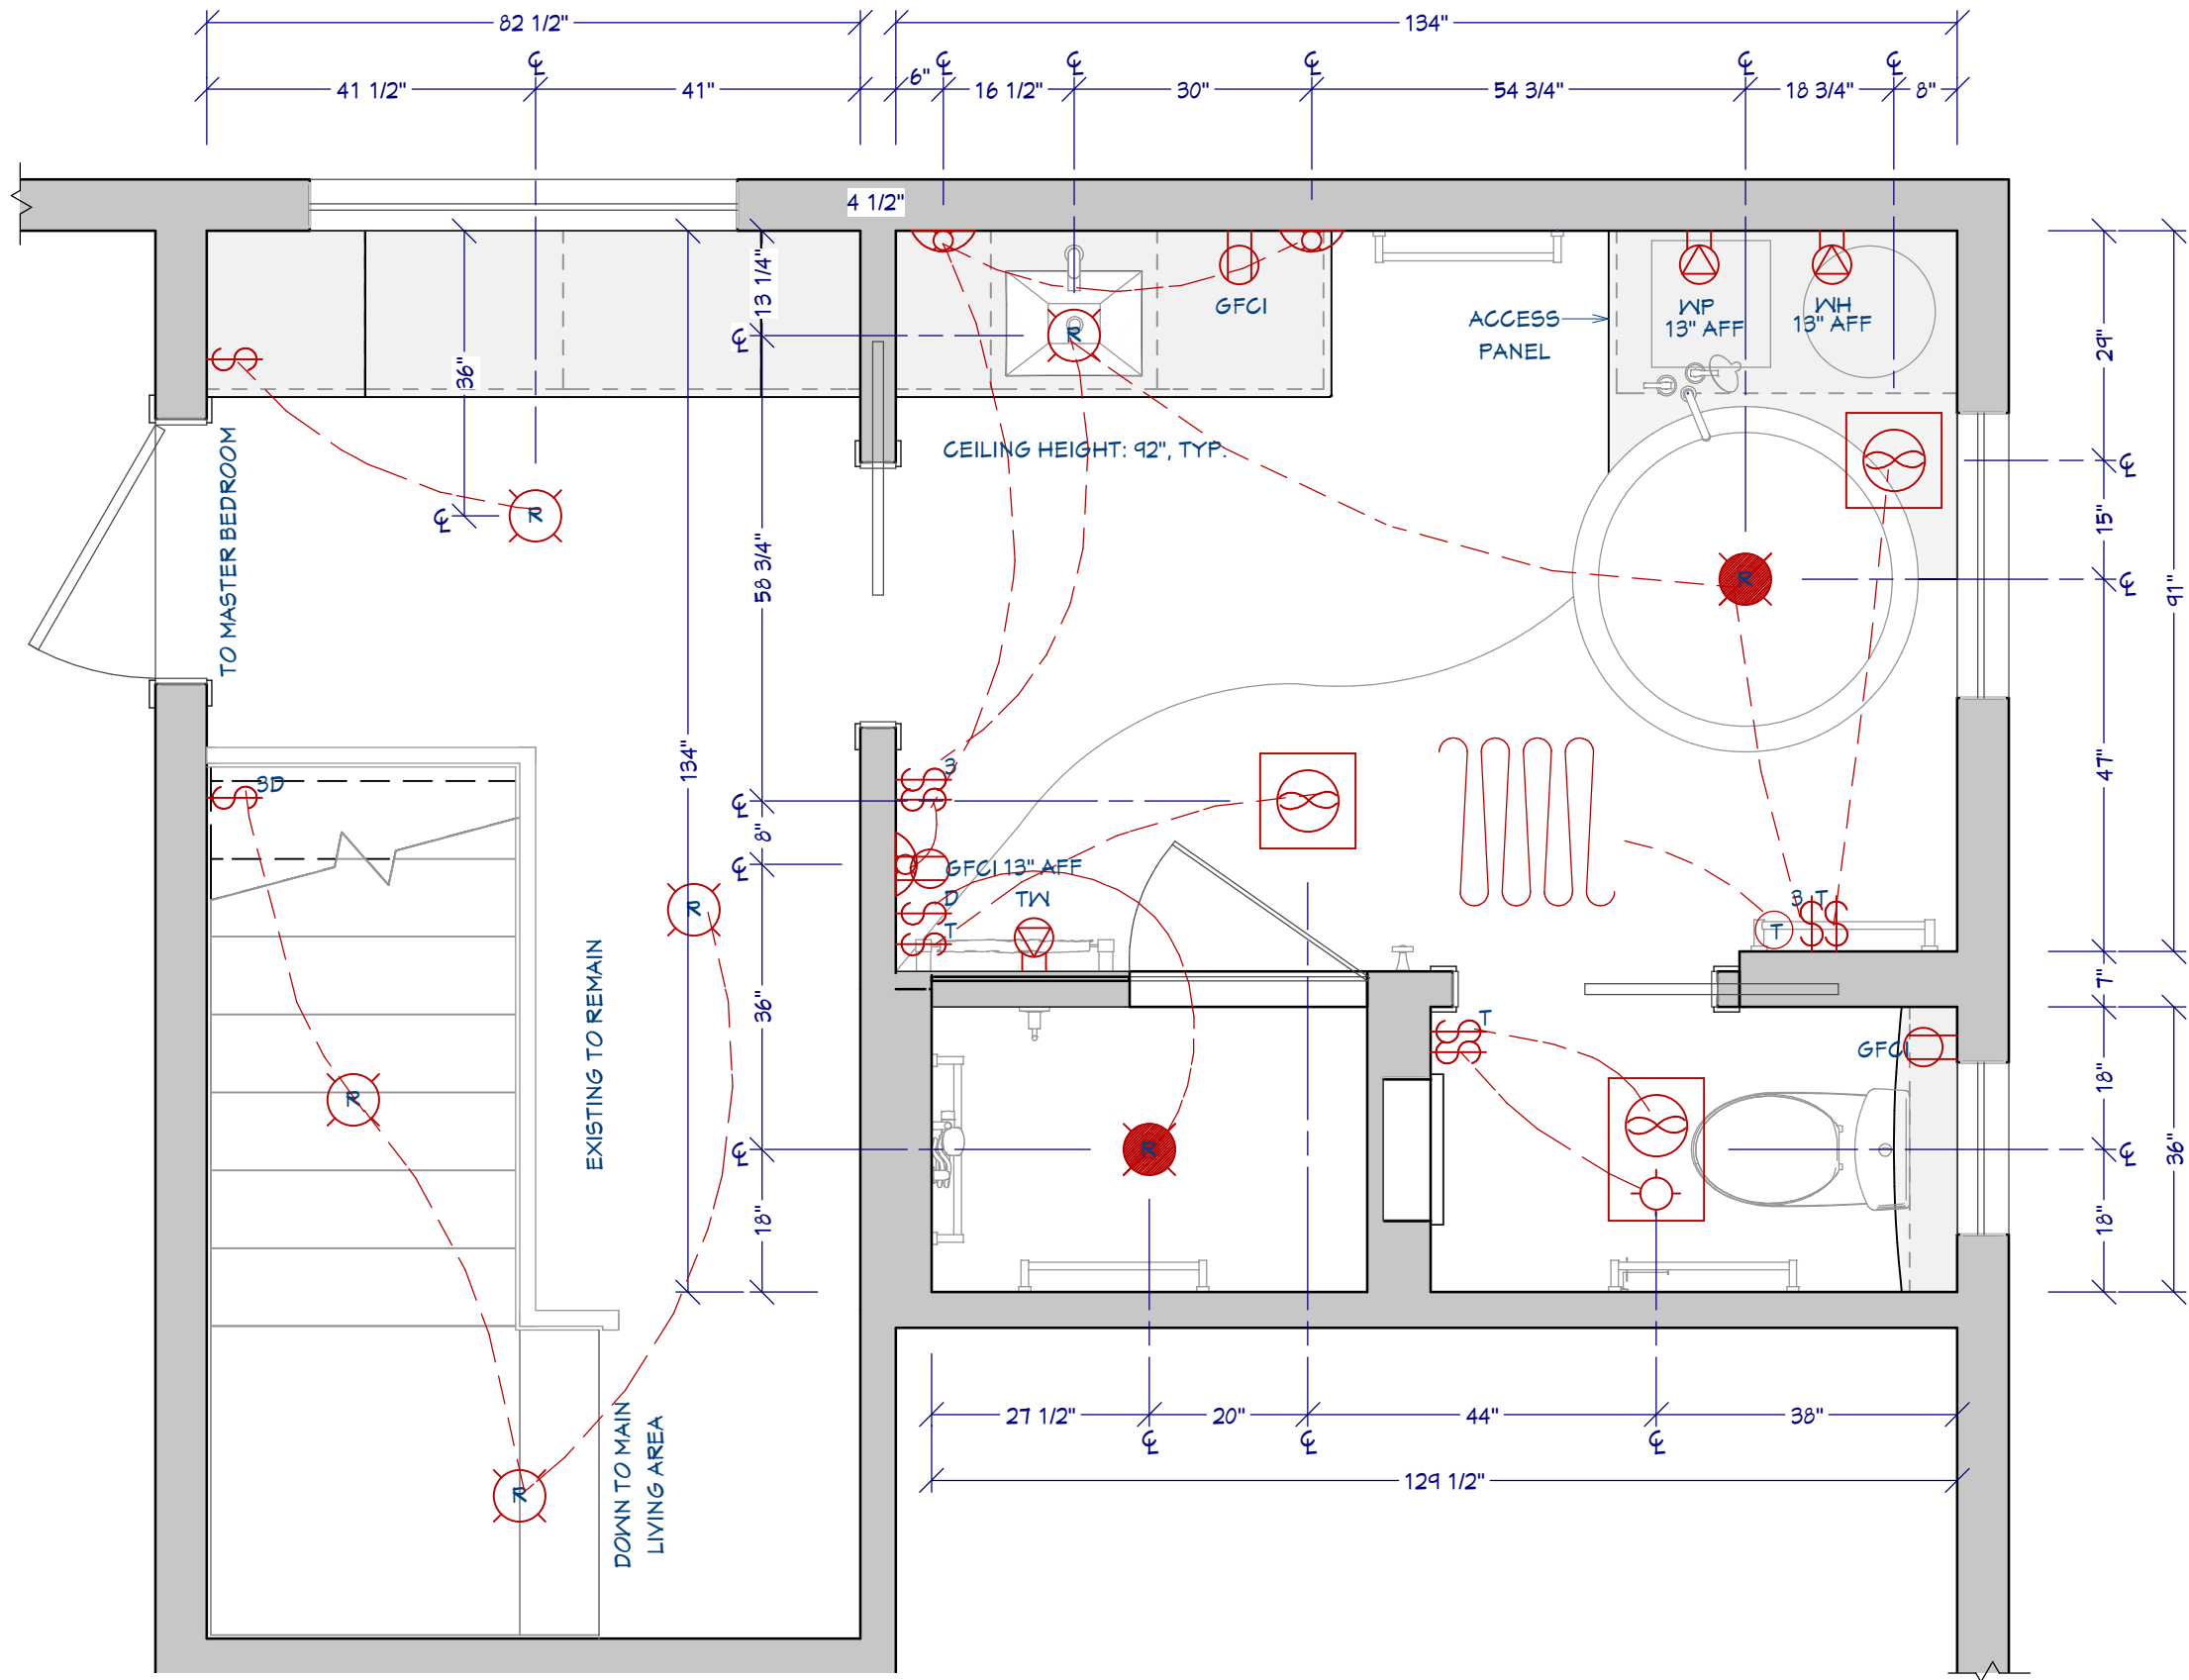

- MECHANICAL LEGEND:**
- 6" L.E.D LIGHT BRAND ABC; MDL. 123
 - 6" L.E.D. LIGHT RATED FOR DAMP LOCATION BRAND ABC; MDL.123
 - INCANDESCENT WALL SCENCE BRAND ABC; MDL. 123
 - EXHAUST FAN WITH LIGHT BRAND ABC; MDL. 123 ; 80CFM
 - EXHAUST FAN BRAND ABC; MDL. 123; 80CFM
 - SINGLE POLE TIMER SWITCH
 - SINGLE POLE DIMMER SWITCH
 - 3-WAY DIMMER SWITCH
 - 3-WAY SWITCH
 - GFCI
 - GROUND FAULT CIRCUIT INTERRUPTER; 120V
 - TOWEL WARMER BRAND ABC; MDL. 123; 120V
 - ON DEMAND WATER HEATER BRAND ABC; 120V
 - TUB PUMP / HEATER BRAND 123; MDL. 234; 120V
 - THERMOSTAT FOR RADIANT FLOOR HEAT
 - IN-FLOOR RADIANT HEATING BRAND ABC; MDL. 123; 120V

*ALL SWITCHES AND RECEPTACLES 48" ABOVE FINISHED FLOOR (AFF) UNLESS NOTED



DRAWINGS PROVIDED BY: ams

Chief Architect Software

chiefarchitect.com

800.292.3400

DESIGNER:

Robin Rigby Fisher,

CMKBD, CAPS

Robin Rigby Fisher Design

PROJECT DESCRIPTION:

NKBA Study Guide:

Large Bathroom

SHEET TITLE:

MECHANICAL PLAN


SCALE:

SEE VIEW

DATE:

7/17/2017

B-3

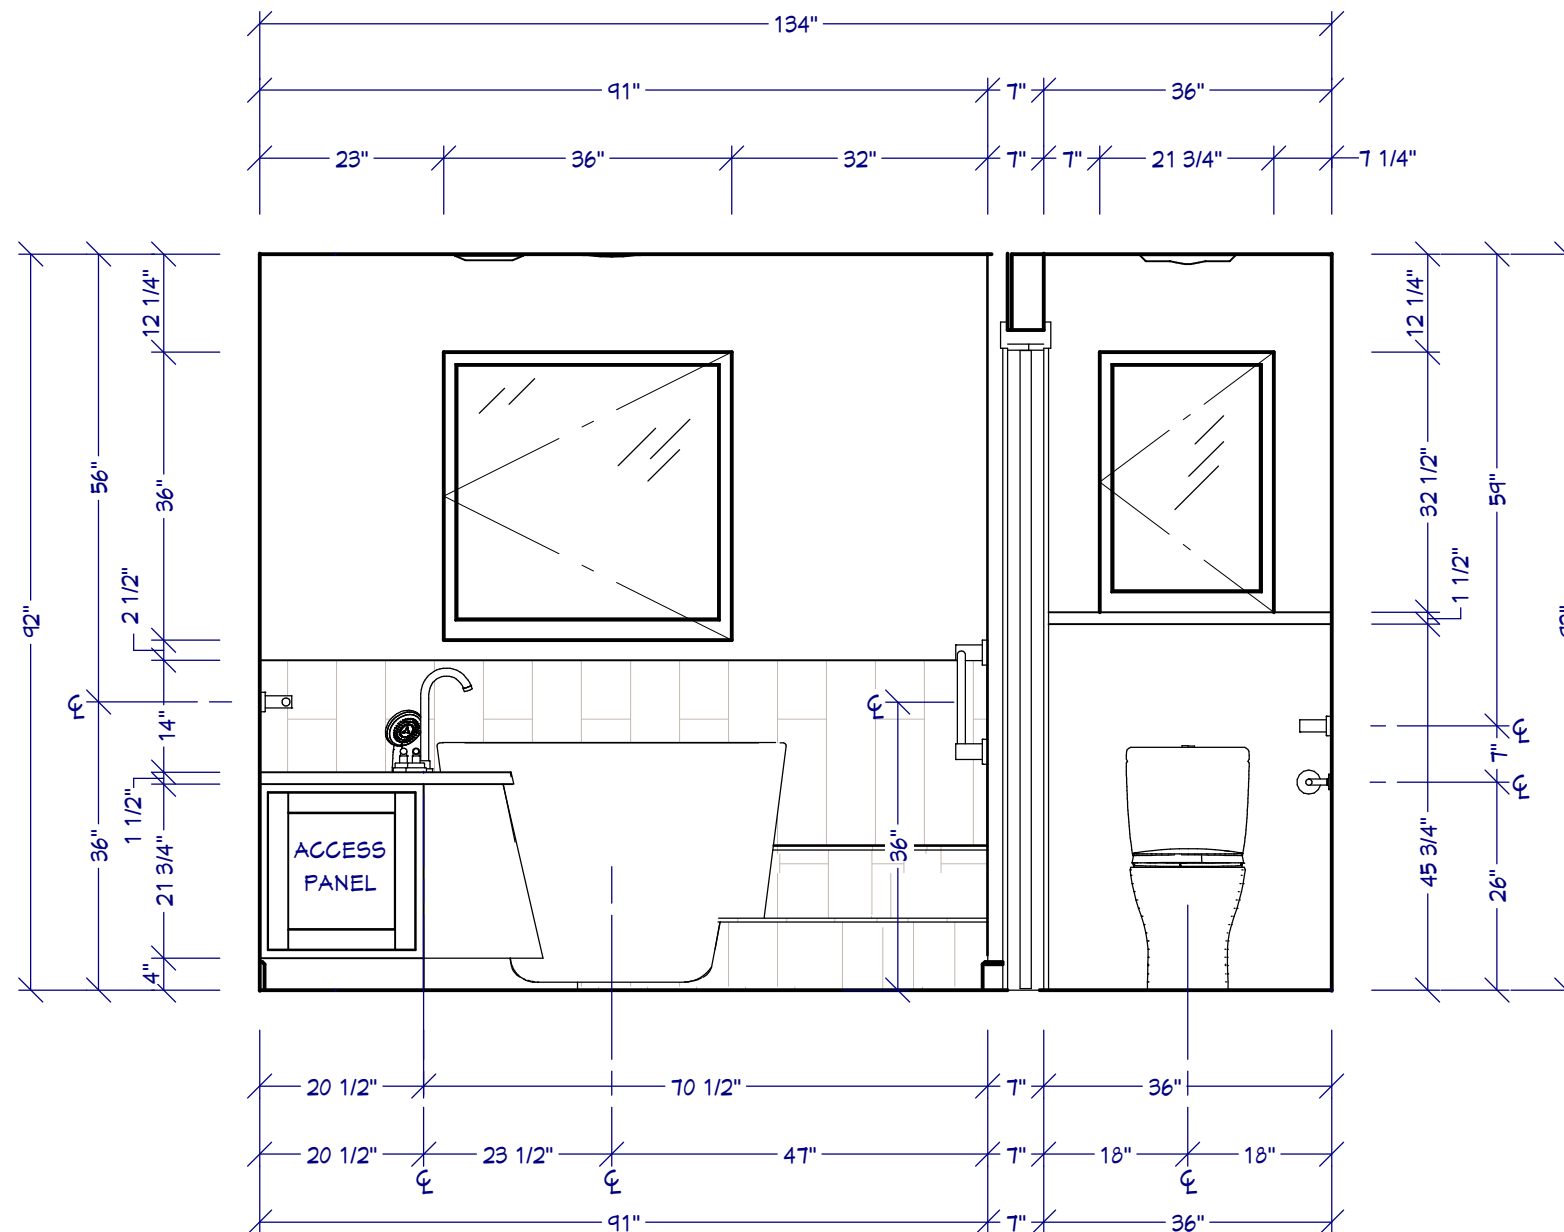

ELEVATION C
1/2" = 1'



DRAWINGS PROVIDED BY: ams
Chief Architect Software
chiefarchitect.com
800.292.3400

DESIGNER:
Robin Rigby Fisher,
CMKBD, CAPS
Robin Rigby Fisher Design

PROJECT DESCRIPTION:
NKBA Study Guide:
Large Bathroom


SHEET TITLE:
ELEVATIONS

SCALE:
SEE VIEW

DATE:
7/17/2017

B-5



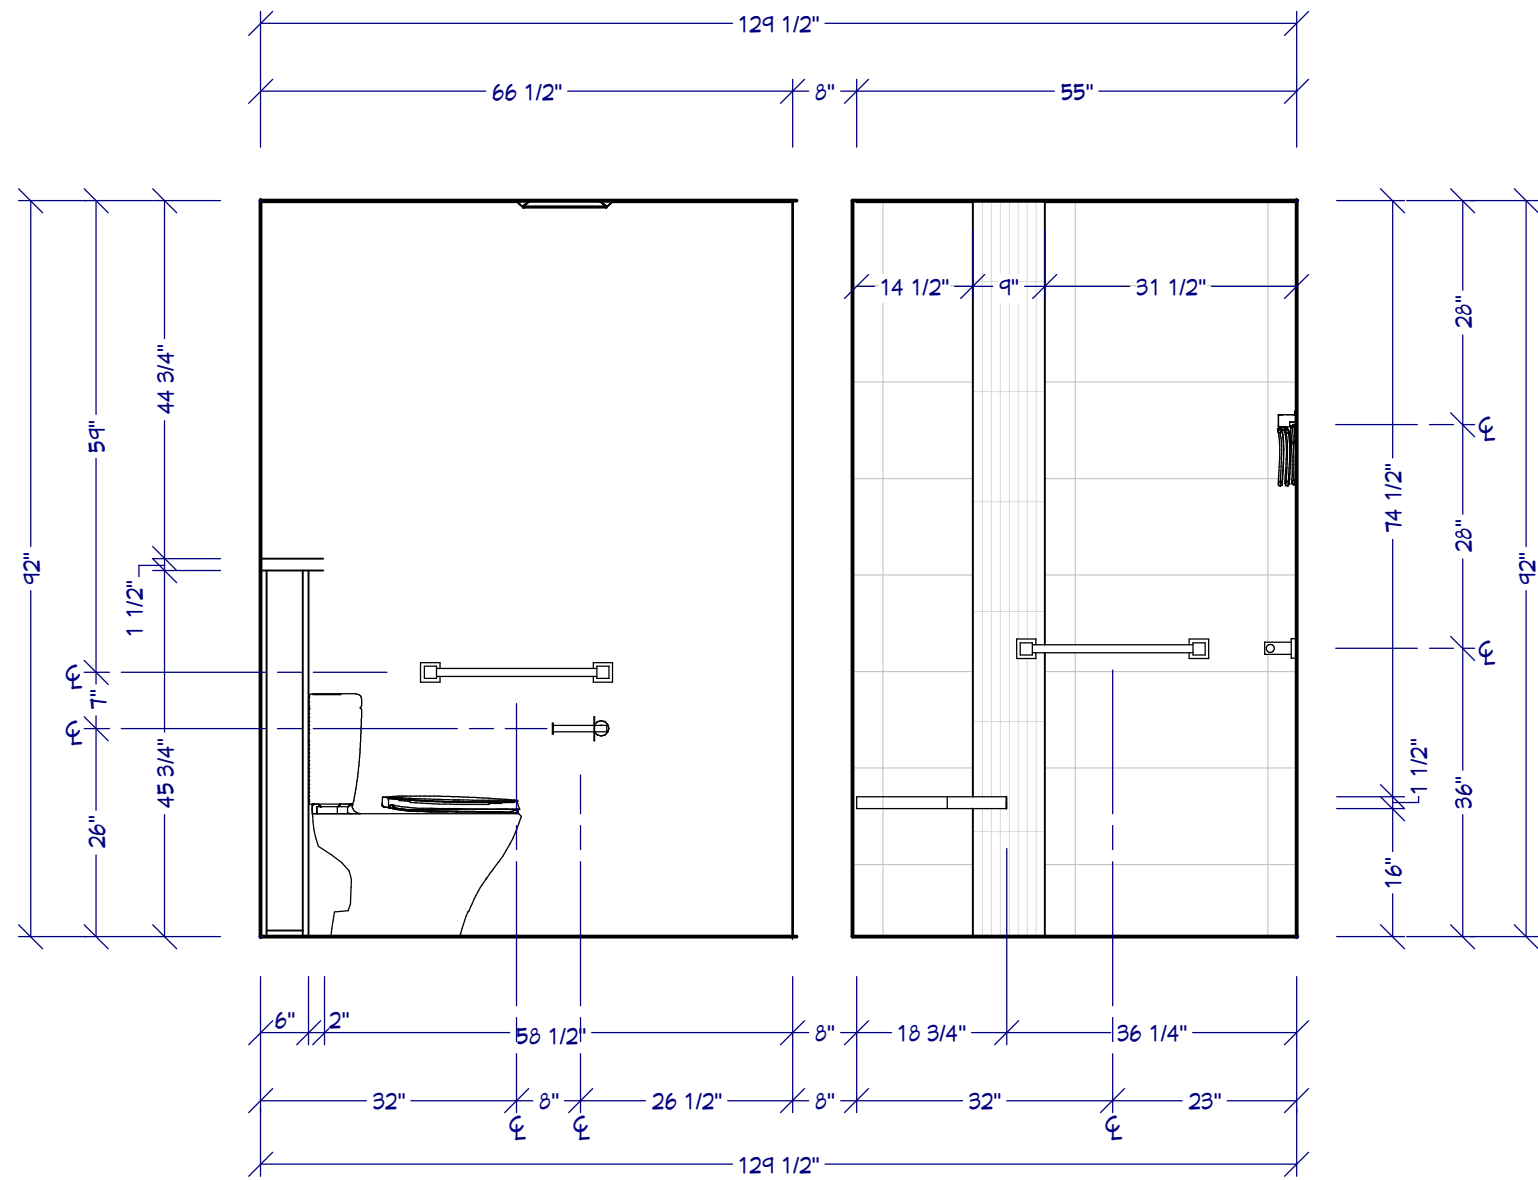

E ELEVATION E
1/2" = 1'



DRAWINGS PROVIDED BY: ams
Chief Architect Software
chiefarchitect.com
800.292.3400

DESIGNER:
Robin Rigby Fisher,
CMKBD, CAPS
Robin Rigby Fisher Design


PROJECT DESCRIPTION:
NKBA Study Guide:
Large Bathroom

SHEET TITLE:
ELEVATIONS


SCALE:
SEE VIEW

DATE:
7/17/2017

B-7

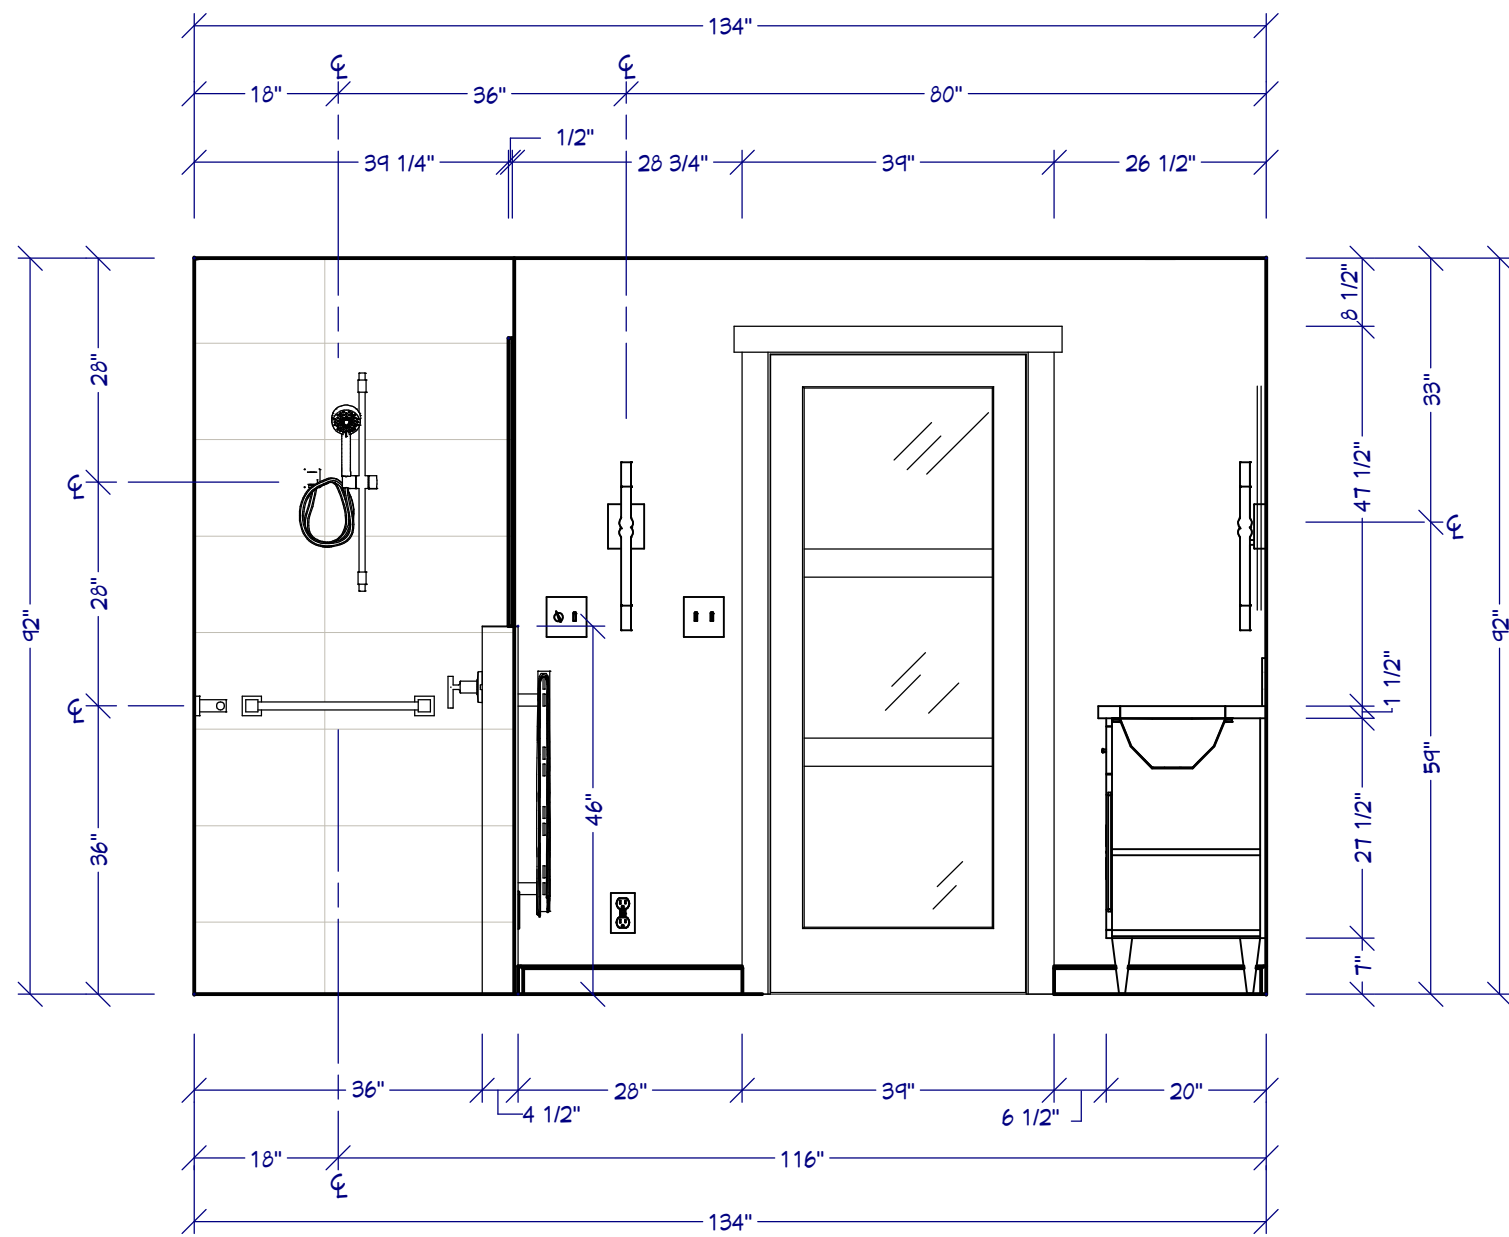

F ELEVATION F
1/2" = 1'

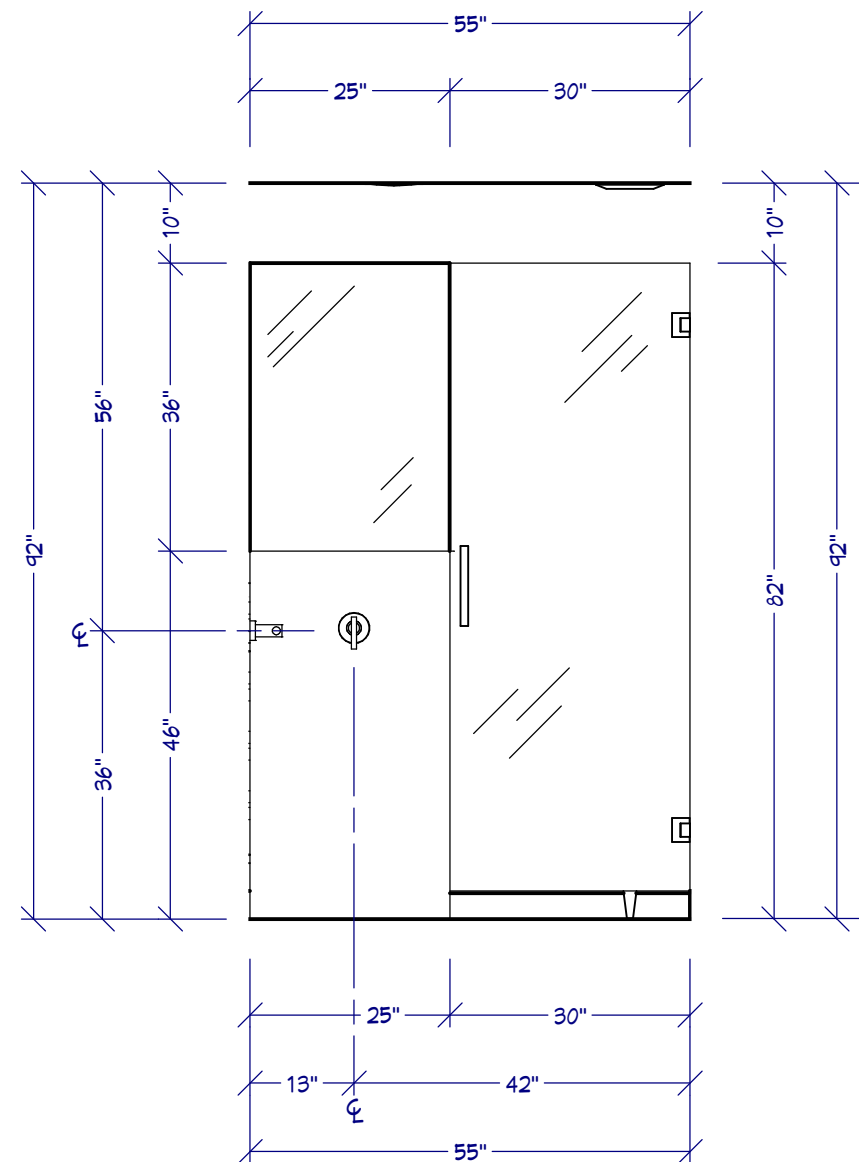

G ELEVATION G
1/2" = 1'



PERSPECTIVE WATERCOLOR
NO SCALE



DRAWINGS PROVIDED BY: ams
Chief Architect Software
chiefarchitect.com
800.292.3400

DESIGNER:
Robin Rigby Fisher,
CMKBD, CAPS
Robin Rigby Fisher Design

PROJECT DESCRIPTION:
NKBA Study Guide:
Large Bathroom

SHEET TITLE:
PERSPECTIVE

SCALE:
SEE VIEW

DATE:
7/17/2017



DRAWINGS PROVIDED BY: ams
Chief Architect Software
chiefarchitect.com
800.292.3400

DESIGNER:
Robin Rigby Fisher,
CMKBD, CAPS
Robin Rigby Fisher Design

PROJECT DESCRIPTION:
NKBA Study Guide:
Large Bathroom

SHEET TITLE:
FINAL PHOTOS

SCALE:
SEE VIEW

DATE:
7/17/2017

B-10