




NKBA STUDY GUIDE: MEDIUM KITCHEN

design by:

Lauren Levant - Lauren Levant Interior

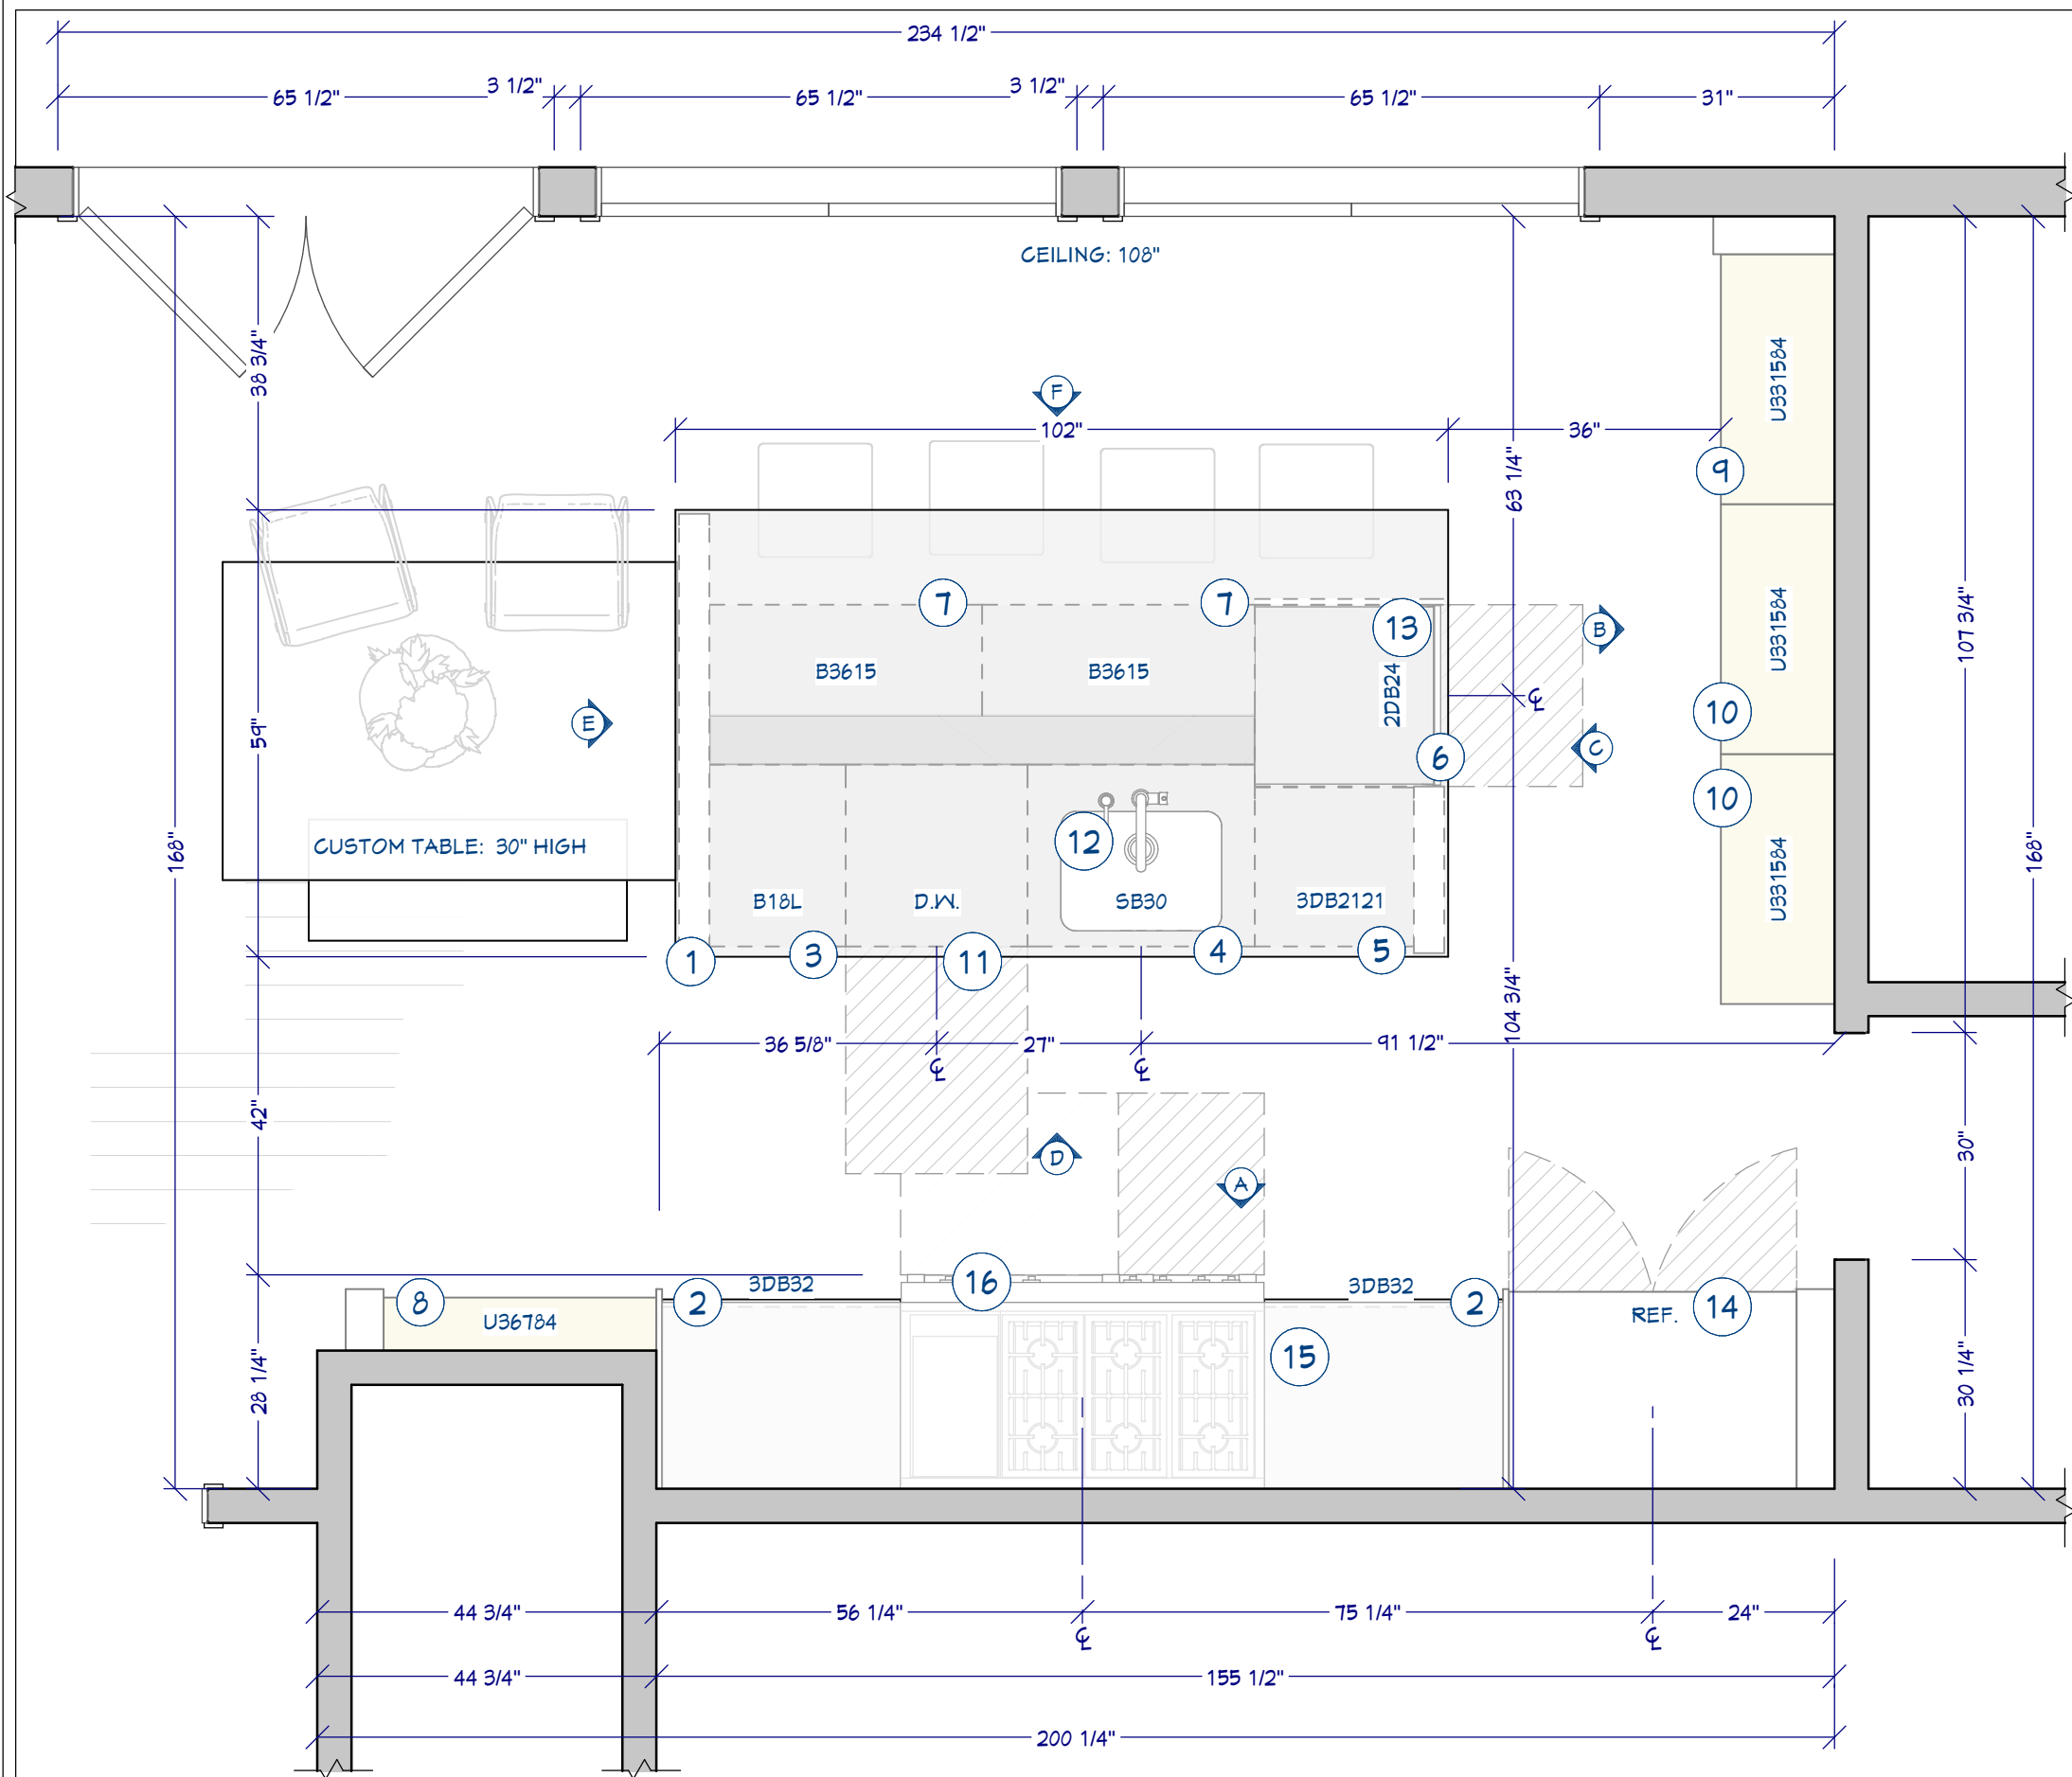

FLOOR PLAN SPECIFICATION:

- ① 4" END PANEL
- ② 3 ADJUSTABLE DIVIDERS TOP DRAWER
- ③ CUTLERY INSERT
- ④ TILT DOWN S/S TRAY
SINK MAT IN BOTTOM
- ⑤ FULL EXTENSION SLIDES
- ⑥ MICROWAVE CABINET CUT TO FIT
FULL EXTENSION DRAWER SLIDES
- ⑦ TOUCH LATCH DOORS
- ⑧ BI-FOLD RIGHT DOORS
MIDDLE & BOTTOM DRAWERS PINNED TOGETHER
- ⑨ TOP DOORS BIFOLD LEFT
4 ADJUSTABLE SHELVES TOP
2 ADJUSTABLE SHELVES BOTTOM
- ⑩ 2 ADJUSTABLE SHELVES TOP
2 ADJUSTABLE SHELVES BOTTOM
- ⑪ PANEL FRONT DISHWASHER BRAND ABC; MDL. 123
- ⑫ SINK BRAND ABC; MDL. 123;
FAUCET BRAND ABC; MDL. 234
- ⑬ MICROWAVE DRAWER BRAND ABC; MDL. 123
- ⑭ PANEL FRONT REFRIGERATOR 36"W BRAND ABC;
MDL. 234
- ⑮ CUSTOM STEEL VENT HOOD 111"W
- ⑯ DUAL FUEL RANGE 48"W BRAND ABC; MDL. 123

FLOOR PLAN

1/2" = 1'



DRAWINGS PROVIDED BY: ams
Chief Architect Software
chiefarchitect.com
800.292.3400

DESIGNER:
Lauren Levant
Lauren Levant Interior


PROJECT DESCRIPTION:
NKBA Study Guide:
Medium Kitchen

SHEET TITLE:
FLOOR PLAN



SCALE:
SEE VIEW

DATE:
7/14/2017

K-1

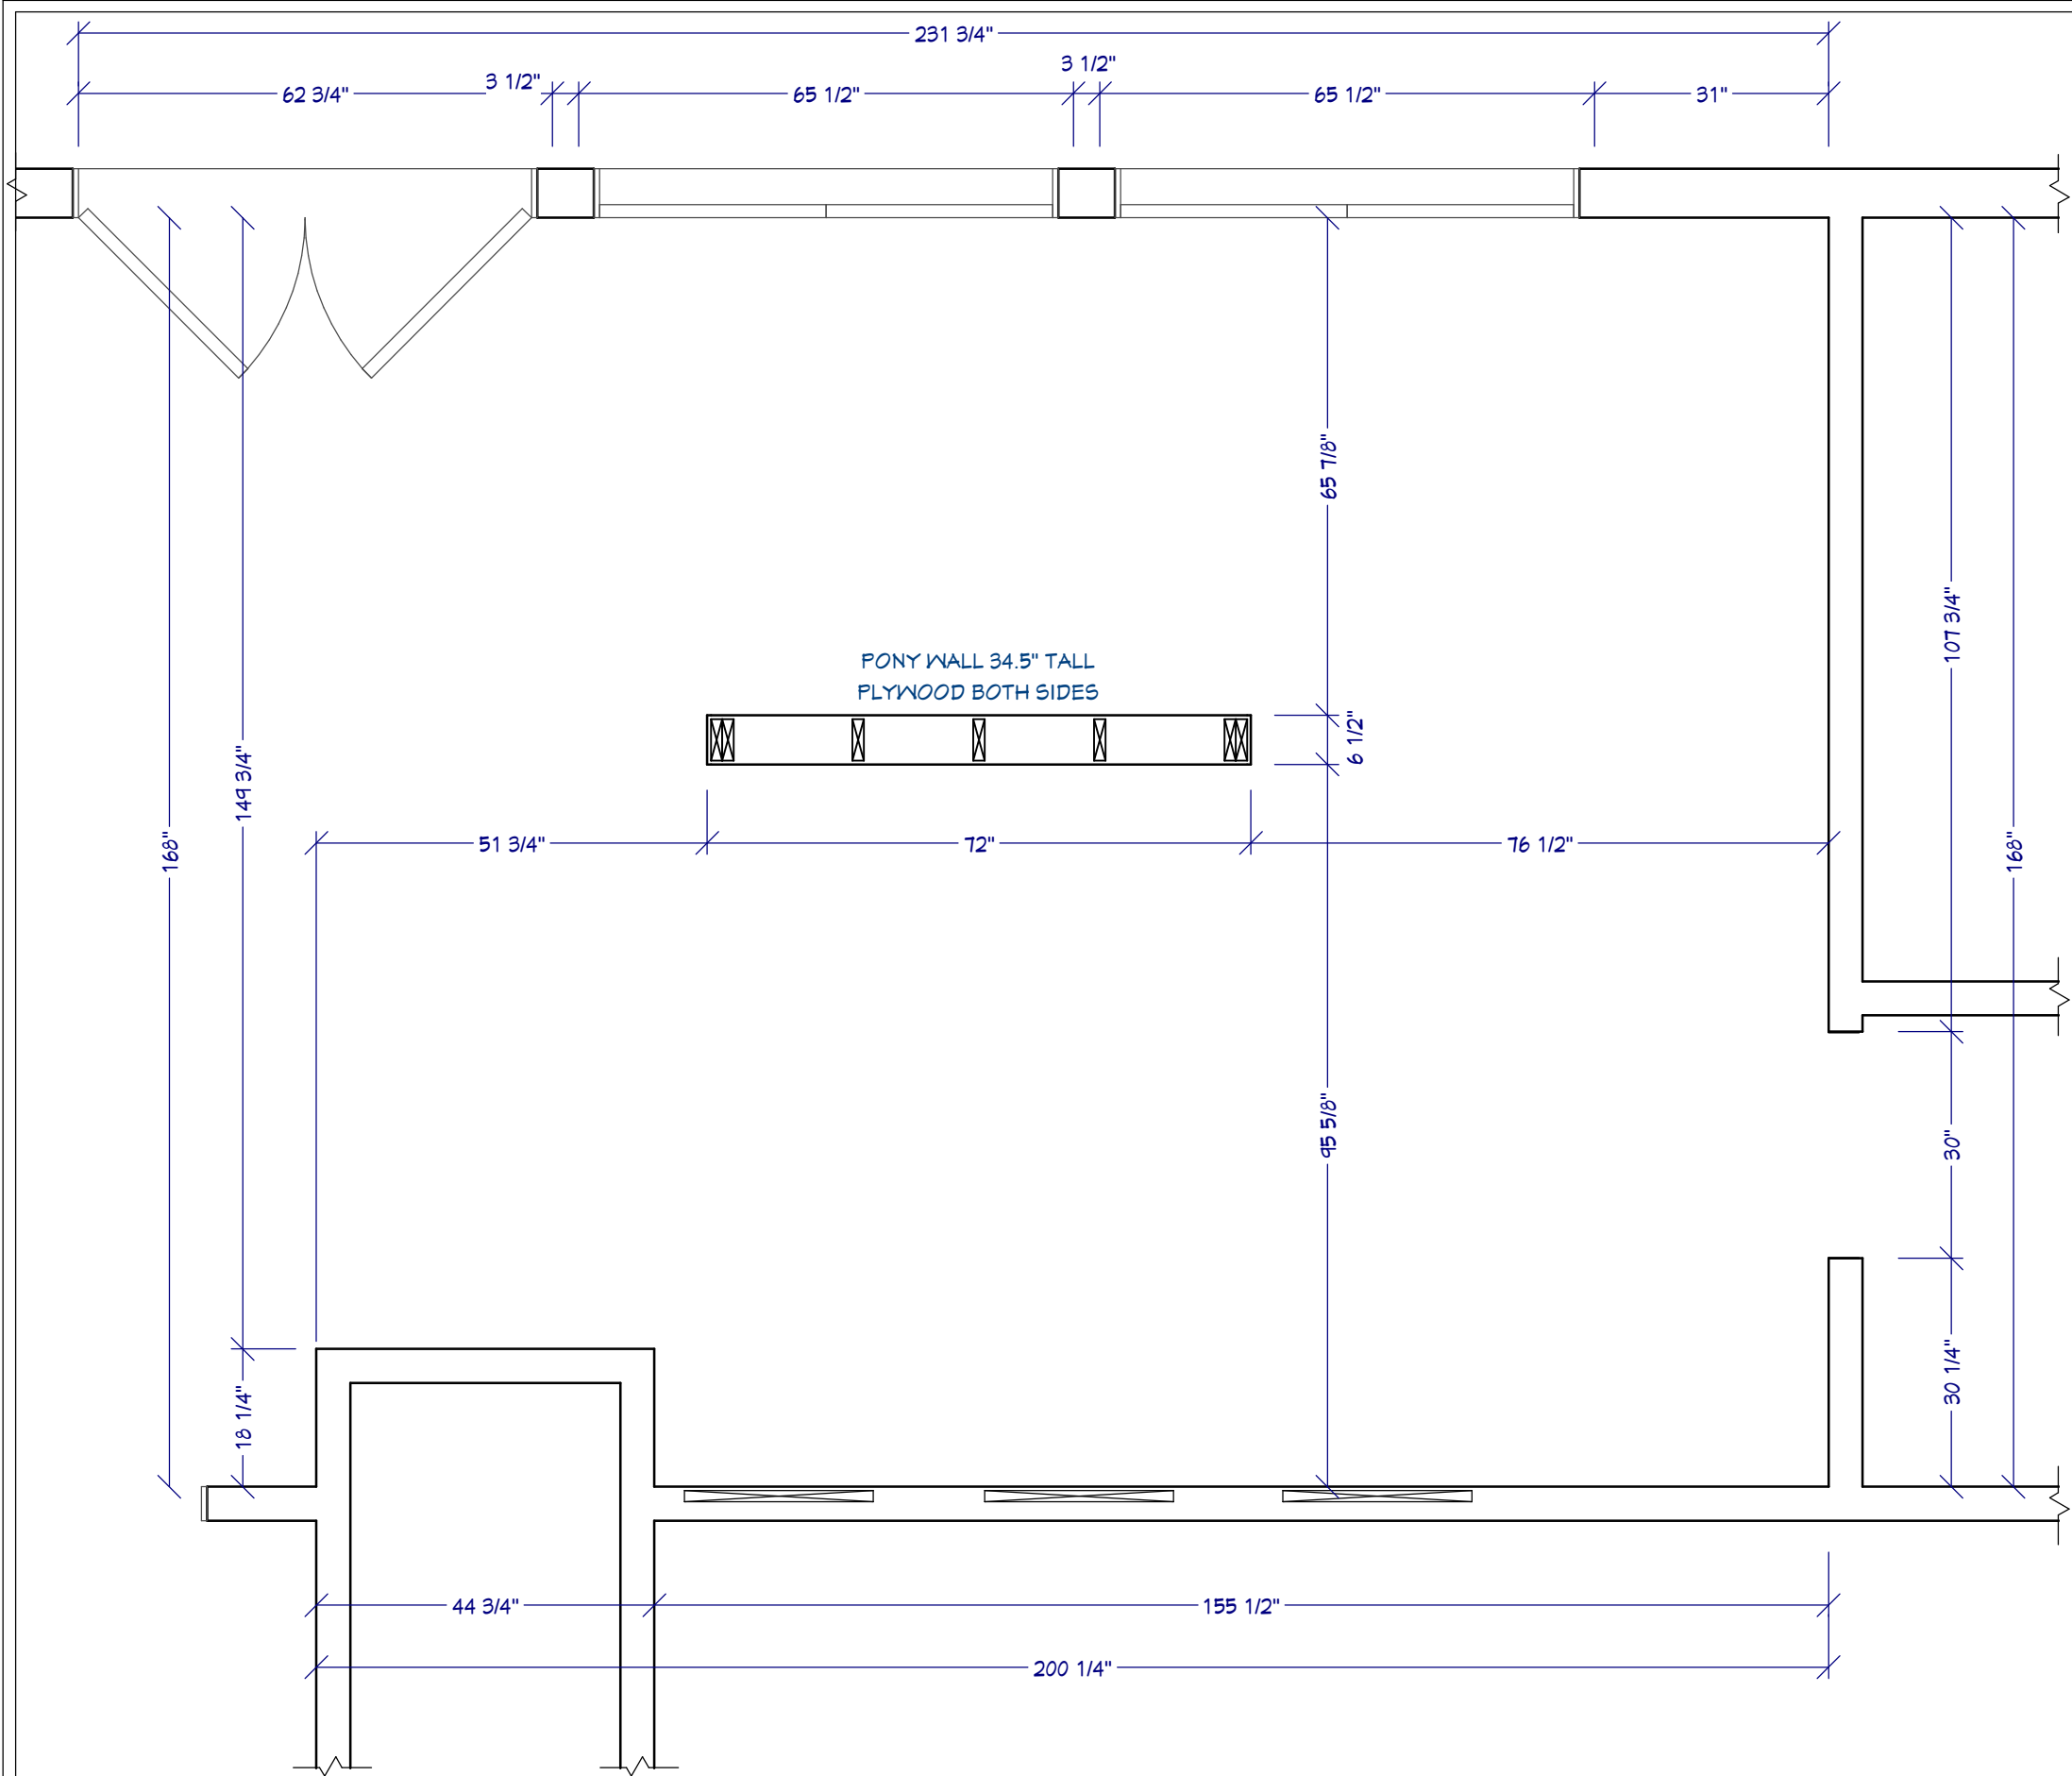

CONSTRUCTION LEGEND

  

CONSTRUCTION PLAN

1/2" = 1'



DRAWINGS PROVIDED BY: ams
Chief Architect Software
chiefarchitect.com
800.292.3400

DESIGNER:
Lauren Levant
Lauren Levant Interior


PROJECT DESCRIPTION:
NKBA Study Guide:
Medium Kitchen

SHEET TITLE:
CONSTRUCTION
PLAN

SCALE:
SEE VIEW

DATE:
7/14/2017

K-2

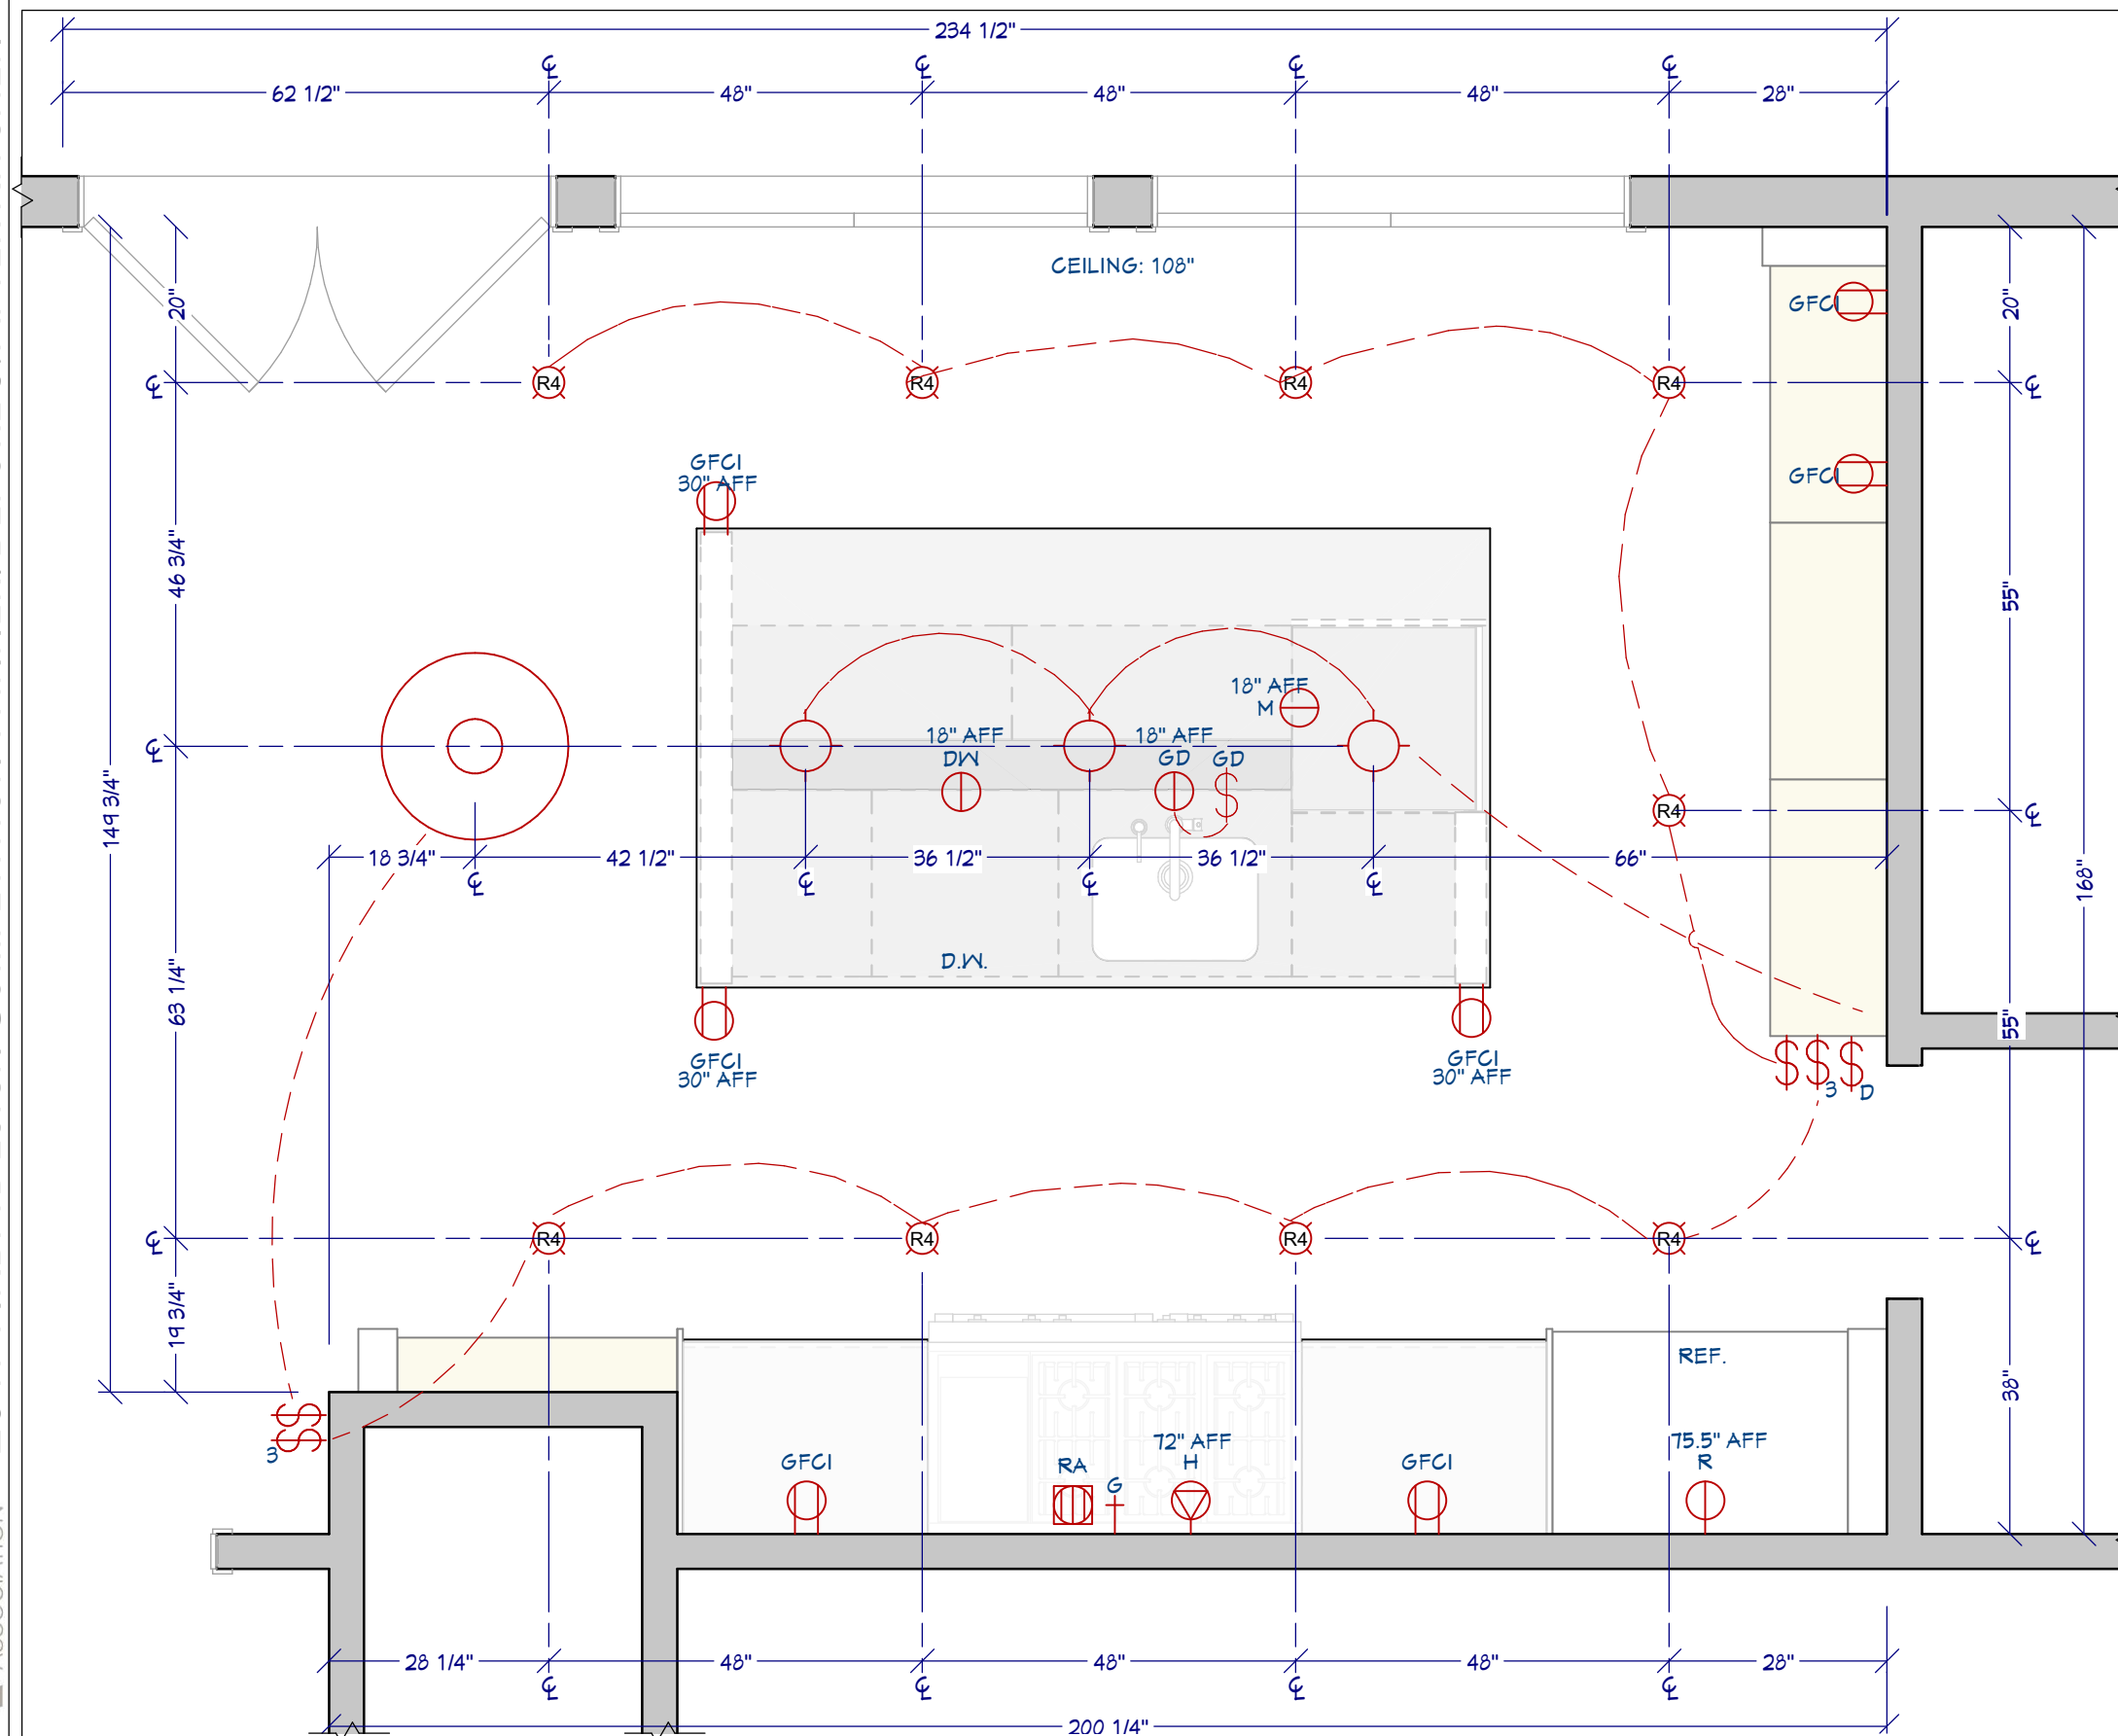

MECHANICAL LEGEND:

- | | |
|---|--|
|  | 4" L.E.D. RECESSED CAN LIGHT BRAND ABC; MDL. 123 |
|  | PENDANT HALOGEN LIGHT BRAND ABC; MDL. 123 |
|  | PENDANT FLUORESCENT LIGHT BRAND XYZ; MDL. 234 |
|  | 24" DISHWASHER BRAND ABC; MDL. 123; 120V |
|  | GARBAGE DISPOSAL BRAND ABC; MDL. 123; 120V |
|  | 24" MICROWAVE DRAWER BRAND ABC; MDL. 123; 120V |
|  | 111" CUSTOM STEEL VENT HOOD EXHAUST; 1600CFM, 120V |
|  | 48" DUAL FUEL RANGE BRAND ABC; MDL.123; 240V |
|  | GAS LINE |
|  | 36" FRENCH DOOR REFRIGERATOR BRAND ABC; MDL. 123; 120V |
|  | GROUND FAULT CIRCUIT INTERRUPTER (GFCI); 120V |
|  | SINGLE POLE SWITCH |
|  | SINGLE POLE DIMMER SWITCH |
|  | 3-WAY SWITCH |
|  | SURFACE MOUNTED BATCH FEED GARBAGE DISPOSAL AIR SWITCH |

*ALL SWITCHES AND RECEPTACLES 48" ABOVE FINISHED FLOOR
(AFF) UNLESS NOTED

MECHANICAL PLAN

$$1/2'' = 1'$$


DRAWINGS PROVIDED BY: ams

Chief Architect Software
chiefarchitect.com
800.292.3400

DESIGNER:
Lauren Levant
Lauren Levant Interior

PROJECT DESCRIPTION:

NKBA Study Guide:
Medium Kitchen

SHEET TITLE:


MECHANICAL PLAN

SCALE:

SEE VIEW

DATE: 7/14/2017

K-3

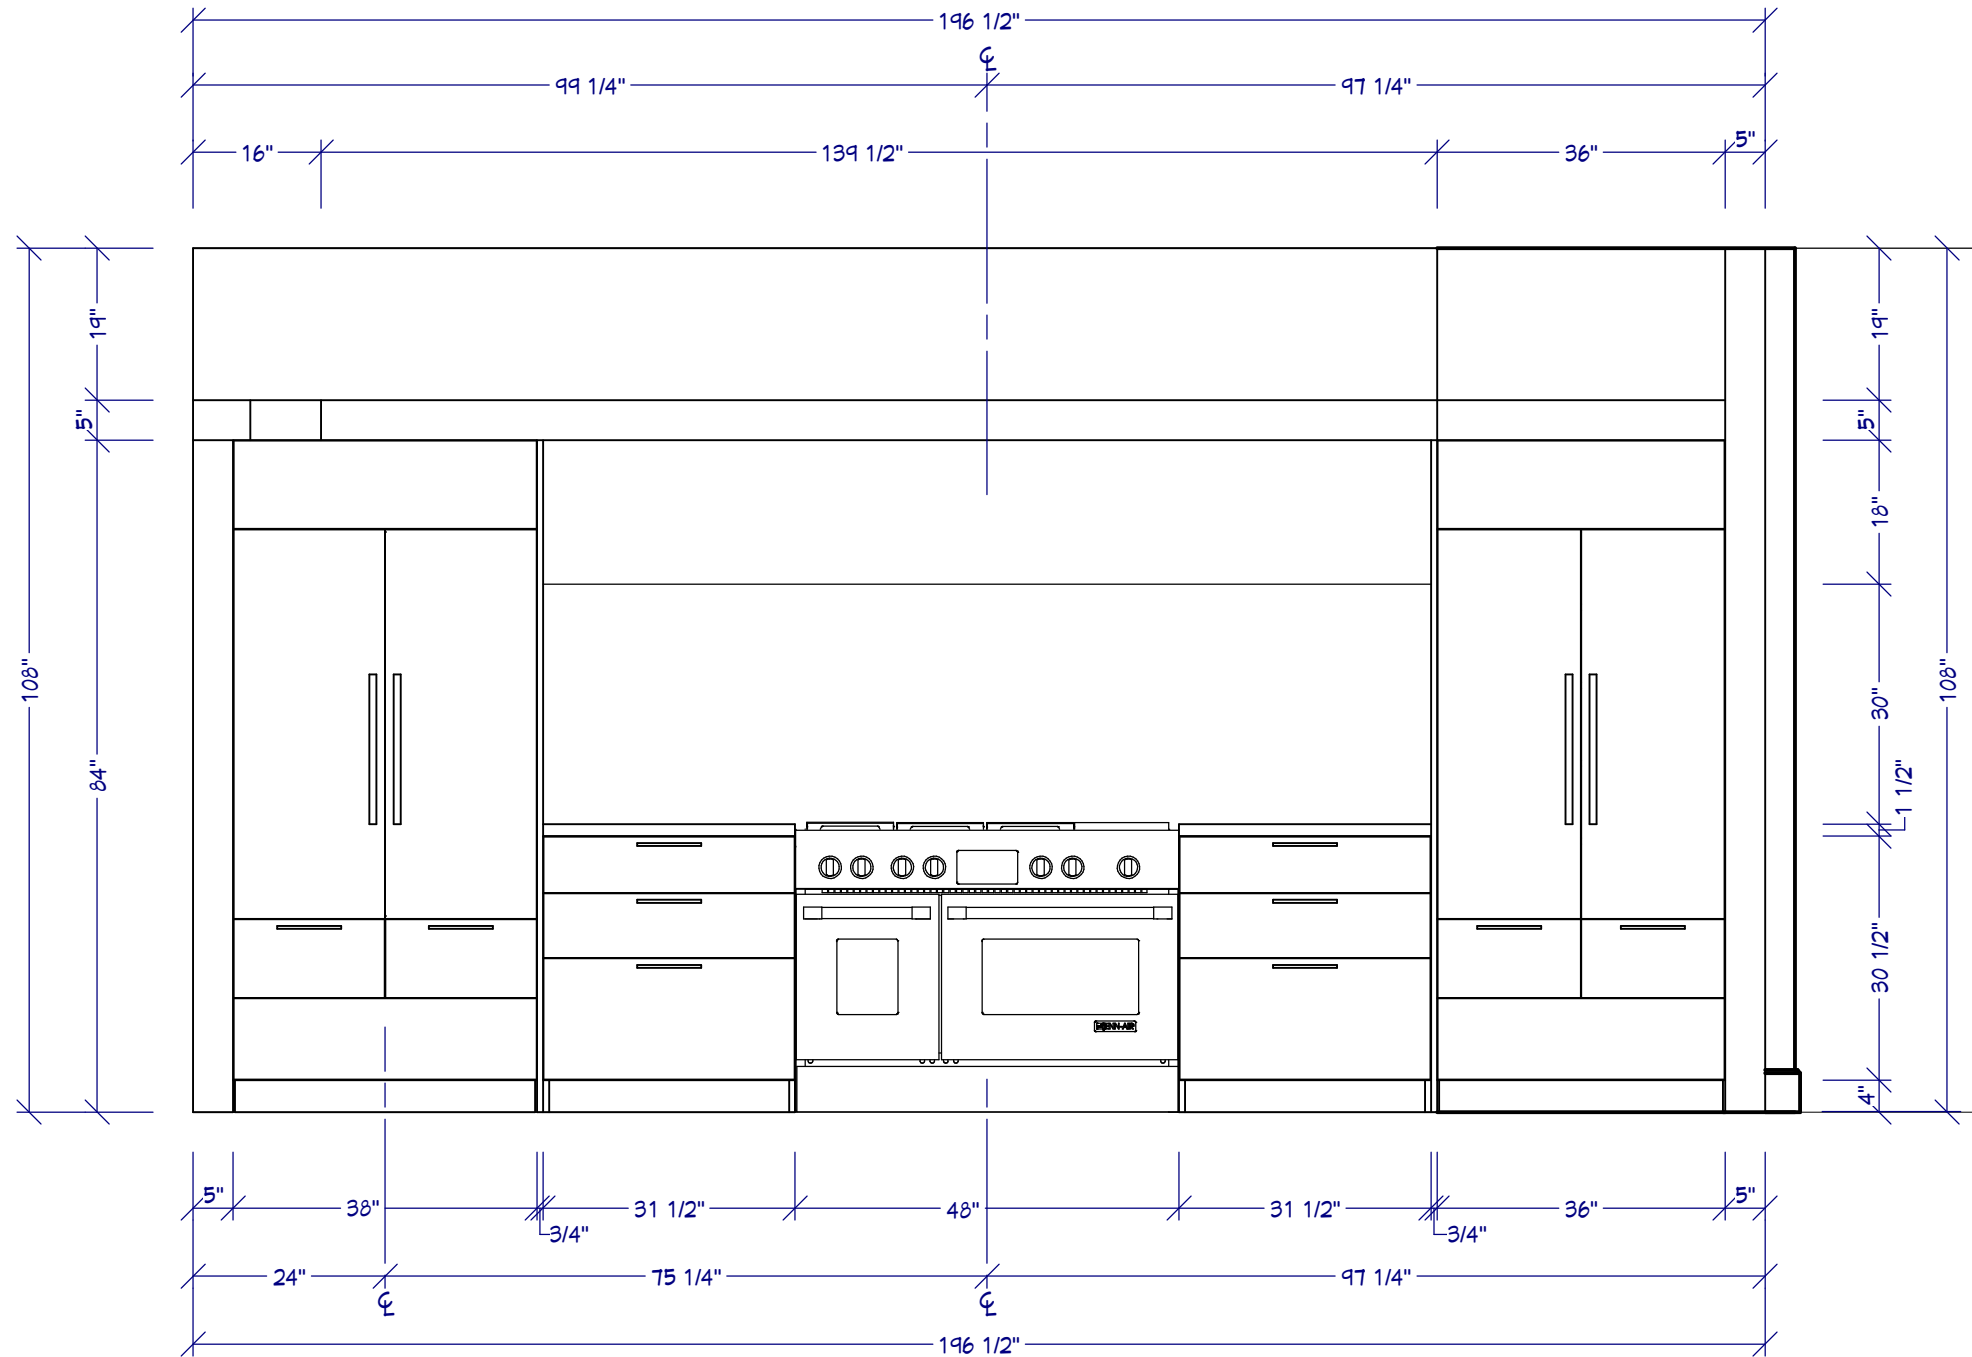

ELEVATION A
1/2" = 1'



DRAWINGS PROVIDED BY: ams
Chief Architect Software
chiefarchitect.com
800.292.3400


DESIGNER:
Lauren Levant
Lauren Levant Interior

PROJECT DESCRIPTION:
NKBA Study Guide:
Medium Kitchen


SHEET TITLE:
ELEVATIONS

SCALE:
SEE VIEW


DATE:
7/14/2017

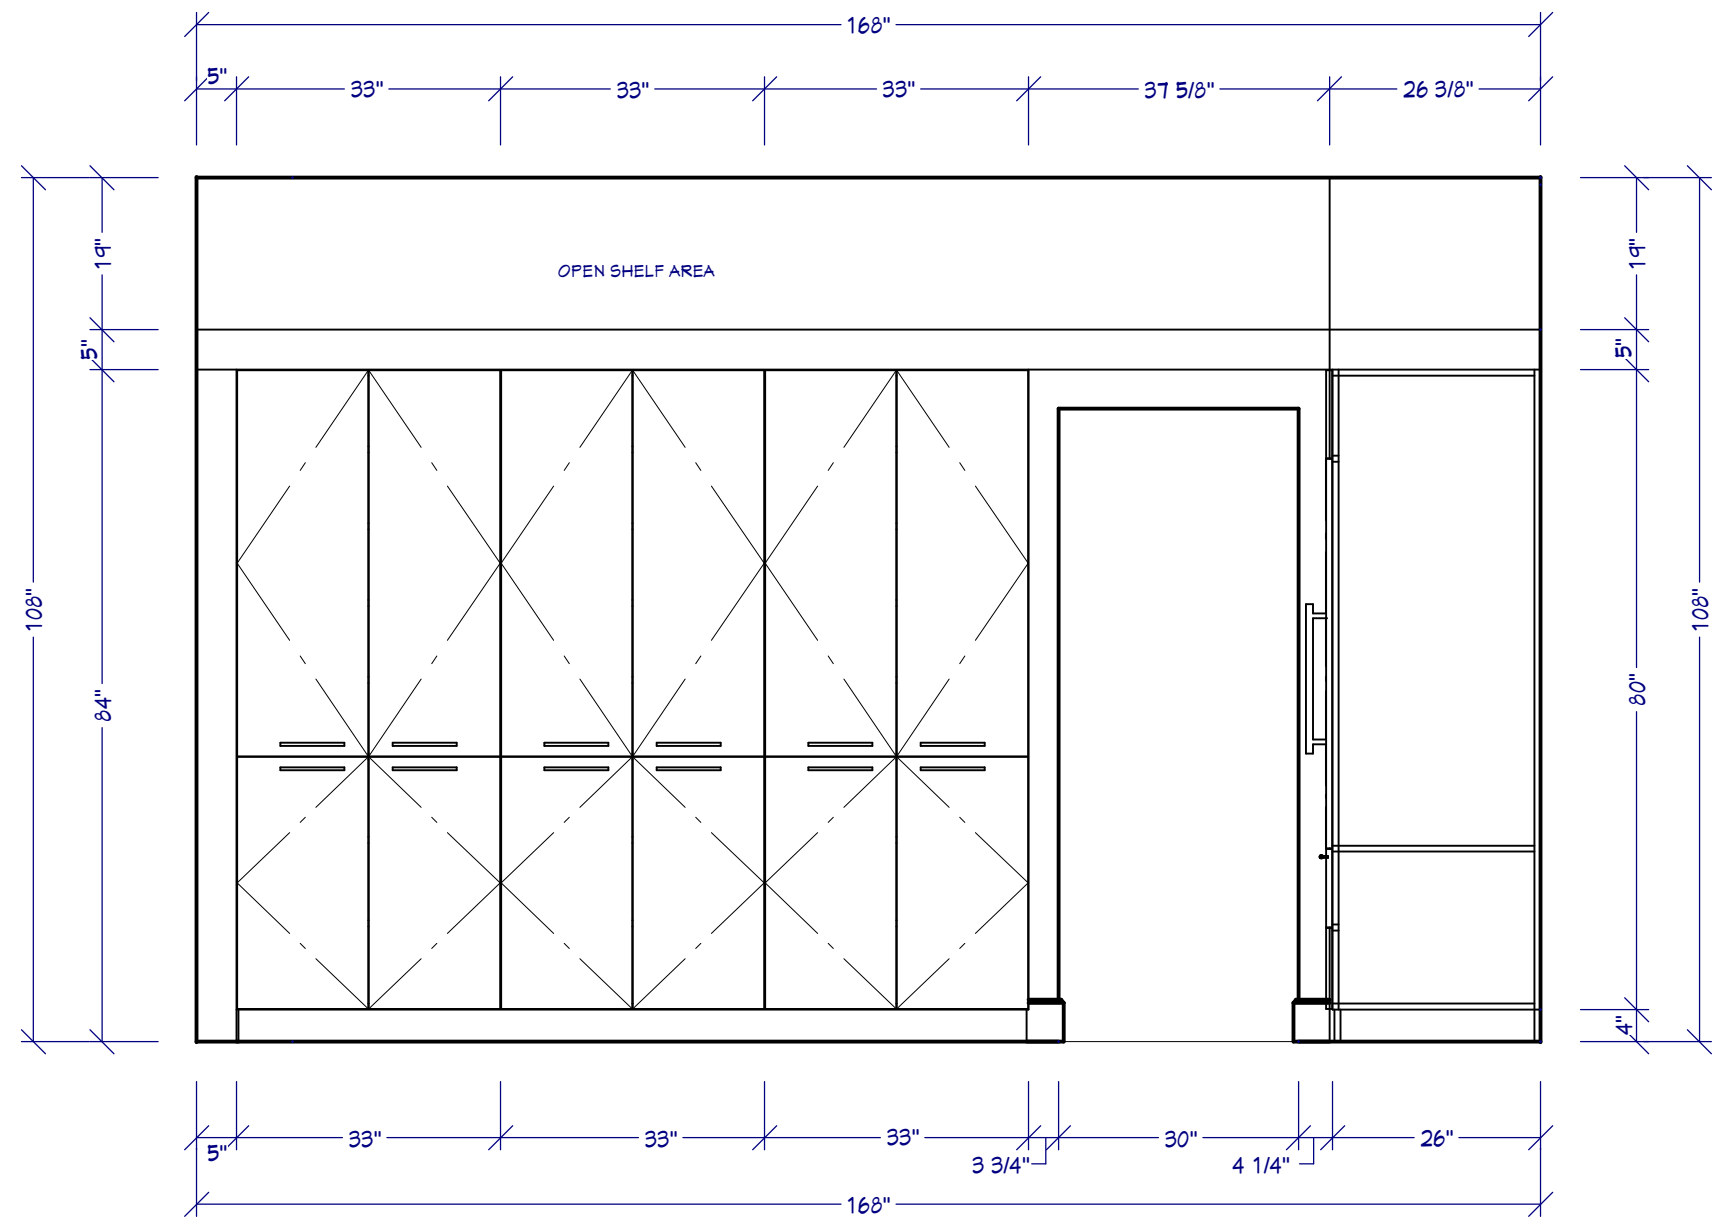


B **ELEVATION B**
1/2" = 1'

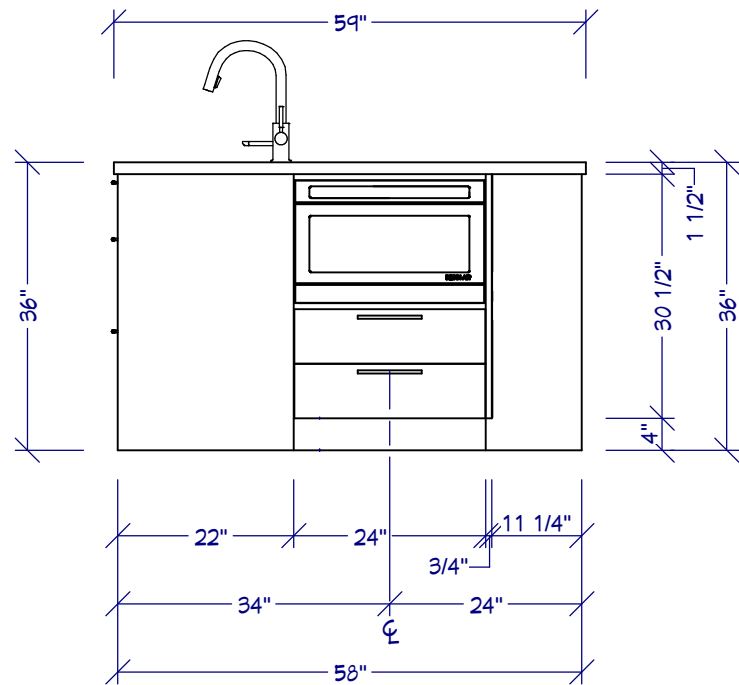


C ELEVATION C
1/2" = 1'

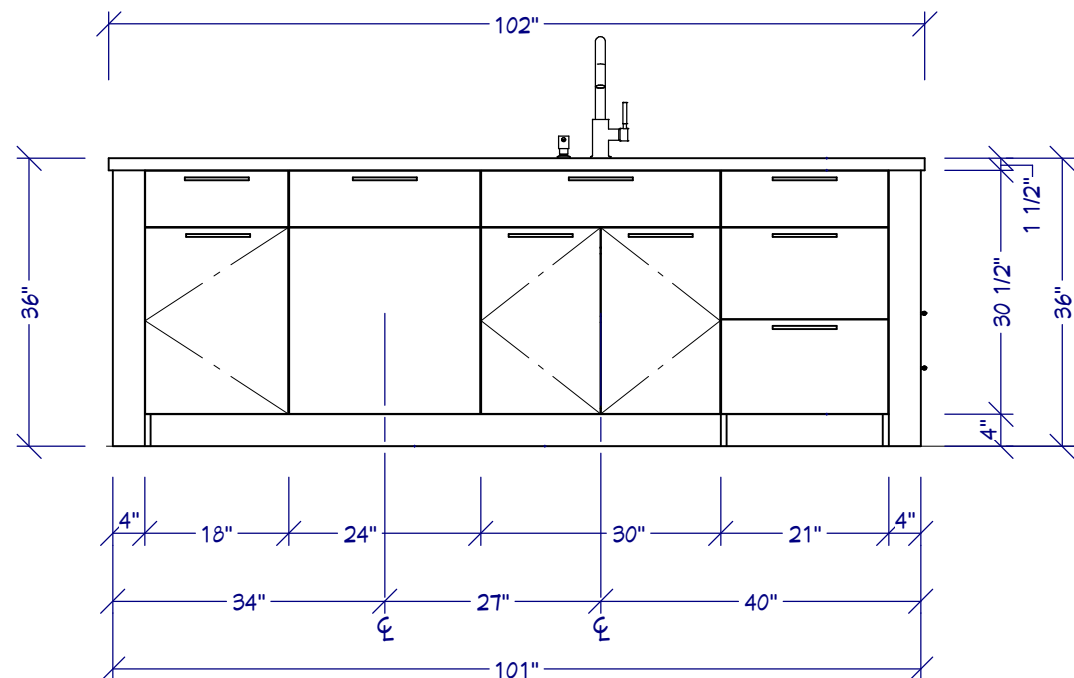

D ELEVATION D
1/2" = 1'

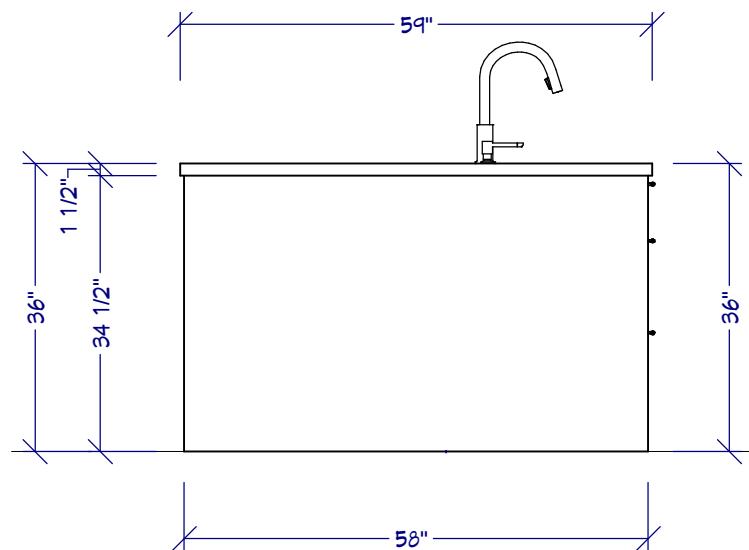

E ELEVATION E
1/2" = 1'

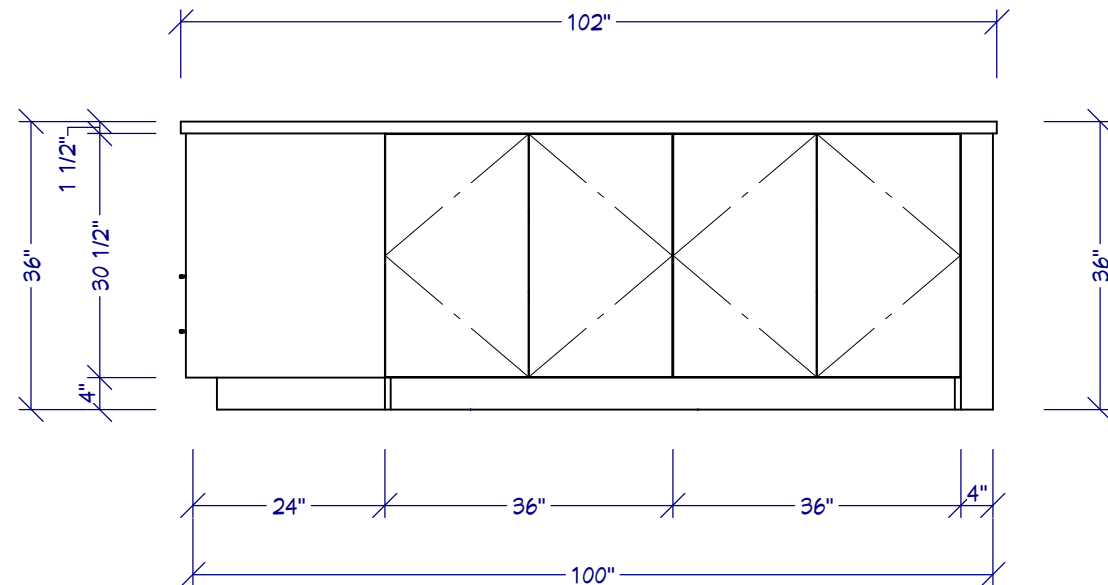

F ELEVATION F
1/2" = 1'



PERSPECTIVE WATERCOLOR
NO SCALE



DRAWINGS PROVIDED BY: ams
Chief Architect Software
chiefarchitect.com
800.292.3400

DESIGNER:
Lauren Levant
Lauren Levant Interior

PROJECT DESCRIPTION:
NKBA Study Guide:
Medium Kitchen

SHEET TITLE:
PERSPECTIVE

SCALE:
SEE VIEW

DATE:
7/14/2017

K-7



FINAL PHOTOGRAPHY
NO SCALE



DRAWINGS PROVIDED BY: ams
Chief Architect Software
chiefarchitect.com
800.292.3400

DESIGNER:
Lauren Levant
Lauren Levant Interior

PROJECT DESCRIPTION:
NKBA Study Guide:
Medium Kitchen

SHEET TITLE:
FINAL PHOTOS

SCALE:
SEE VIEW

DATE:
7/14/2017

K-8