




## NKBA STUDY GUIDE: SMALL BATHROOM

design by:

Danielle Burger, CKBD - Kitchen Vitality Design

---

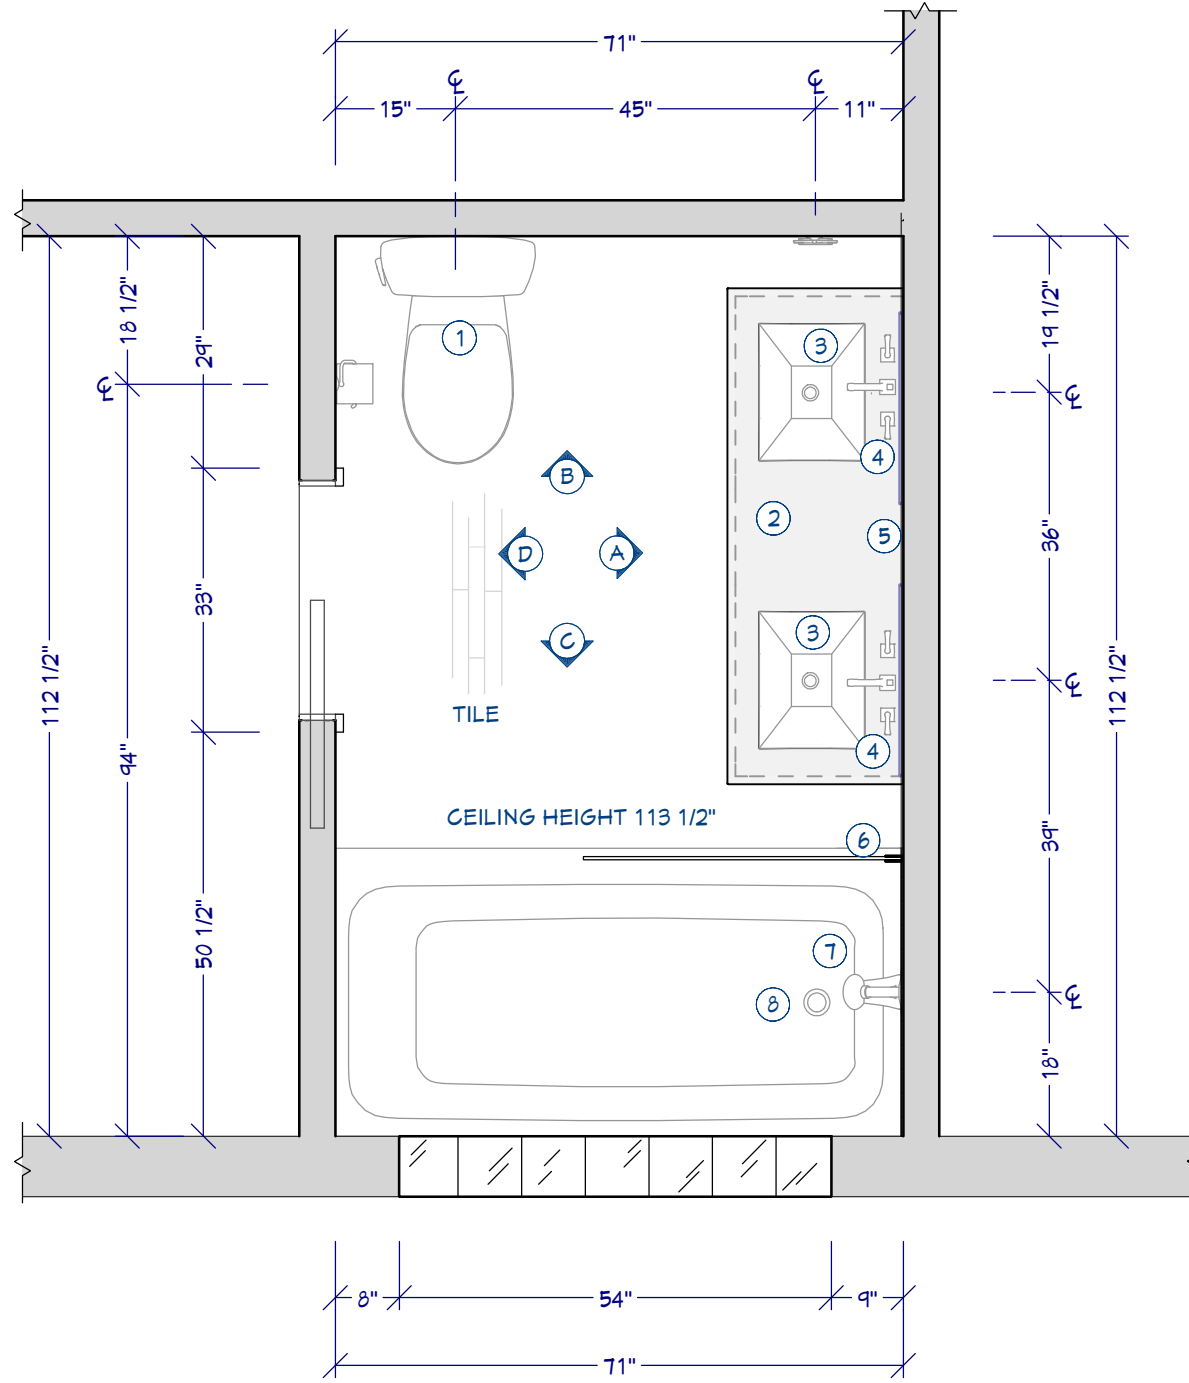

**FLOOR PLAN SPECIFICATIONS:**

- ① ELONGATED TOILET BRAND ABC, MDL. 123
- ② VANITY BRAND ABC, MDL. 234
- ③ UNDERMOUNT SINKS BRAND ABC, MDL.345
- ④ FAUCETS BRAND ABC, MDL.456
- ⑤ MIRRORS 24X48 BRAND ABC, MDL.123
- ⑥ GLASS PANEL 40X72 LOW IRON CLEAR 3/8 TEMPERED GLASS
- ⑦ TUB SHOWER ROUGH AND TRIM BRAND ABC, MDL. 123
- ⑧ SOAKING TUB BRAND ABC, MDL.234  
POLISHED CHROME DRAIN BRAND ABC, MDL. 345

**FLOOR PLAN**

1/2" = 1'

DRAWINGS PROVIDED BY: ams  
 Chief Architect Software  
 chiefarchitect.com  
 800.482.4433

DESIGNER:  
 Danielle Burger, CKBD  
 Kitchen Vitality Design


PROJECT DESCRIPTION:  
 NKBA Study Guide:  
 Small Bathroom

SHEET TITLE:  
 FLOOR PLAN


SCALE:  
 SEE VIEW

DATE:  
 7/14/2017

**B-1**

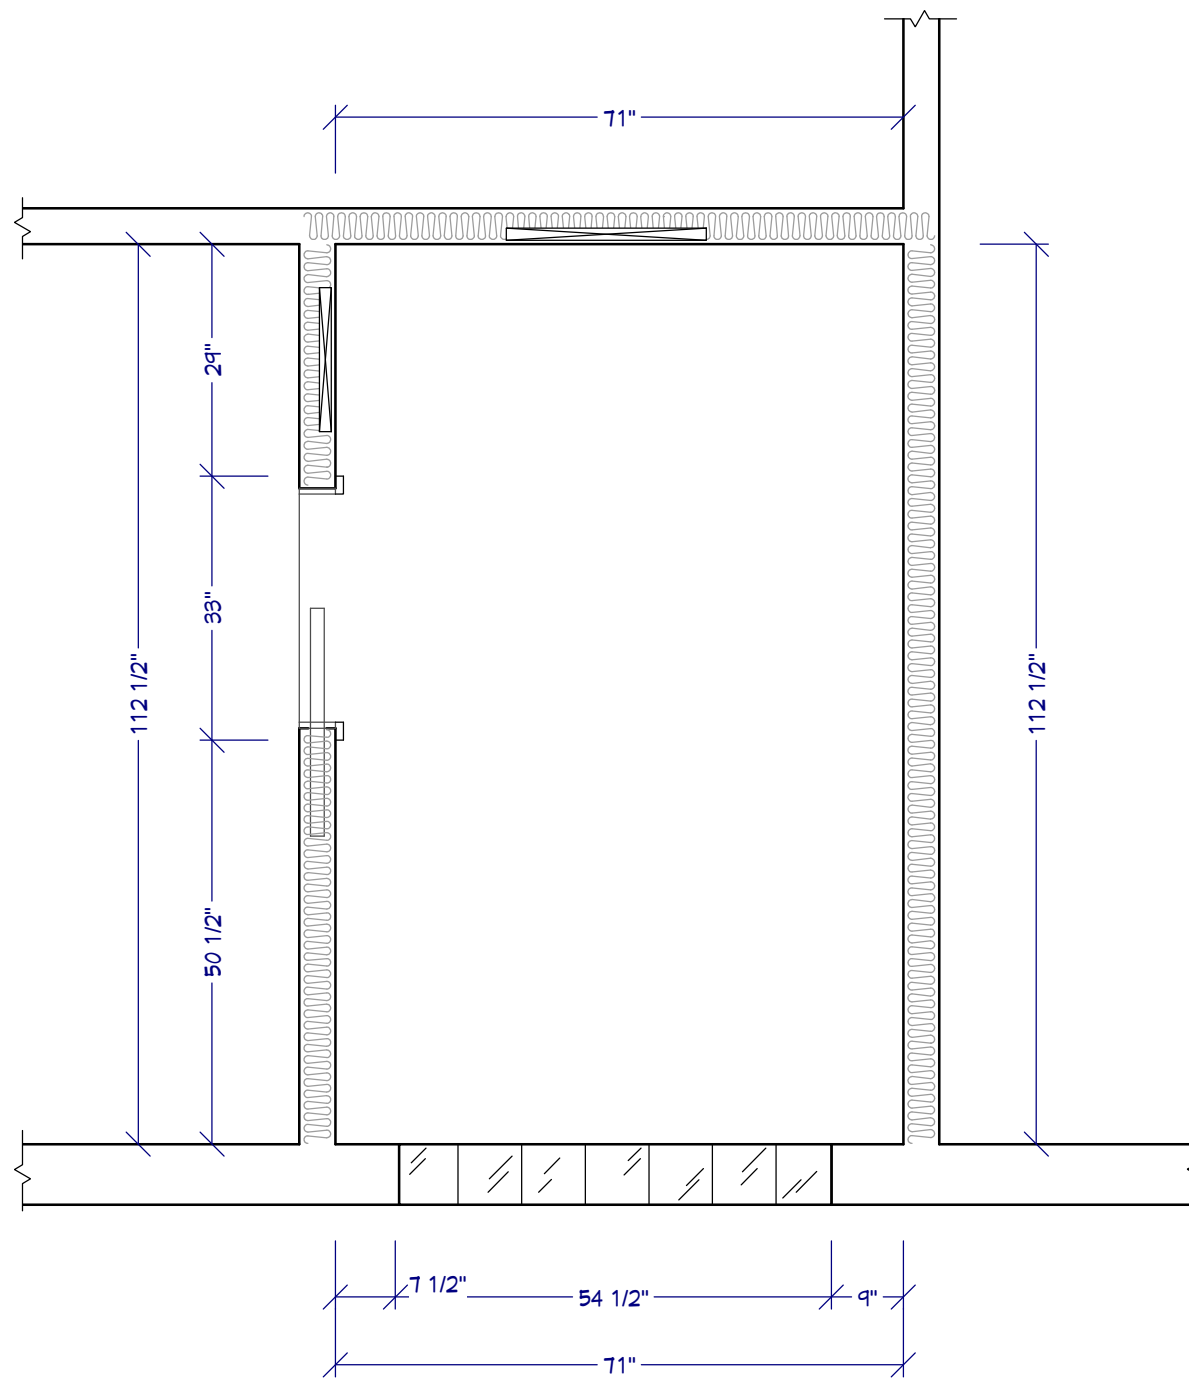

**CONSTRUCTION LEGEND:**

 

**CONSTRUCTION PLAN**

1/2" = 1'

DRAWINGS PROVIDED BY: ams  
 Chief Architect Software  
 chiefarchitect.com  
 800.482.4433

DESIGNER:  
 Danielle Burger, CKBD  
 Kitchen Vitality Design


PROJECT DESCRIPTION:  
 NKBA Study Guide:  
 Small Bathroom

SHEET TITLE:  
**CONSTRUCTION PLAN**





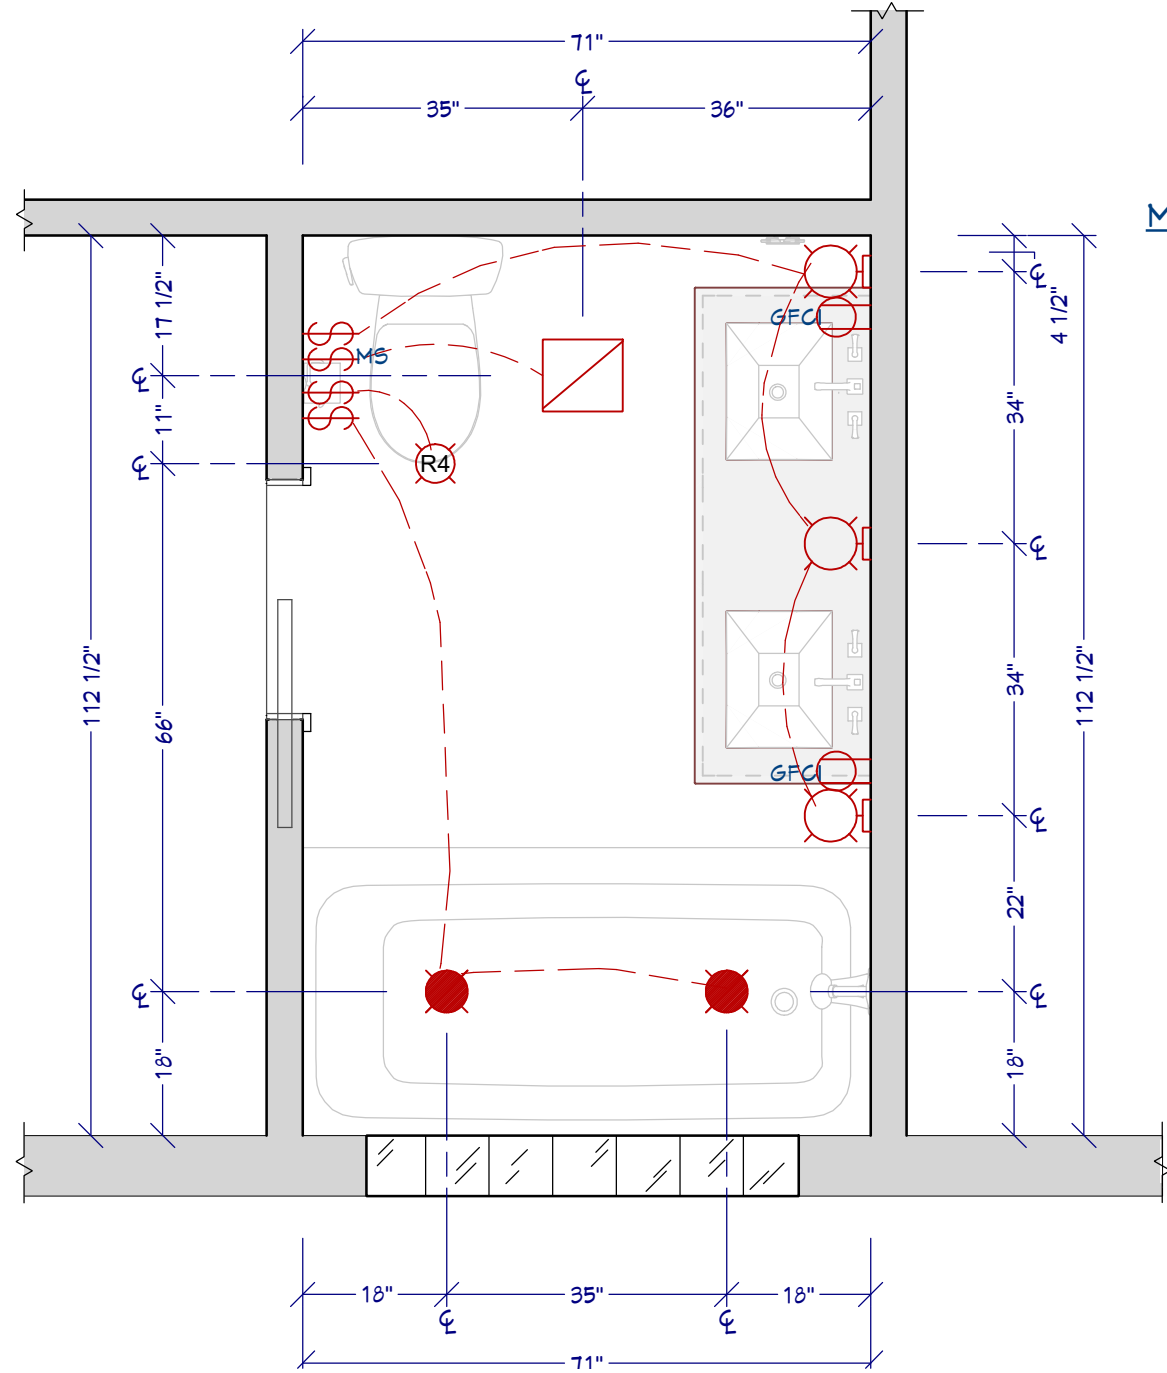


SCALE:  
 SEE VIEW

DATE:  
 7/14/2017

**B-2**



 **MECHANICAL LEGEND:**

-  GLASS WALL SCONCE @ 76 1/2" AFF
-  GFCI  
GROUND FAULT CIRCUIT INTERRUPTER
-  R4  
4" RECESSED CAN LIGHTS BRAND ABC, MDL 123
-  4" RECESSED CAN LIGHTS RATED FOR DAMP LOCATION BRAND ABC, MDL 123
-  SINGLE POLE SWITCH
-  MS  
MOISTURE SENSOR SWITCH
-  EXISTING EXHAUST FAN w/150 CFM BRAND ABC, MDL 123

ALL SWITCHES AND RECEPTACLES ARE MOUNTED 48" AT TOP OF SWITCH PLATE ABOVE FINISHED FLOOR (AFF) UNLESS OTHERWISE NOTED

**MECHANICAL PLAN**

1/2" = 1'

DRAWINGS PROVIDED BY: ams  
 Chief Architect Software  
 chiefarchitect.com  
 800.482.4433

DESIGNER:  
 Danielle Burger, CKBD  
 Kitchen Vitality Design

PROJECT DESCRIPTION:  
 NKBA Study Guide:  
 Small Bathroom


SHEET TITLE:  
 MECHANICAL PLAN

SCALE:  
 SEE VIEW


DATE:  
 7/14/2017

**B-3**




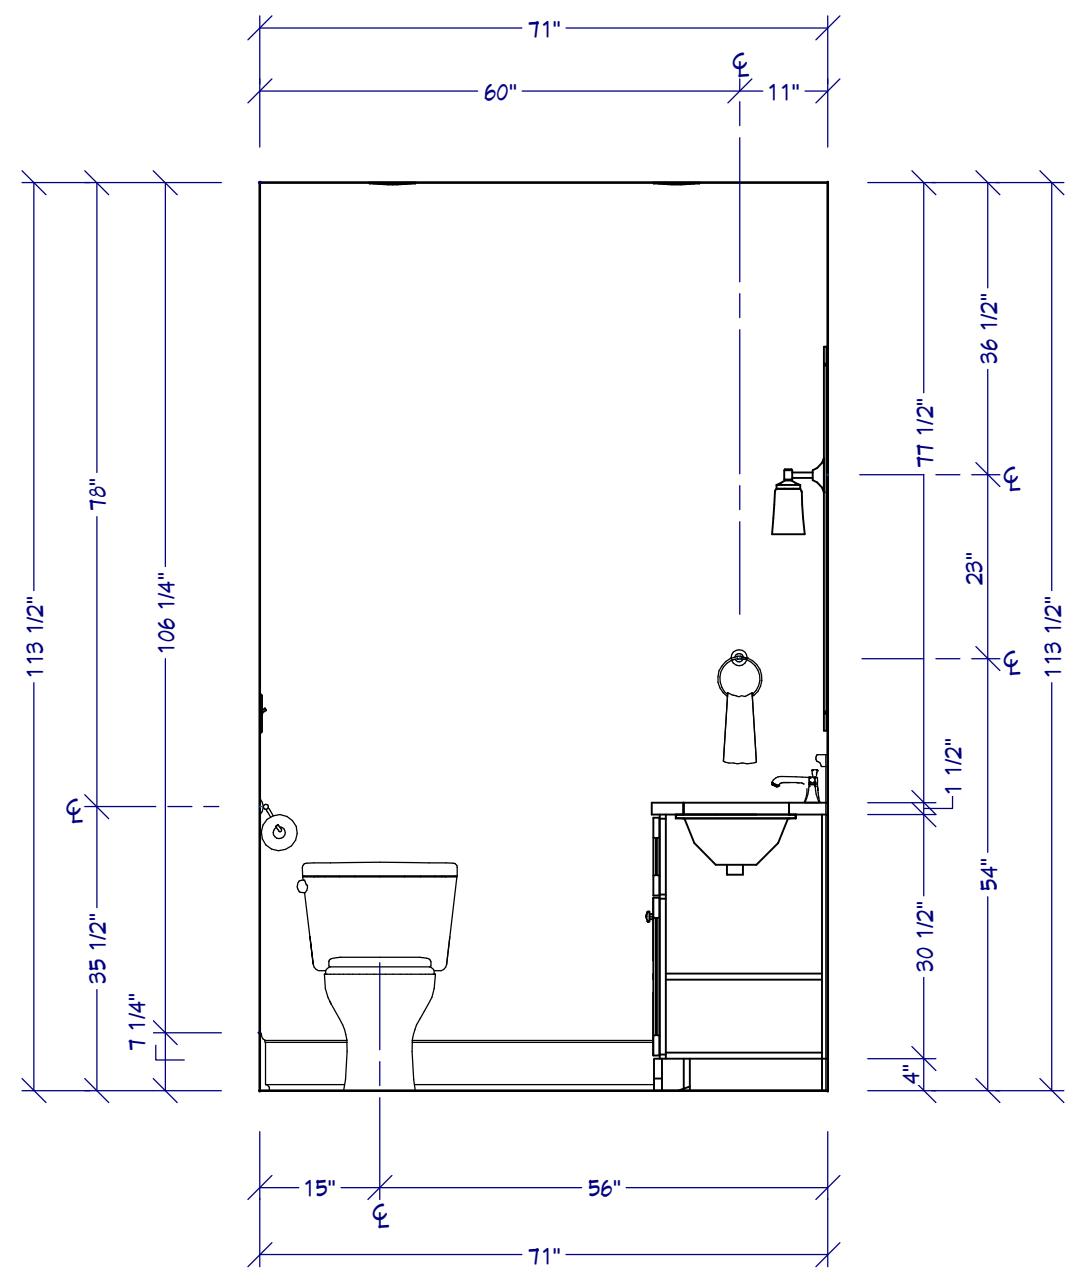

**B** ELEVATION B  
1/2" = 1'

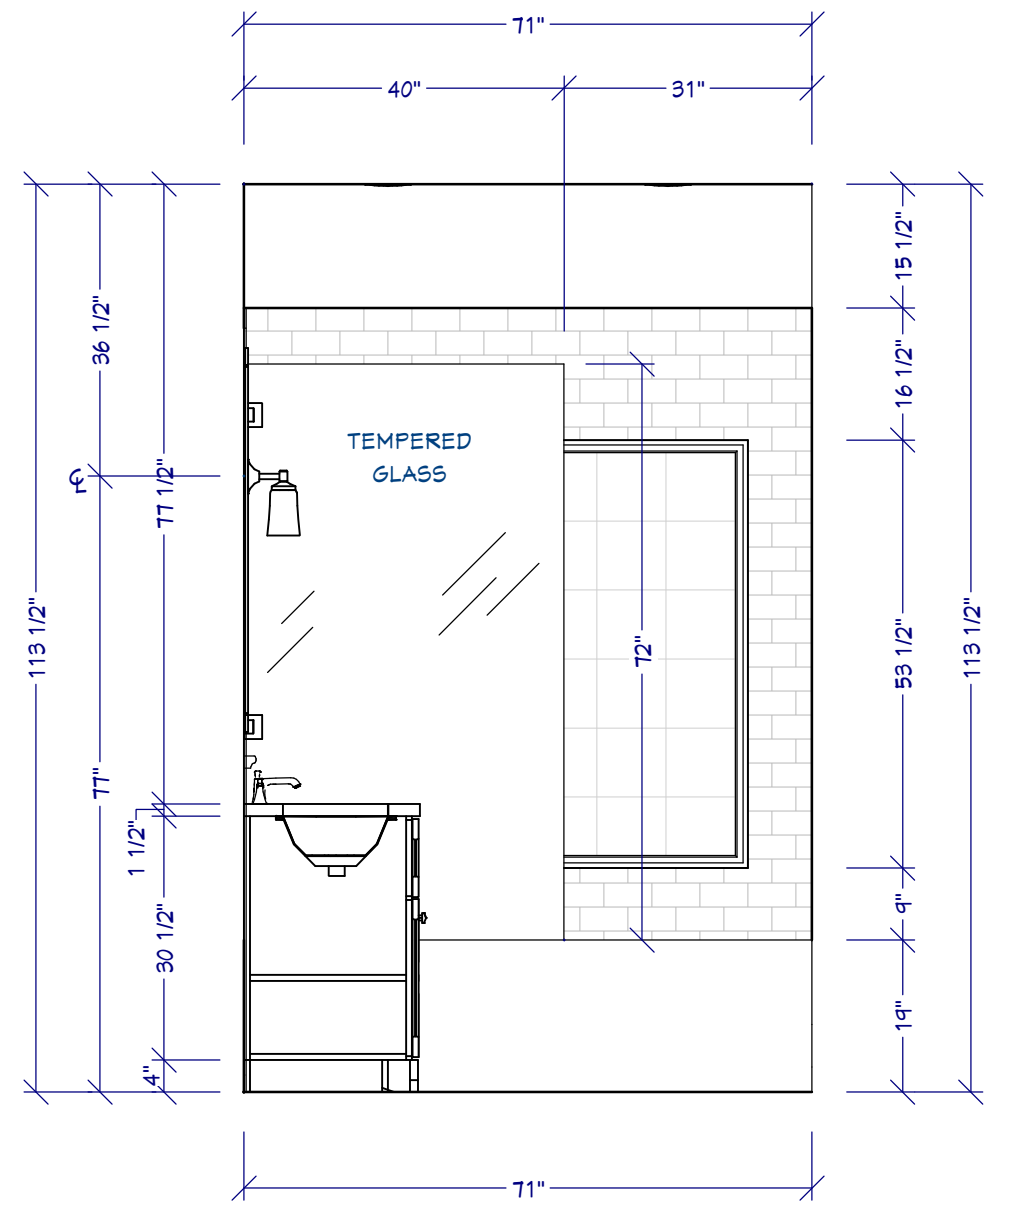

**C** ELEVATION C  
1/2" = 1'

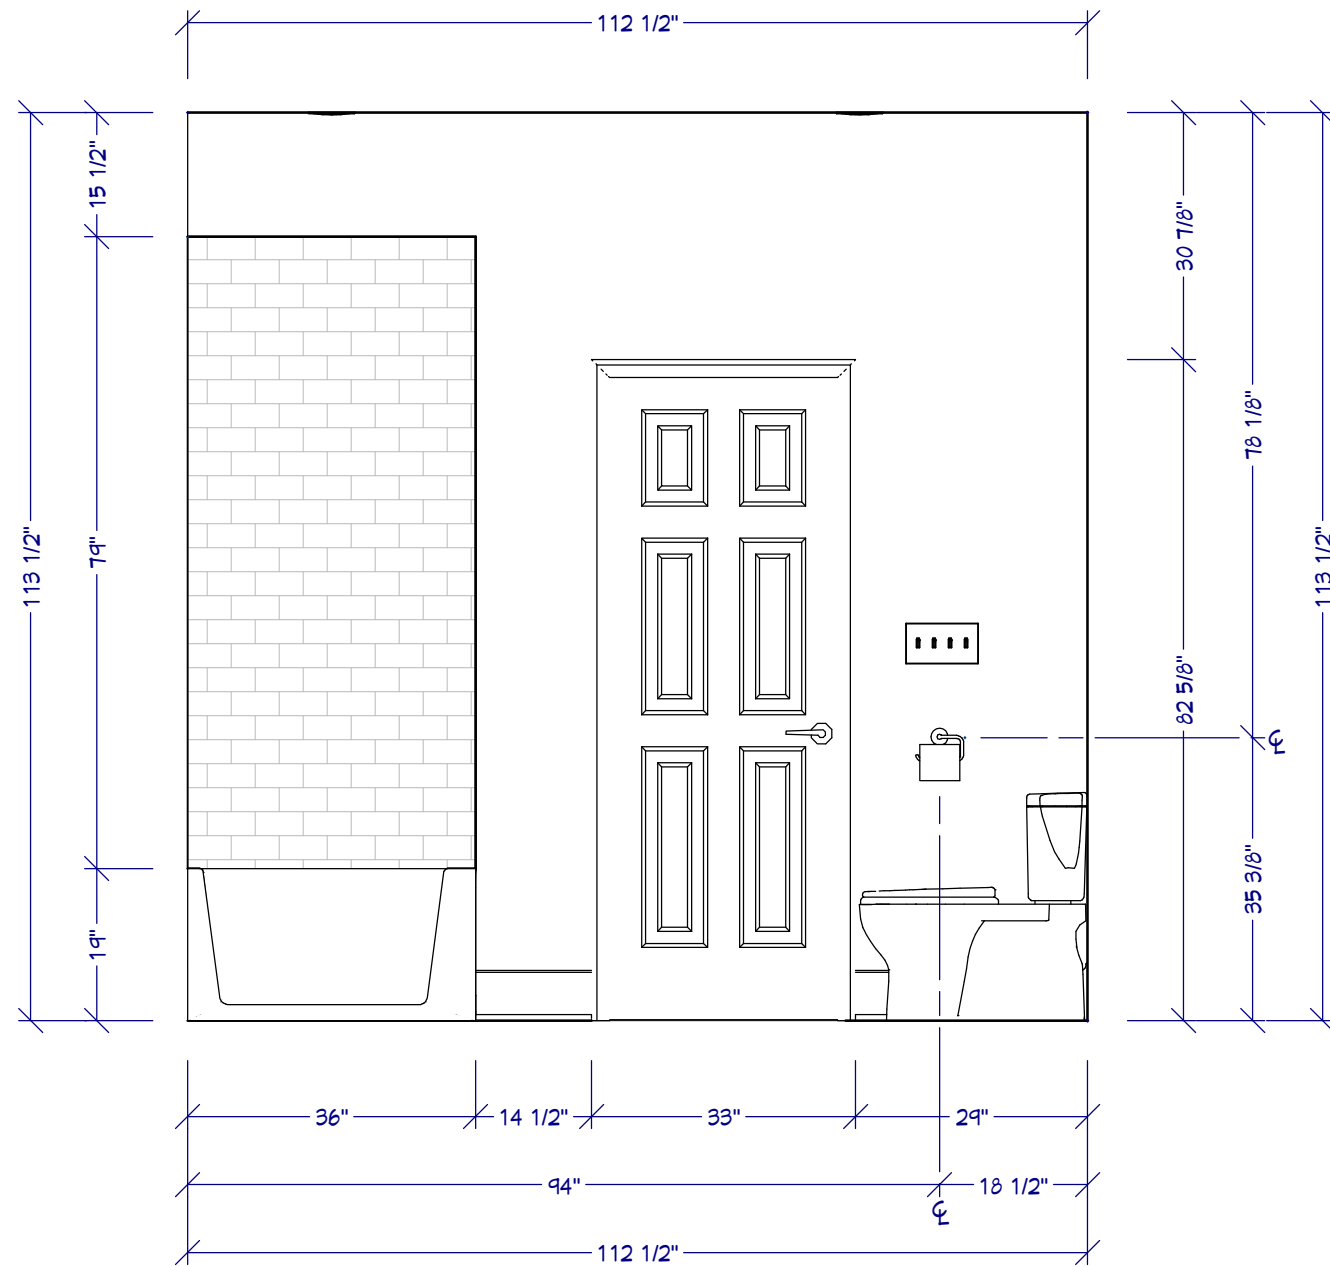

**D** ELEVATION D  
1/2" = 1'

DRAWINGS PROVIDED BY: ams  
 Chief Architect Software  
 chiefarchitect.com  
 800.482.4433

DESIGNER:  
 Danielle Burger, CKBD  
 Kitchen Vitality Design

PROJECT DESCRIPTION:  
 NKBA Study Guide:  
 Small Bathroom

SHEET TITLE:  
 ELEVATIONS

SCALE:  
 SEE VIEW

DATE:  
 7/14/2017

**B-6**



**PERSPECTIVE WATERCOLOR**  
NO SCALE

DRAWINGS PROVIDED BY: ams  
 Chief Architect Software  
chiefarchitect.com  
800.482.4433

DESIGNER:  
Danielle Burger, CKBD  
Kitchen Vitality Design

PROJECT DESCRIPTION:  
NKBA Study Guide:  
Small Bathroom

SHEET TITLE:  
**PERSPECTIVE**

SCALE:  
SEE VIEW

DATE:  
7/14/2017

**B-7**





DRAWINGS PROVIDED BY: ams  
 Chief Architect Software  
 chiefarchitect.com  
 800.482.4433

DESIGNER:  
 Danielle Burger, CKBD  
 Kitchen Vitality Design

PROJECT DESCRIPTION:  
 NKBA Study Guide:  
 Small Bathroom

SHEET TITLE:  
 FINAL PHOTOS

SCALE:  
 SEE VIEW

DATE:  
 7/14/2017

**B-8**