




CONSTRUCTION LEGEND

-  EXISTING WALL
-  WALL REMOVED
-  OPENING CLOSED

CONSTRUCTION PLAN
1/2" = 1'



DRAWINGS PROVIDED BY:
Designer Information
© 2016 CHIEF ARCHITECT SOFTWARE

CLIENT INFORMATION:
SMITH RESIDENCE


PROJECT DESCRIPTION:
NKBA Exam Sample

SHEET TITLE:
CONSTRUCTION PLAN DRAWING

SCALE:
1/2" = 1'

DATE:


SHEET #
1

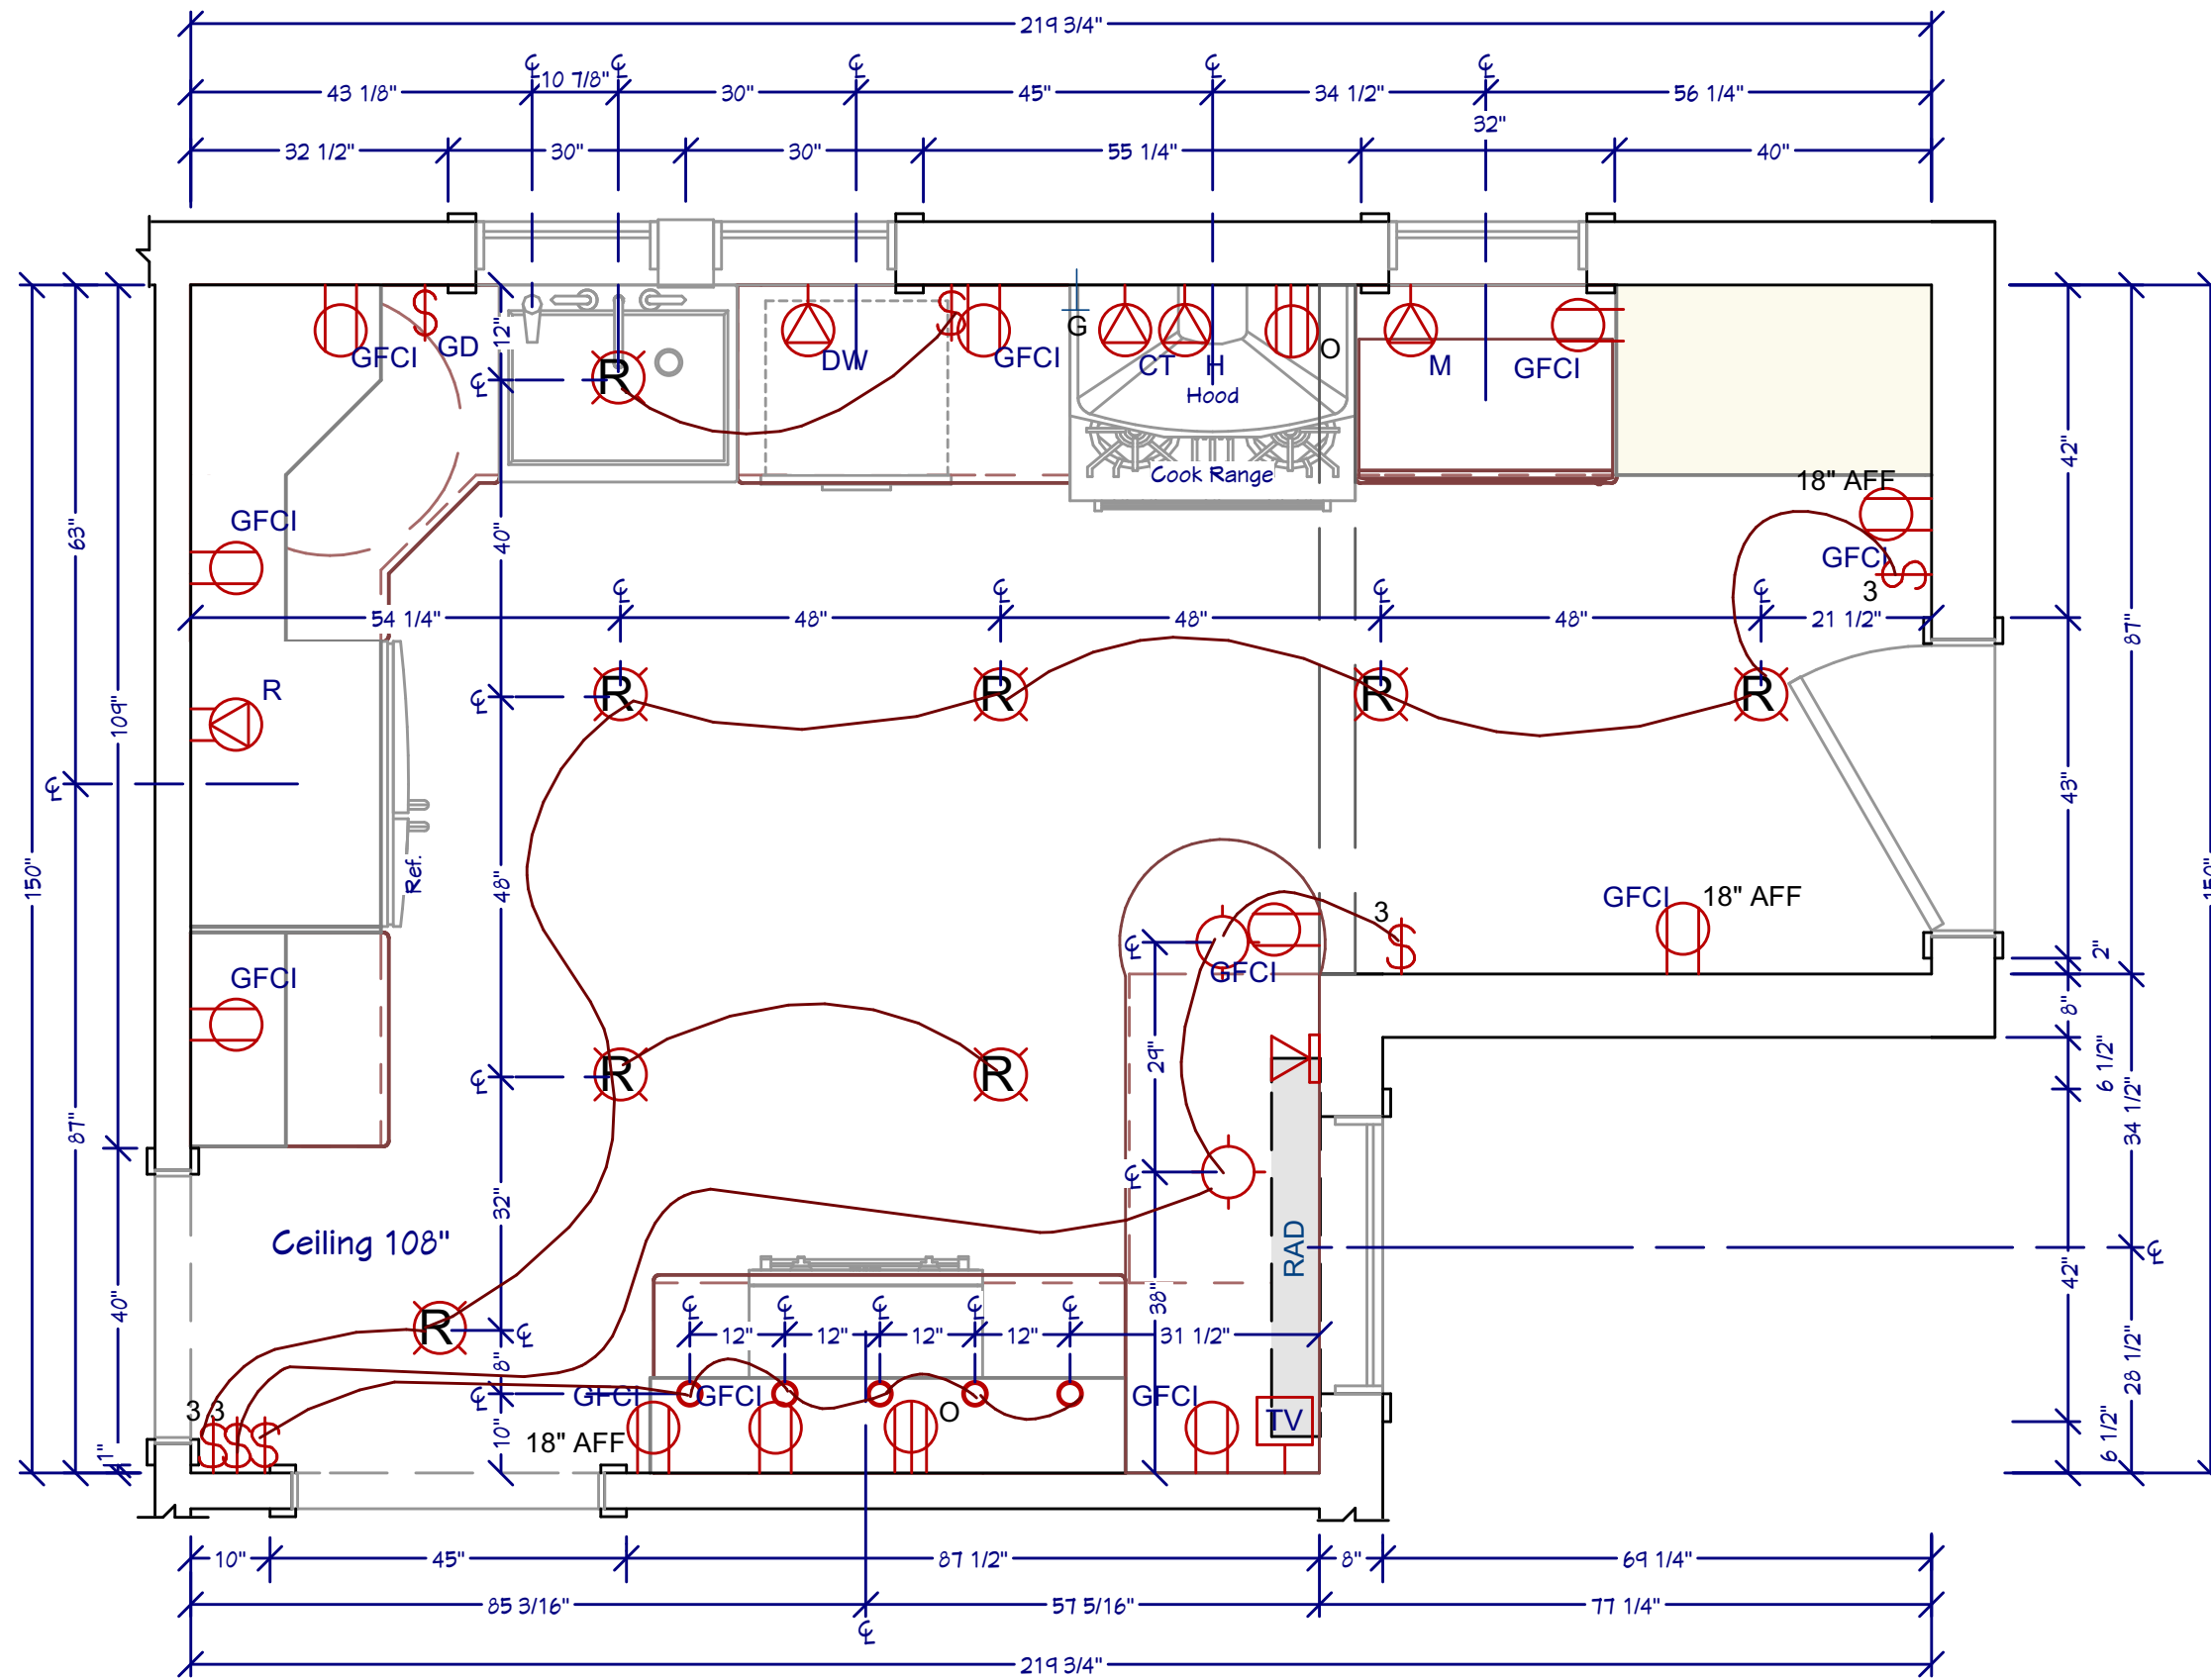

MECHANICAL LEGEND

-  SWITCH
 -  3WAY SWITCH
 -  GARBAGE DISPOSAL
 -  GFCI OUTLET
 -  MICROWAVE BRAND ABC, 120V
 -  DISHWASHER BRAND ABC, 120V
 -  GAS OUTLET COOK RANGE
 -  COOK RANGE BRAND ABC, GAS/ 220V
 -  VENT HOOD 600 CFM BRAND ABC, 120V
 -  REFRIGERATOR BRAND ABC, 120V
 -  (2) OVEN BRAND ABC, 220V
 -  TV OUTLET
 -  TELEPHONE JACK
 -  RECESSED LIGHT BRAND ABC, 120V
 -  PENDANT LIGHT BRAND ABC, 120V
 -  UNDER CAB LIGHTS HALOGEN BRAND ABC, 12VDC/120V
- ALL OUTLETS/SWITCHES 42" AFF UNO


MECHANICAL PLAN
1/2" = 1'

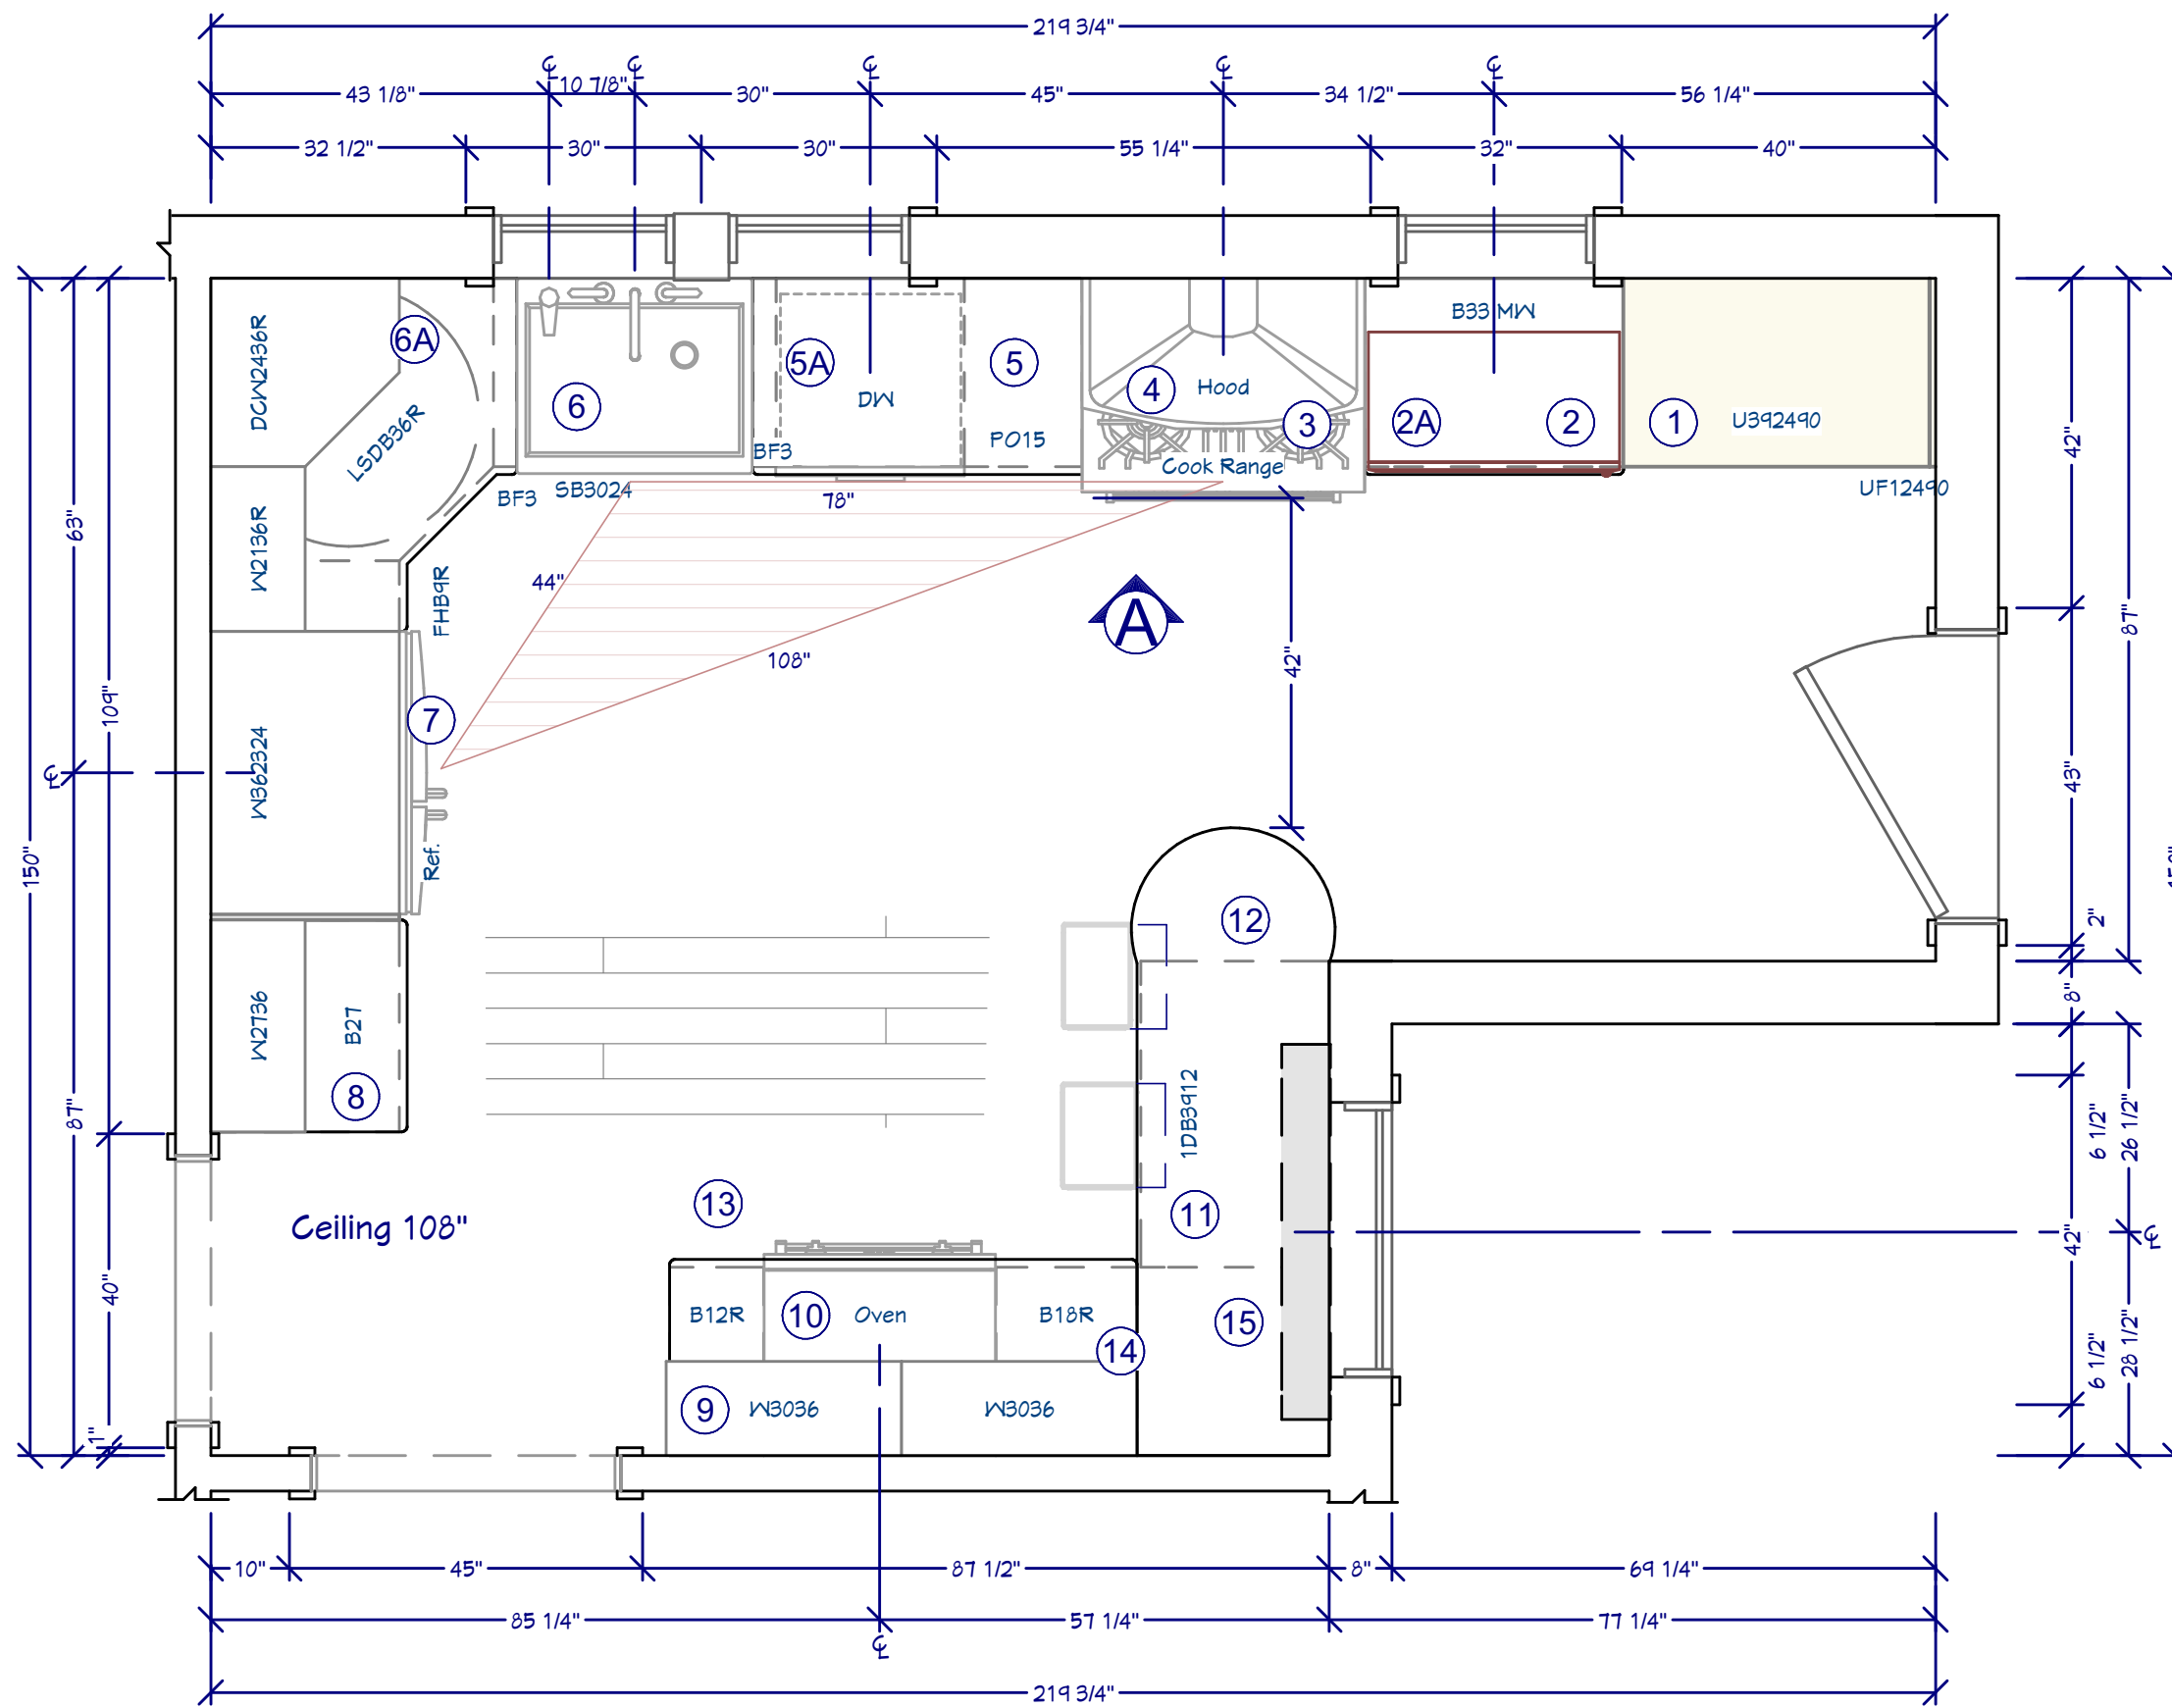

PLAN SPECIFICATIONS

- 1 PANTRY 4 ROTS
- 2 MICROWAVE BRAND ABC, MODEL 123
- 2A DRAWER DIVIDER INSERT BRAND ABC, MODEL 123
- 3 COOK RANGE BRAND ABC, MODEL 123
- 4 VENT HOOD 600 CFM BRAND ABC, MODEL 123
- 5 RECYCLE PULLOUT
- 5A SS DW BRAND ABC, MODEL 123
- 6 APRON SINK BRAND ABC, MODEL 123
- 6A TOWEL BAR BRAND ABC, MODEL 123
- 7 REFRIGERATOR BRAND ABC, MODEL 123
- 8 TILT DRAWER / 2 ROLLOUT SHELVES
- 9 GLASS DOORS/SHELVES
- 10 UNDER CAB OVEN BRAND ABC, MODEL 123
- 11 TILT DRAWER
- 12 BAR AREA 36"H OPEN BELOW DRAWER
- 13 LOW VOLTAGE TRANSFORMER + SPICE RACK
- 14 TRAY DIVIDERS
- 15 INTERCOM; TV; TELEPHONE BRANDS ABC, MODELS 123

FLOOR PLAN
1/2" = 1'

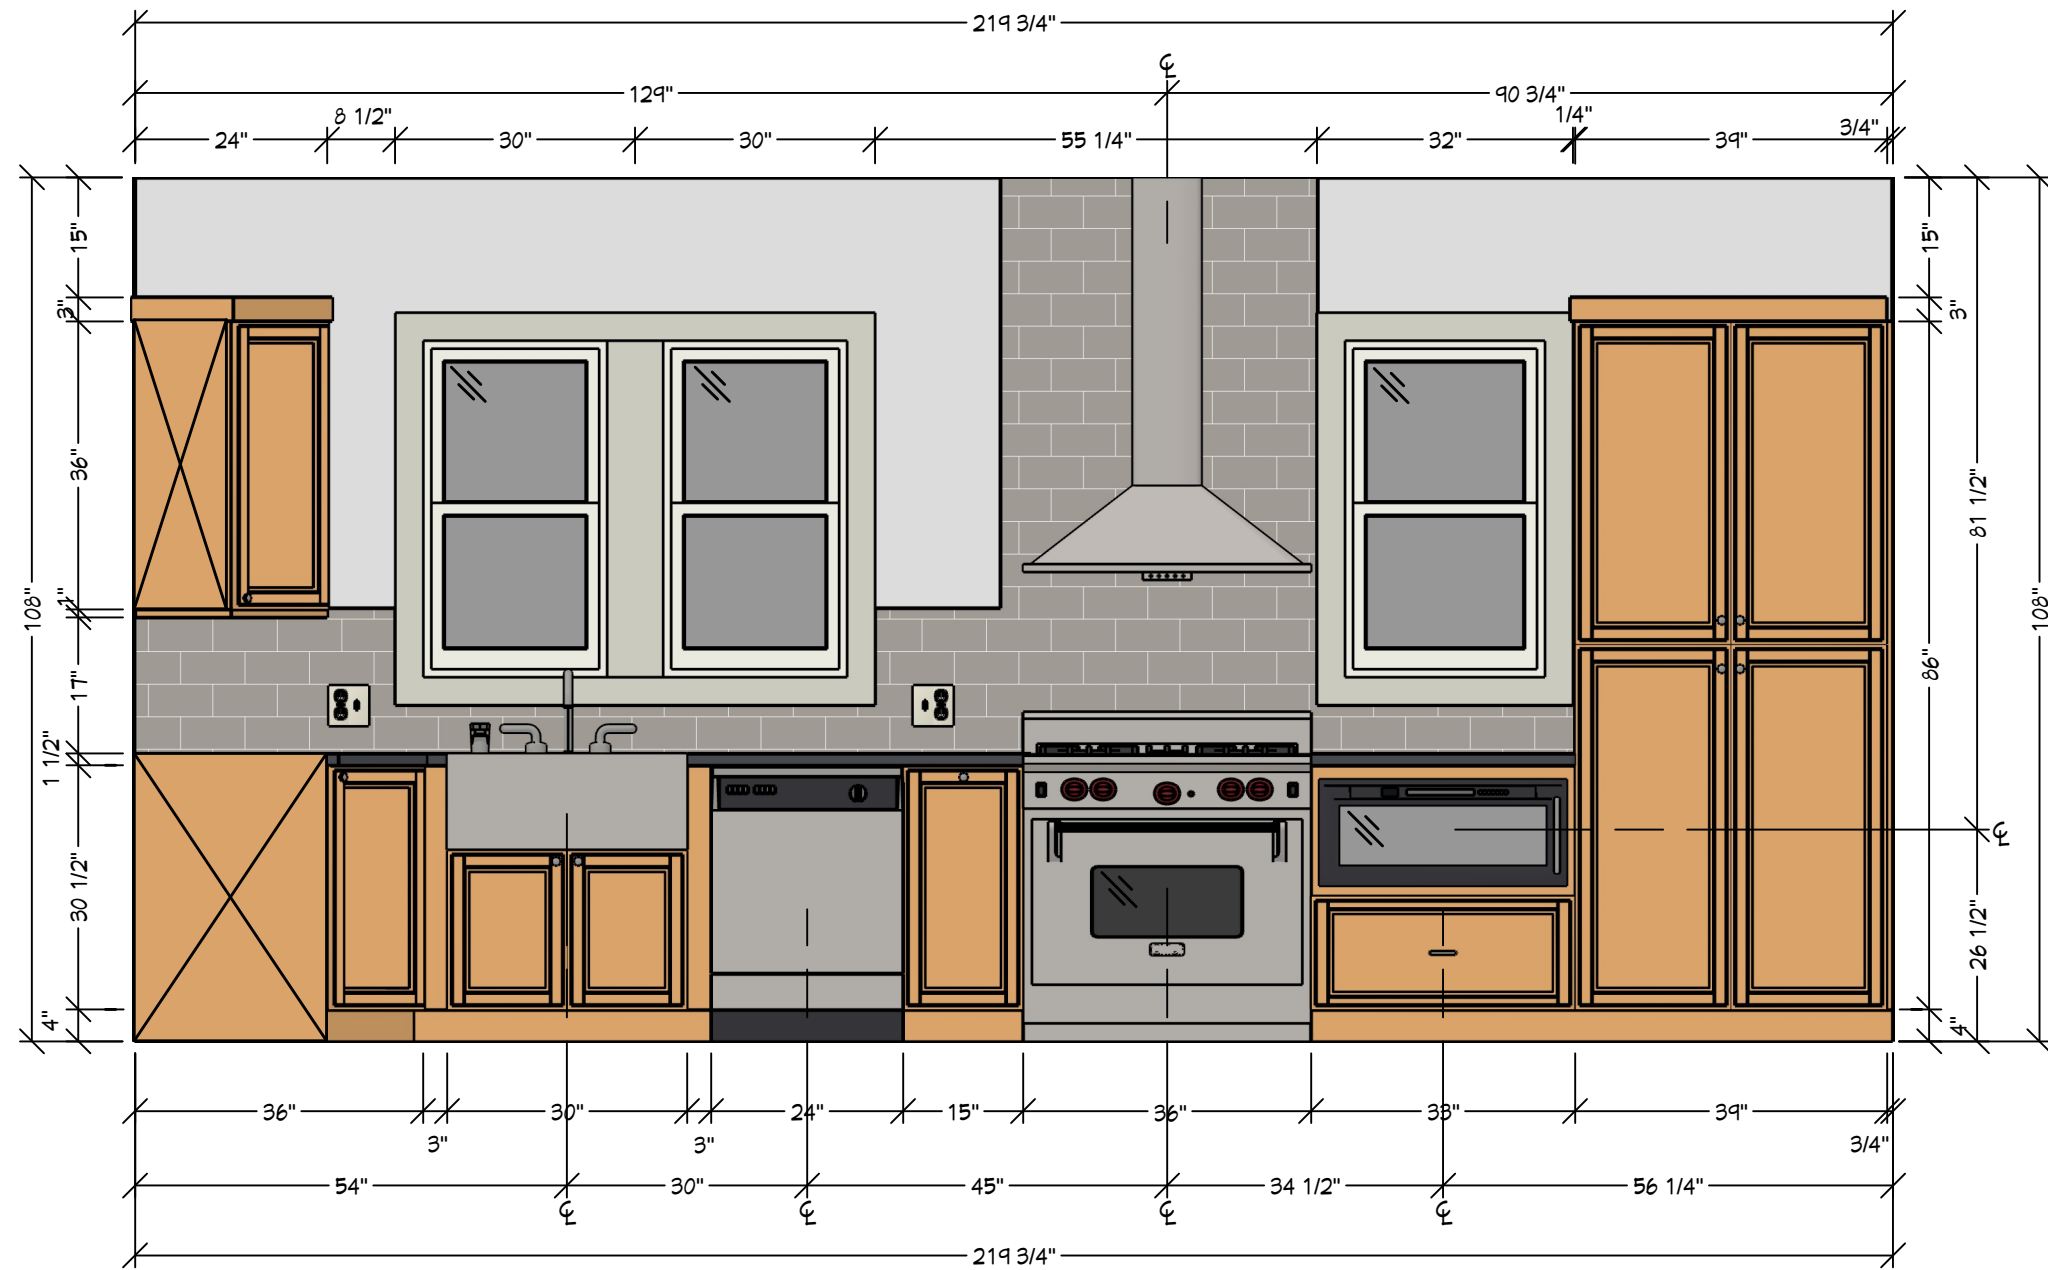

A MAIN WALL ELEVATION
1/2" = 1'



DRAWINGS PROVIDED BY:
Designer Information
© 2016 CHIEF ARCHITECT SOFTWARE

CLIENT INFORMATION:
SMITH RESIDENCE

PROJECT DESCRIPTION:
NKBA Exam Sample

SHEET TITLE:
WALL ELEVATION DRAWING

SCALE:
1/2" = 1'

DATE:

SHEET #
4